




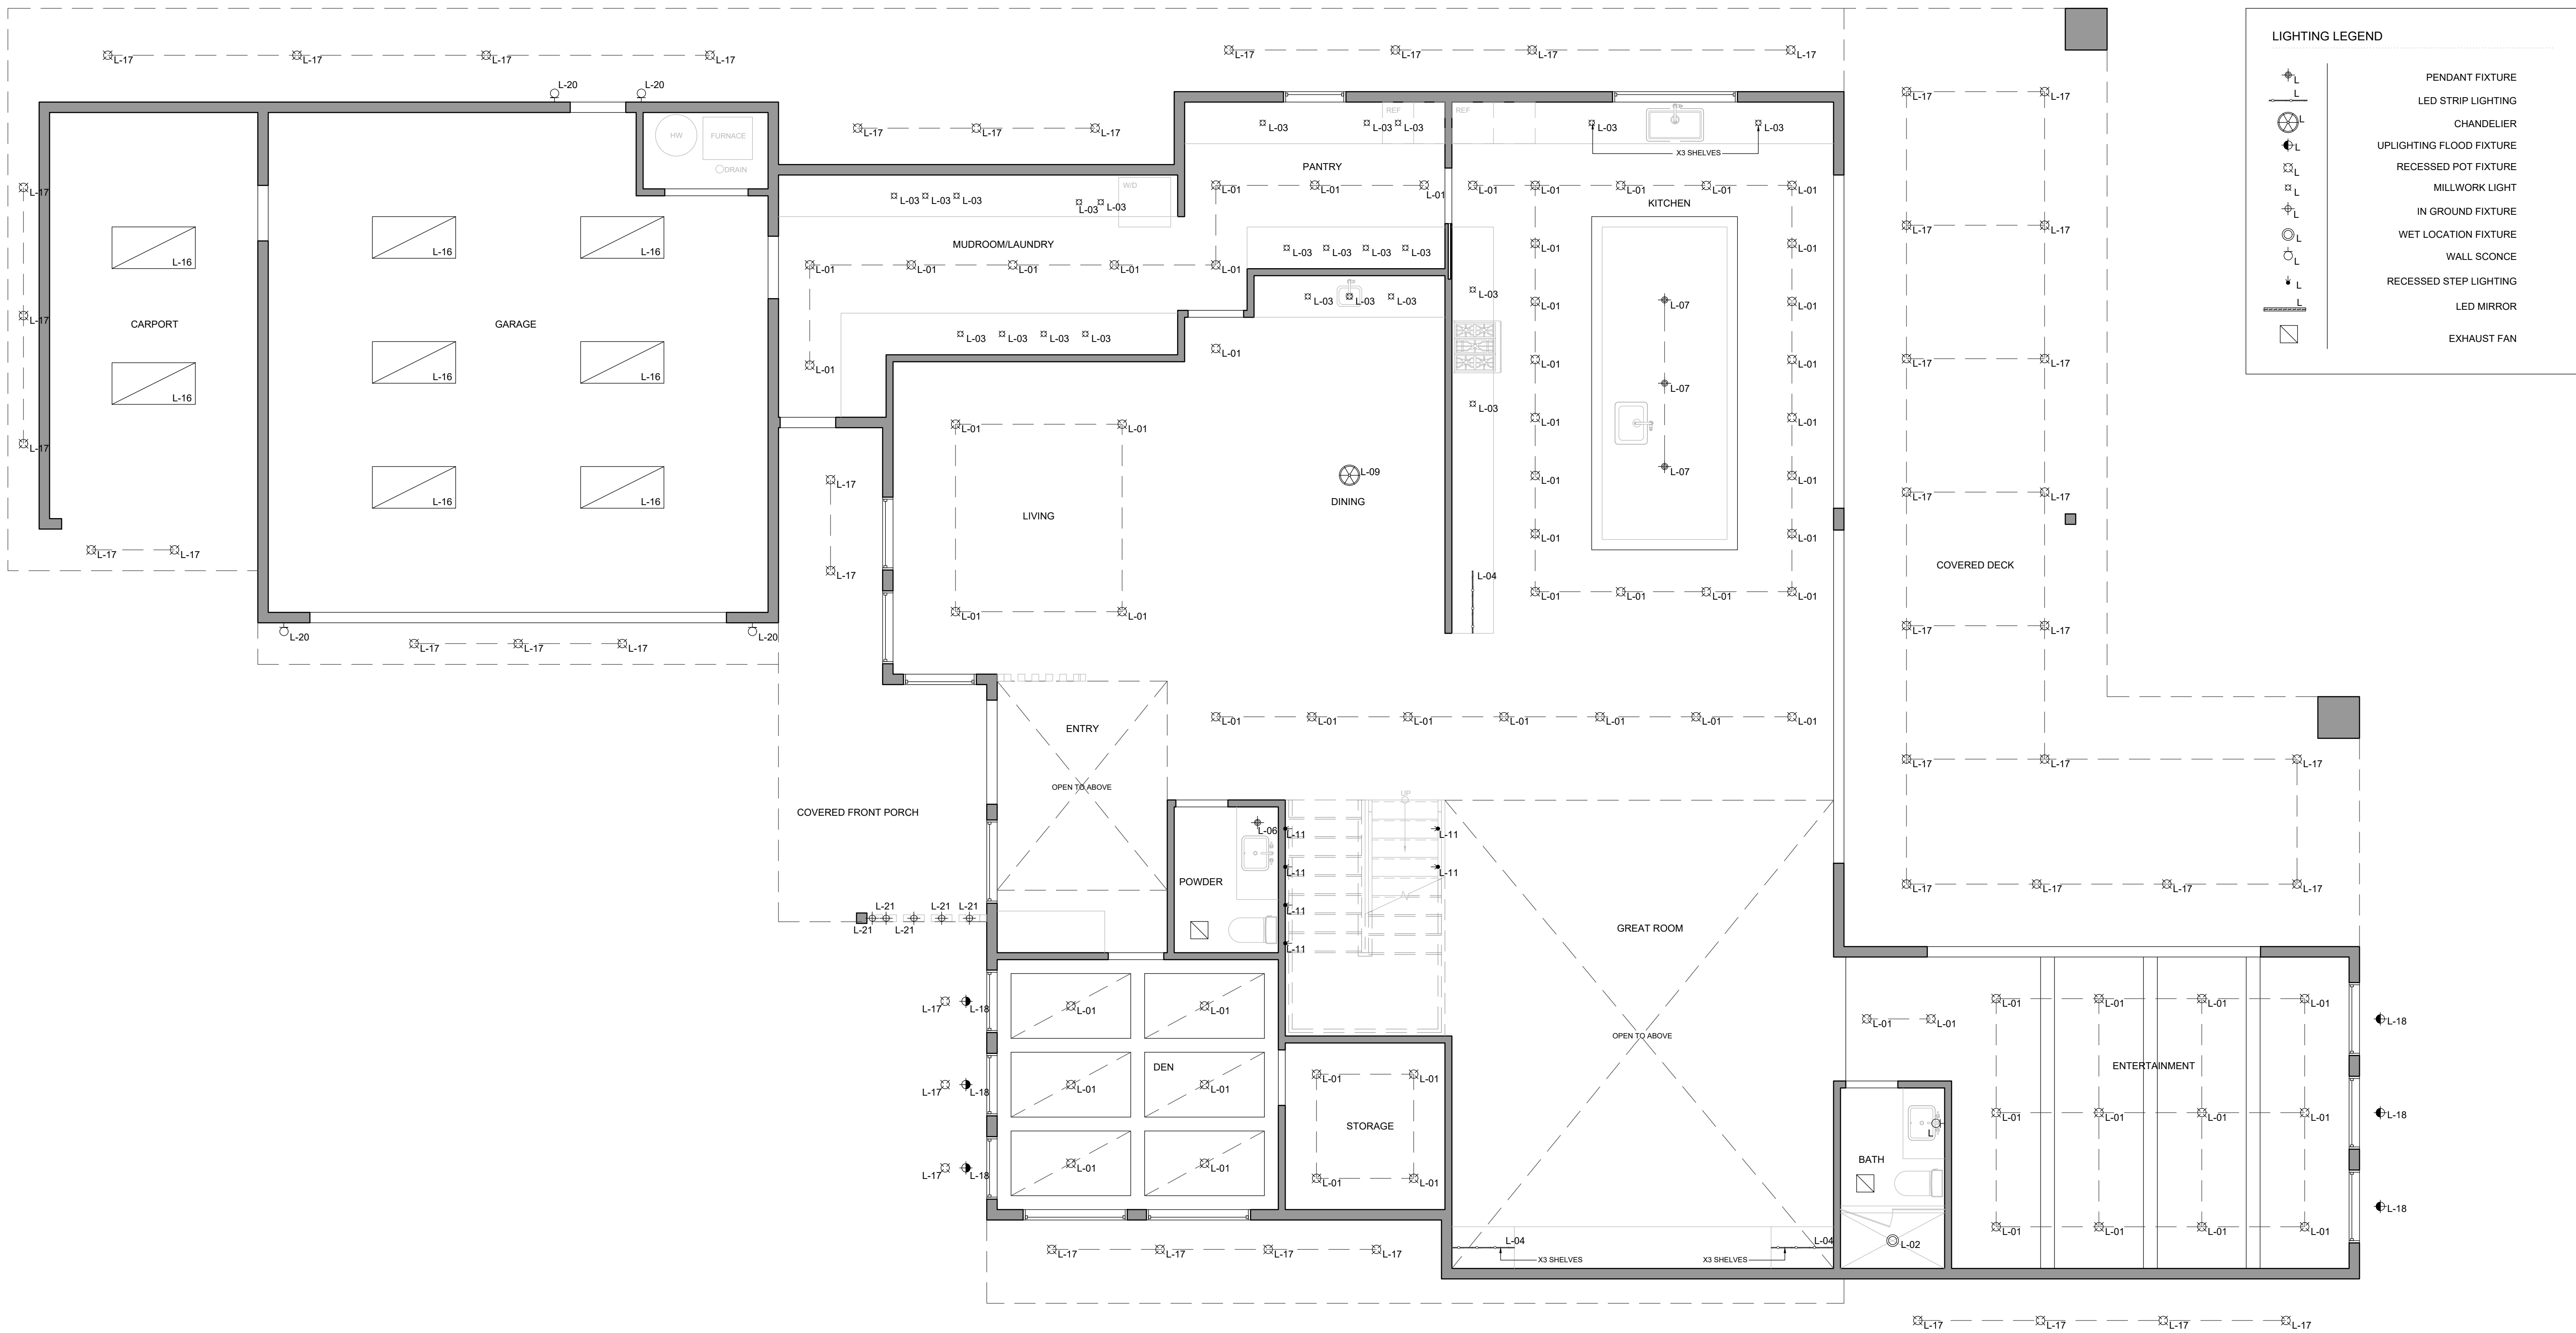

MAIN FLOOR - REFLECTED CEILING PLAN
ID1.0.1 SCALE: 1/4" = 1'-0"

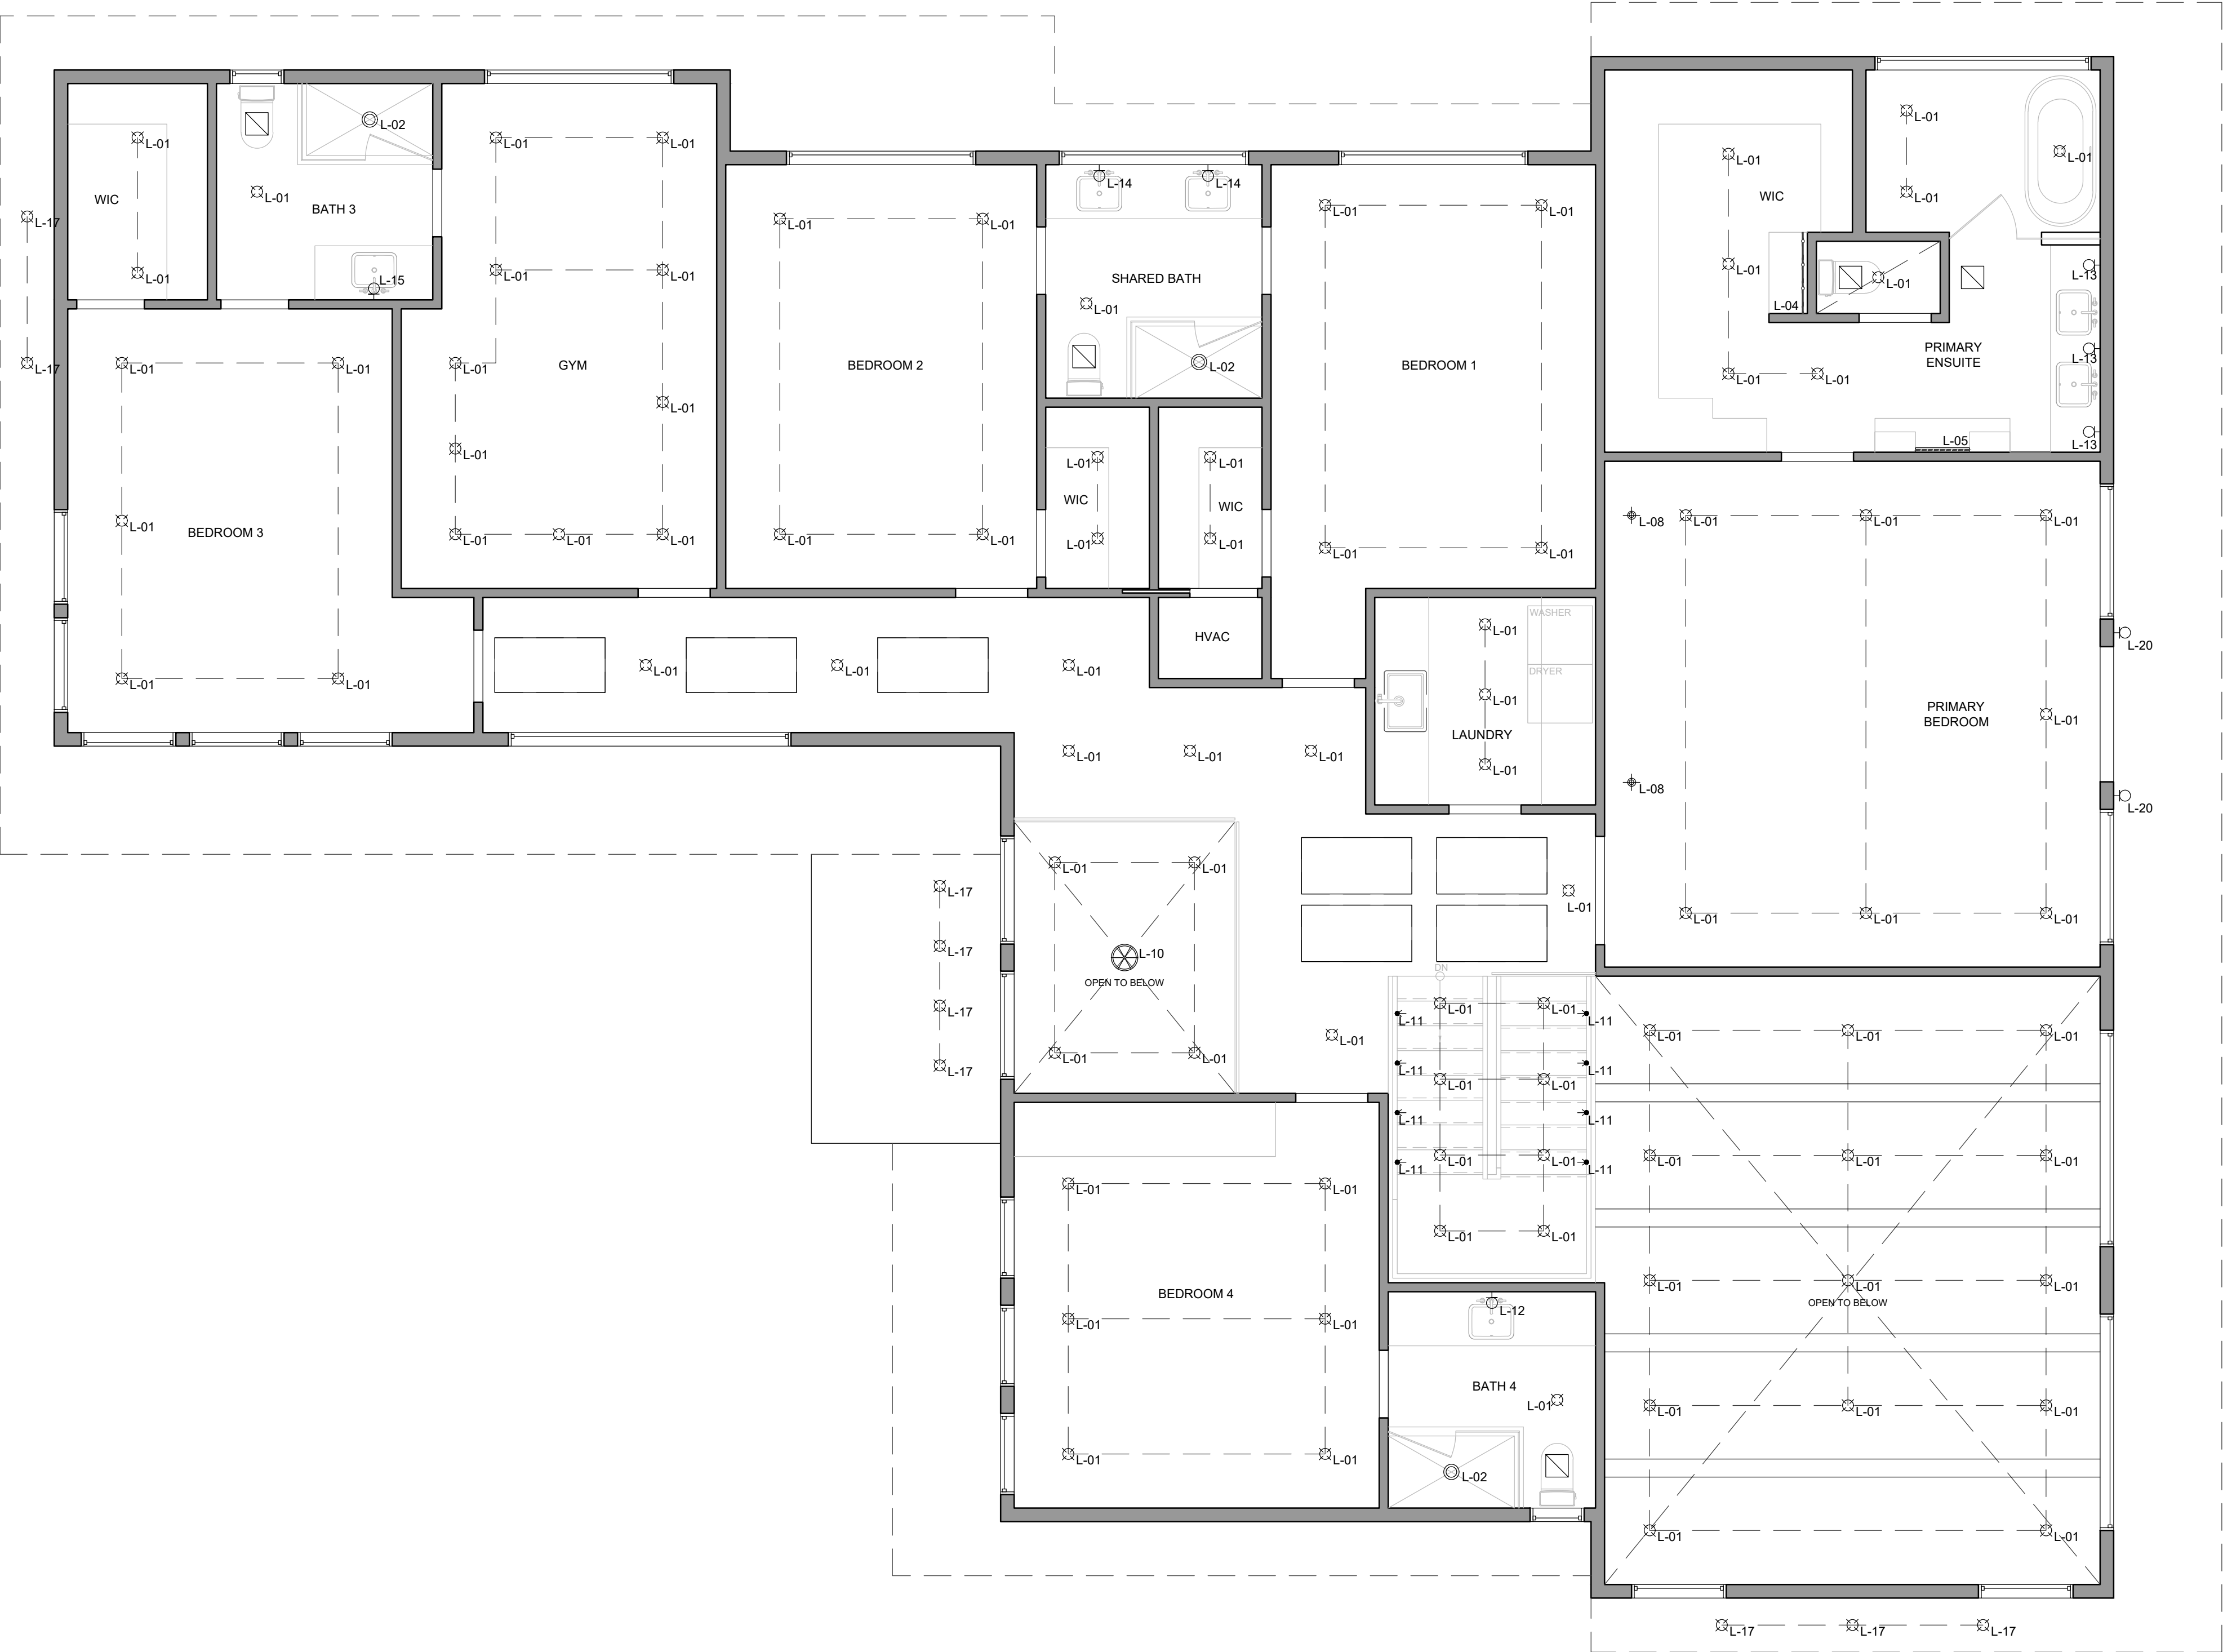

LIGHTING LEGEND	
	PENDANT FIXTURE
	LED STRIP LIGHTING
	CHANDELIER
	UPLIGHTING FLOOD FIXTURE
	RECESSED POT FIXTURE
	MILLWORK LIGHT
	IN GROUND FIXTURE
	WET LOCATION FIXTURE
	WALL SCONCE
	RECESSED STEP LIGHTING
	LED MIRROR
	EXHAUST FAN

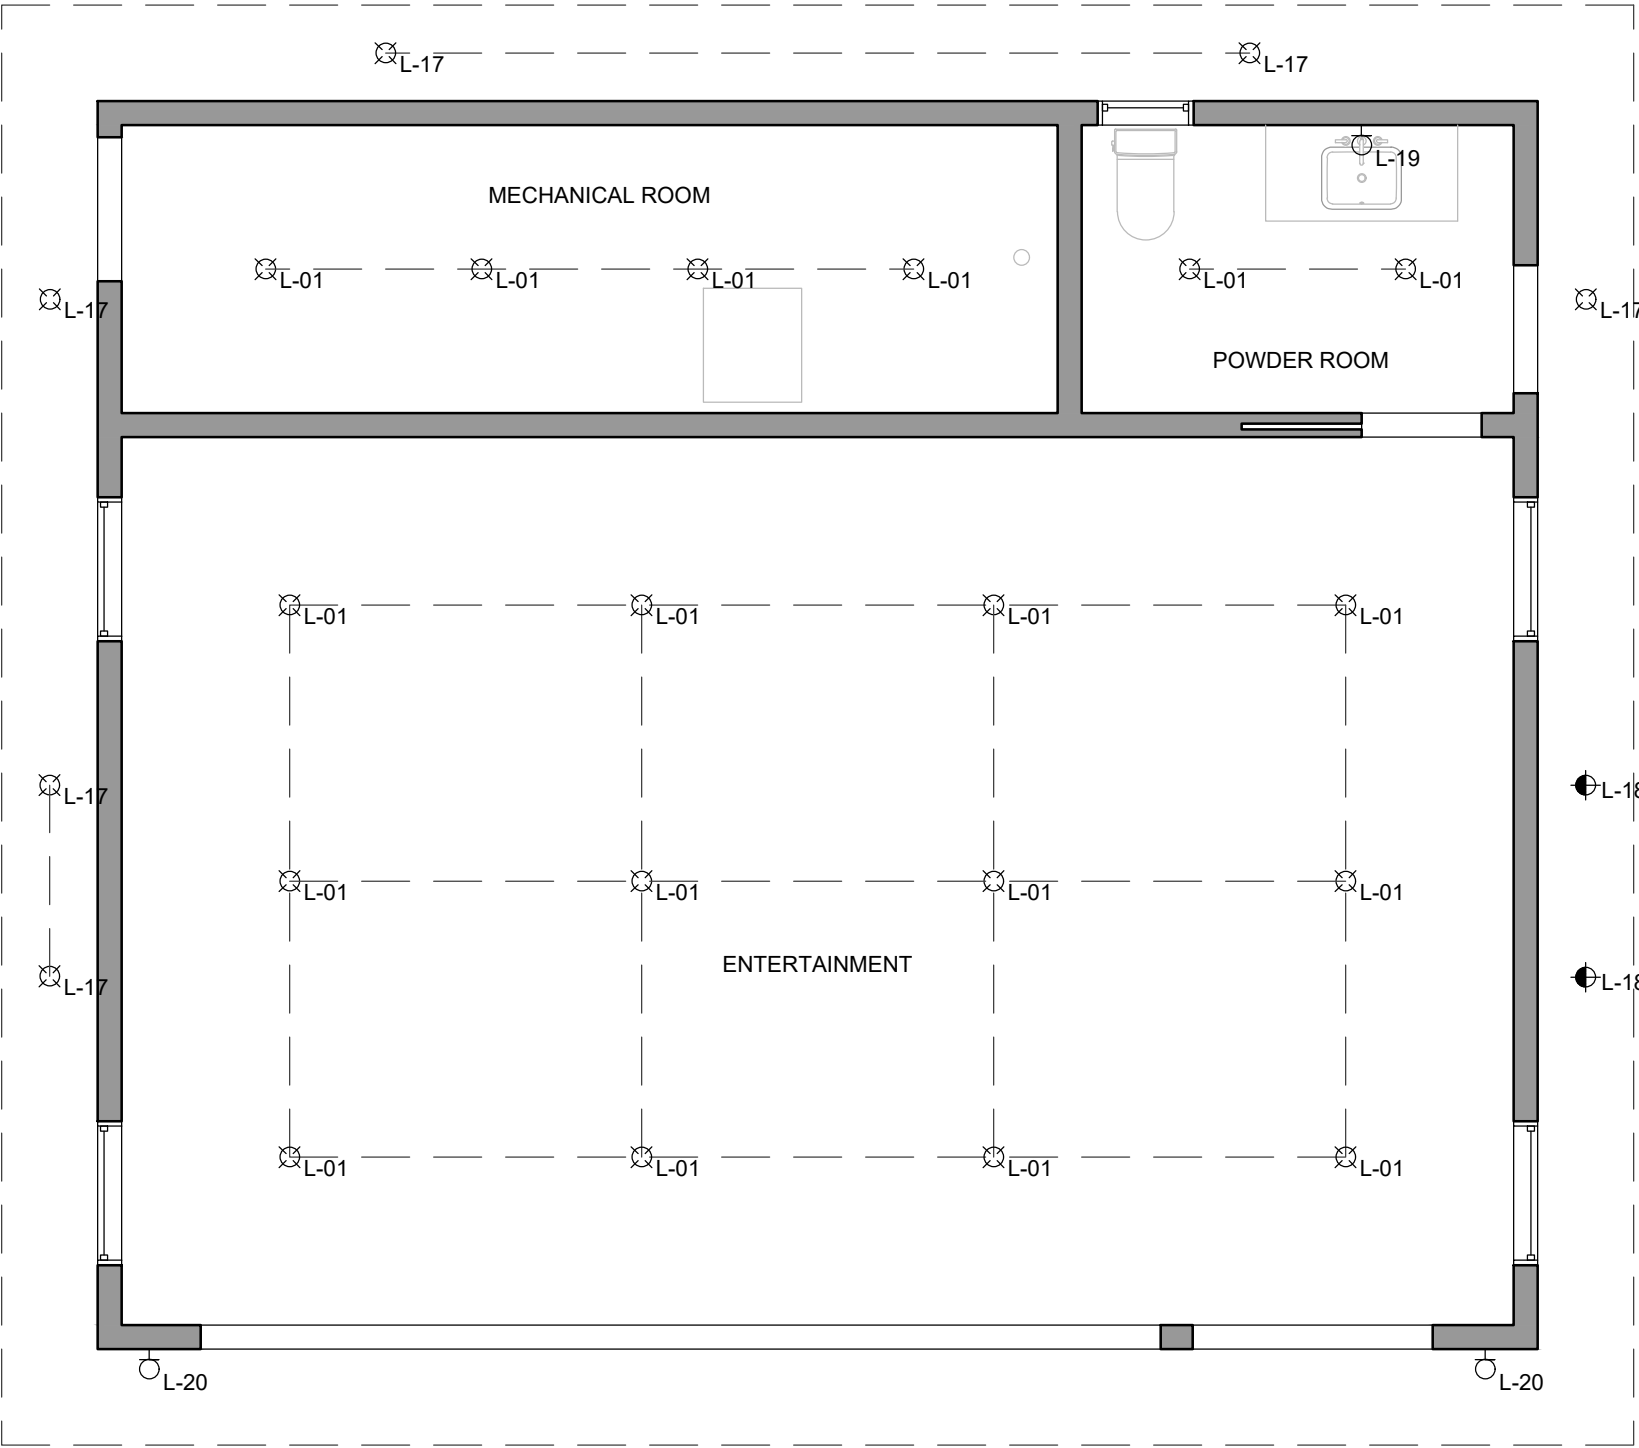

LIGHTING LEGEND

- | | |
|--|--------------------------|
| | PENDANT FIXTURE |
| | LED STRIP LIGHTING |
| | CHANDELIER |
| | UPLIGHTING FLOOD FIXTURE |
| | RECESSED POT FIXTURE |
| | MILLWORK LIGHT |
| | IN GROUND FIXTURE |
| | WET LOCATION FIXTURE |
| | WALL SCONCE |
| | RECESSED STEP LIGHTING |
| | LED MIRROR |
| | EXHAUST FAN |

ACCESSORY BUILDING - REFLECTED CEILING PLAN

SCALE: 1/4" = 1'-0"