

NEW-CONSTRUCTION DRAWING PACKAGE

ISSUED: 2022.09.22

REV 01: 2022.09.30

REVISION LIST

2022.09.30

ID 2.0 - ELEVATION D

INDEX OF DRAWINGS


ID 0.0	COVER SHEET & GENERAL NOTES
ID 1.0.0	CONSTRUCTION PLAN - LEVEL 1
ID 1.0.1	REFLECTED CEILING PLAN - LEVEL 1
ID 1.0.2	FINISHES PLAN - LEVEL 1
ID 1.0.3	ELECTRICAL PLAN - LEVEL 1
ID 1.1.0	CONSTRUCTION PLAN - LEVELS 2-5
ID 1.1.1	REFLECTED CEILING PLAN - LEVELS 2-5
ID 1.1.2	FINISHES PLAN - LEVELS 2-5
ID 1.1.3	ELECTRICAL PLAN - LEVELS 2-5
ID 1.2.0	CONSTRUCTION PLAN - LEVEL 6
ID 1.2.1	REFLECTED CEILING PLAN - LEVEL 6
ID 1.2.2	FINISHES PLAN - LEVEL 6
ID 1.2.3	ELECTRICAL PLAN - LEVEL 6
ID 2.0	ELEVATIONS: COMMON AREAS - LOBBY, STAIRWELL ENTRY & SUITE ENTRY
ID 2.1	ELEVATIONS: LEVELS 2-5 SUITES - UNITS 2-501 & 2-502
ID 2.2	ELEVATIONS: LEVELS 2-5 SUITES - UNITS 2-503 & 2-504
ID 2.3	ELEVATIONS: LEVELS 2-5 SUITES - UNITS 2-504 & 2-505
ID 2.4	ELEVATIONS: LEVELS 2-5 SUITES - UNITS 2-505 & 2-506
ID 2.5	ELEVATIONS: LEVELS 2-5 SUITES - UNITS 2-506 & 2-507
ID 2.6	ELEVATIONS: LEVEL 6 SUITES - UNITS 601 & 602
ID 2.7	ELEVATIONS: LEVEL 6 SUITES - UNITS 602 & 603
ID 2.8	ELEVATIONS: LEVEL 6 SUITES - UNIT 604
ID 3.0	MILLWORK SECTIONS

SCHEME 01

TIMELESS MODERN


COMMON AREA

TIMELESS MODERN

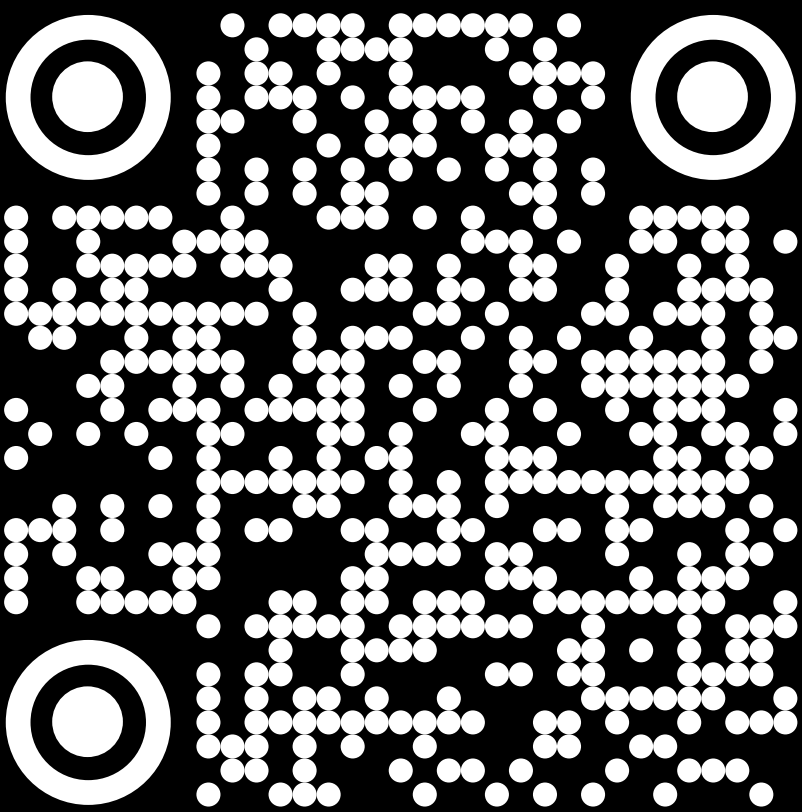


GENERAL PROJECT PAGE


<https://focusedinteriors.com/site/project-page-22-09-04/>

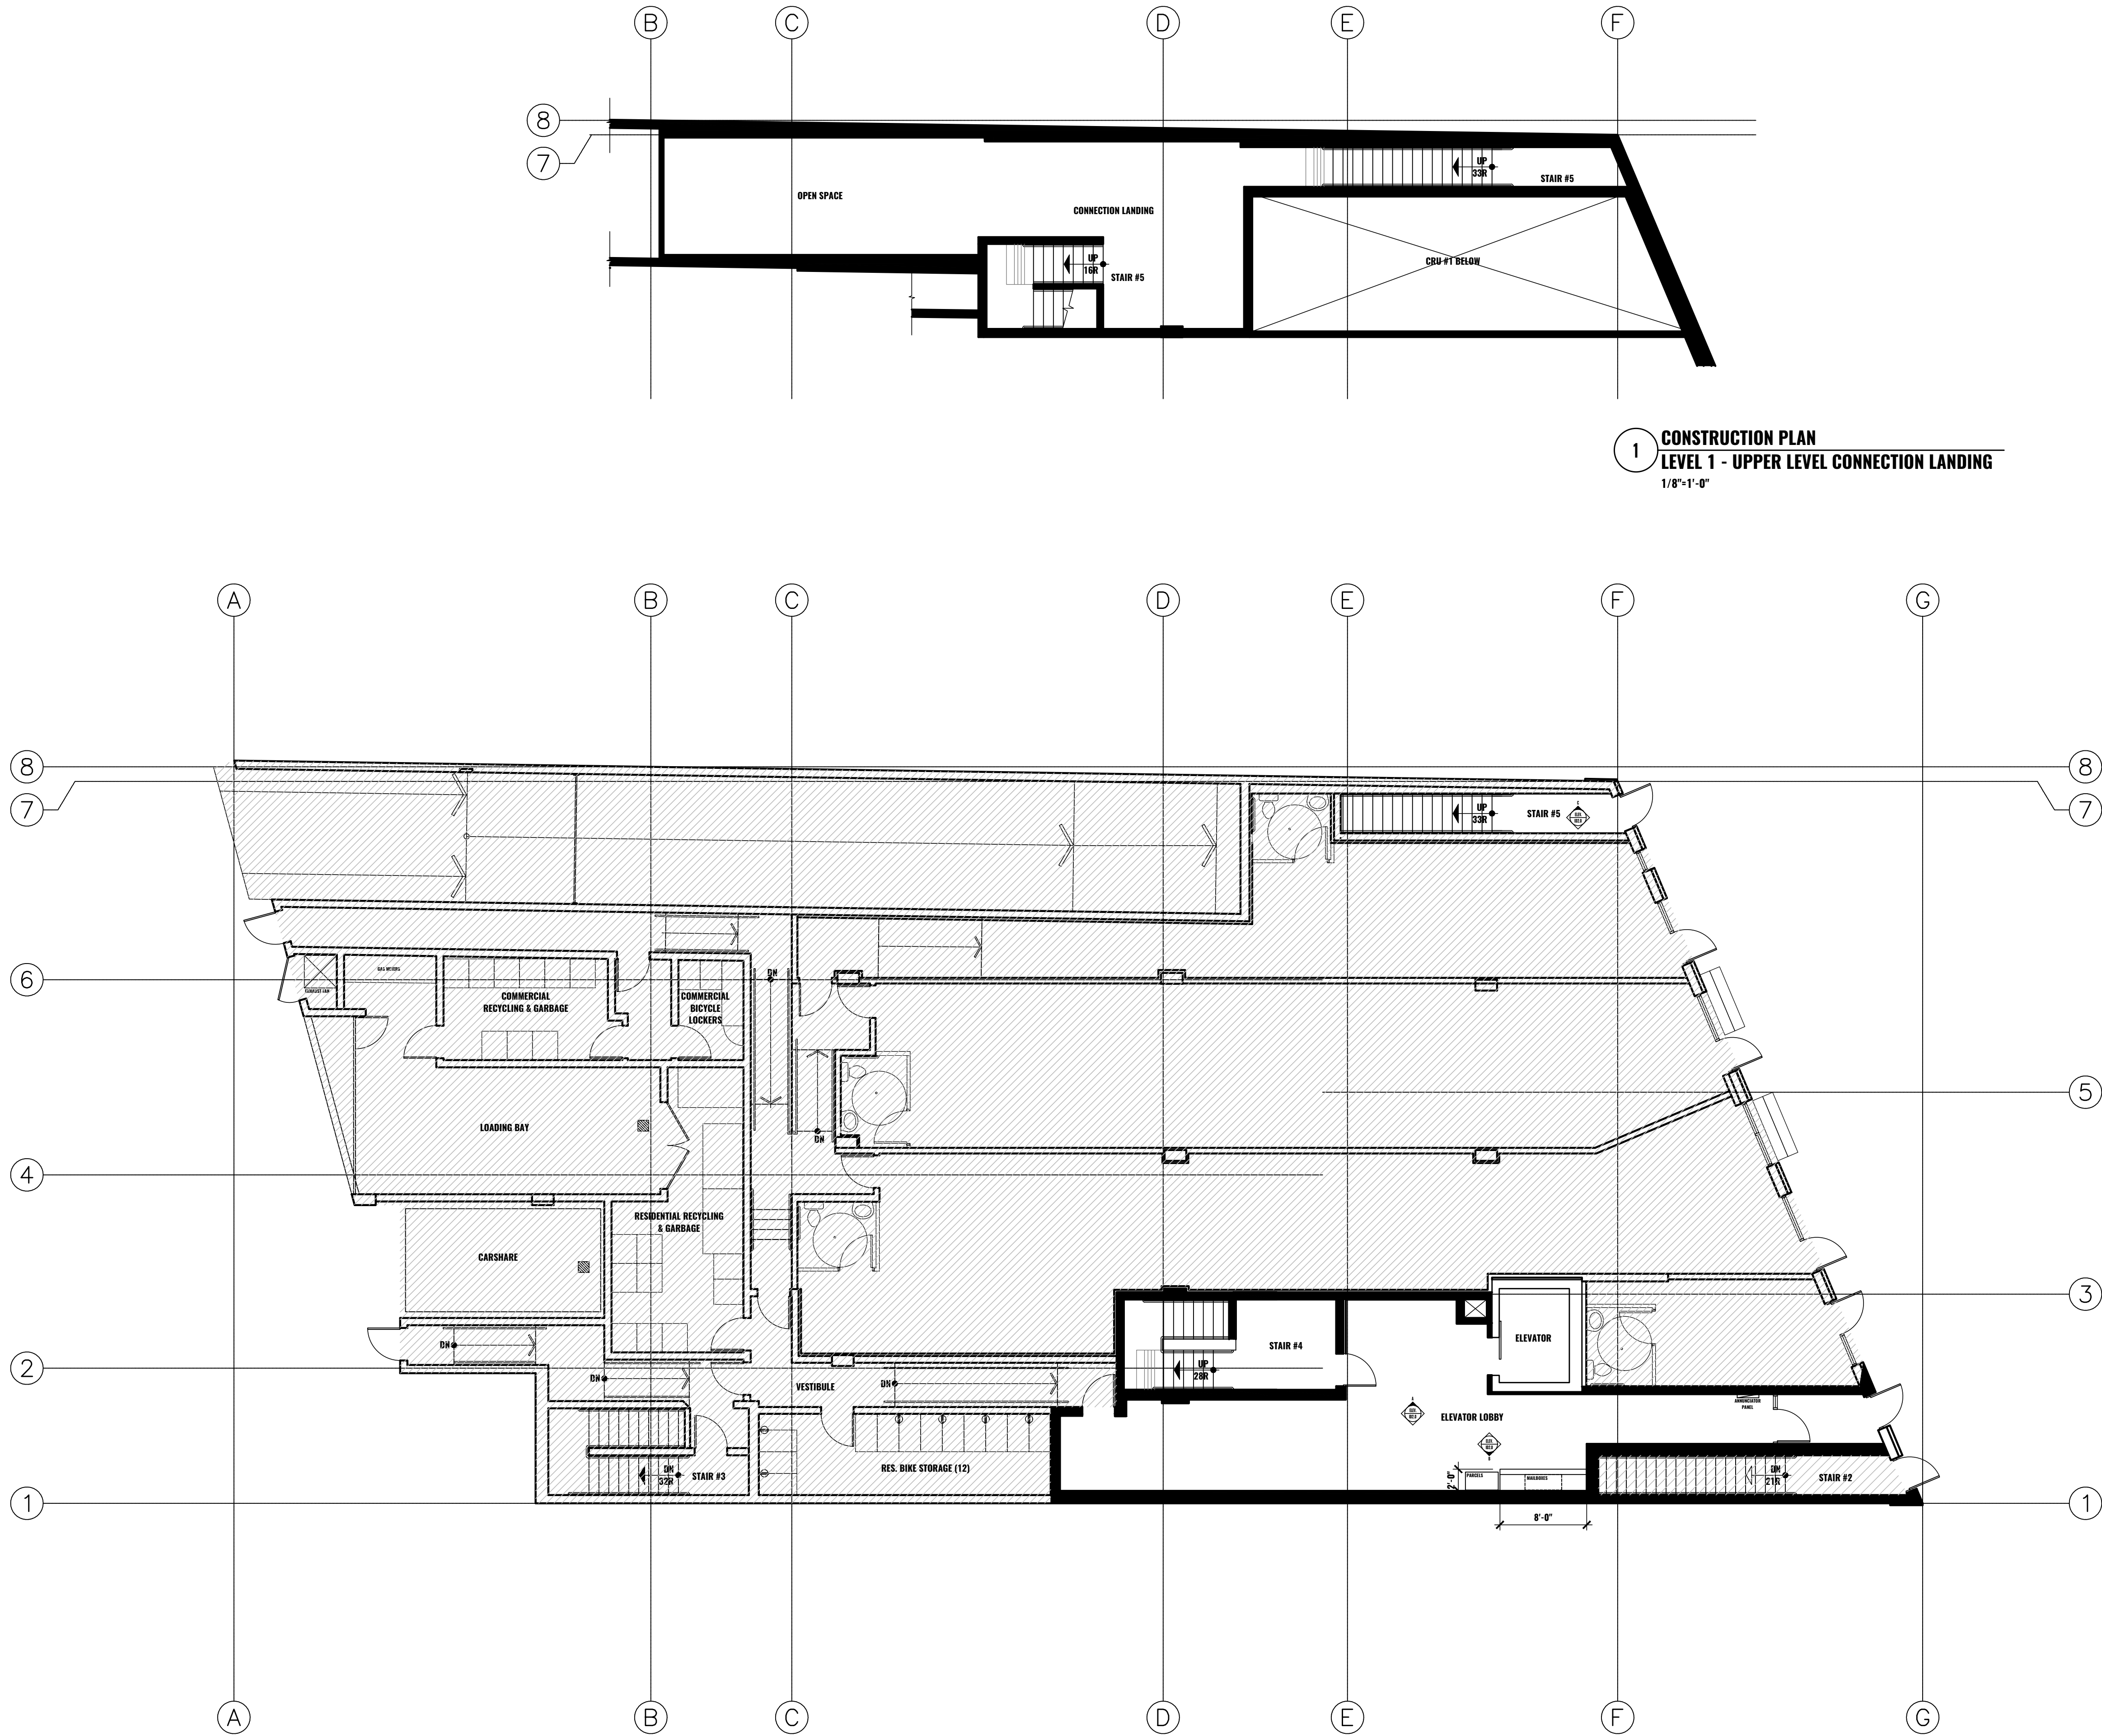

1 CONSTRUCTION PLAN
LEVEL 1 - UPPER LEVEL CONNECTION LANDING
1/8"=1'-0"

1 CONSTRUCTION PLAN
LEVEL 1
1/8"=1'-0"

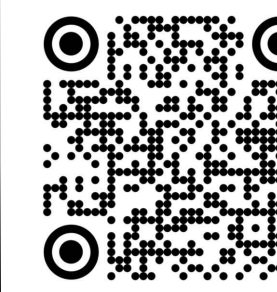


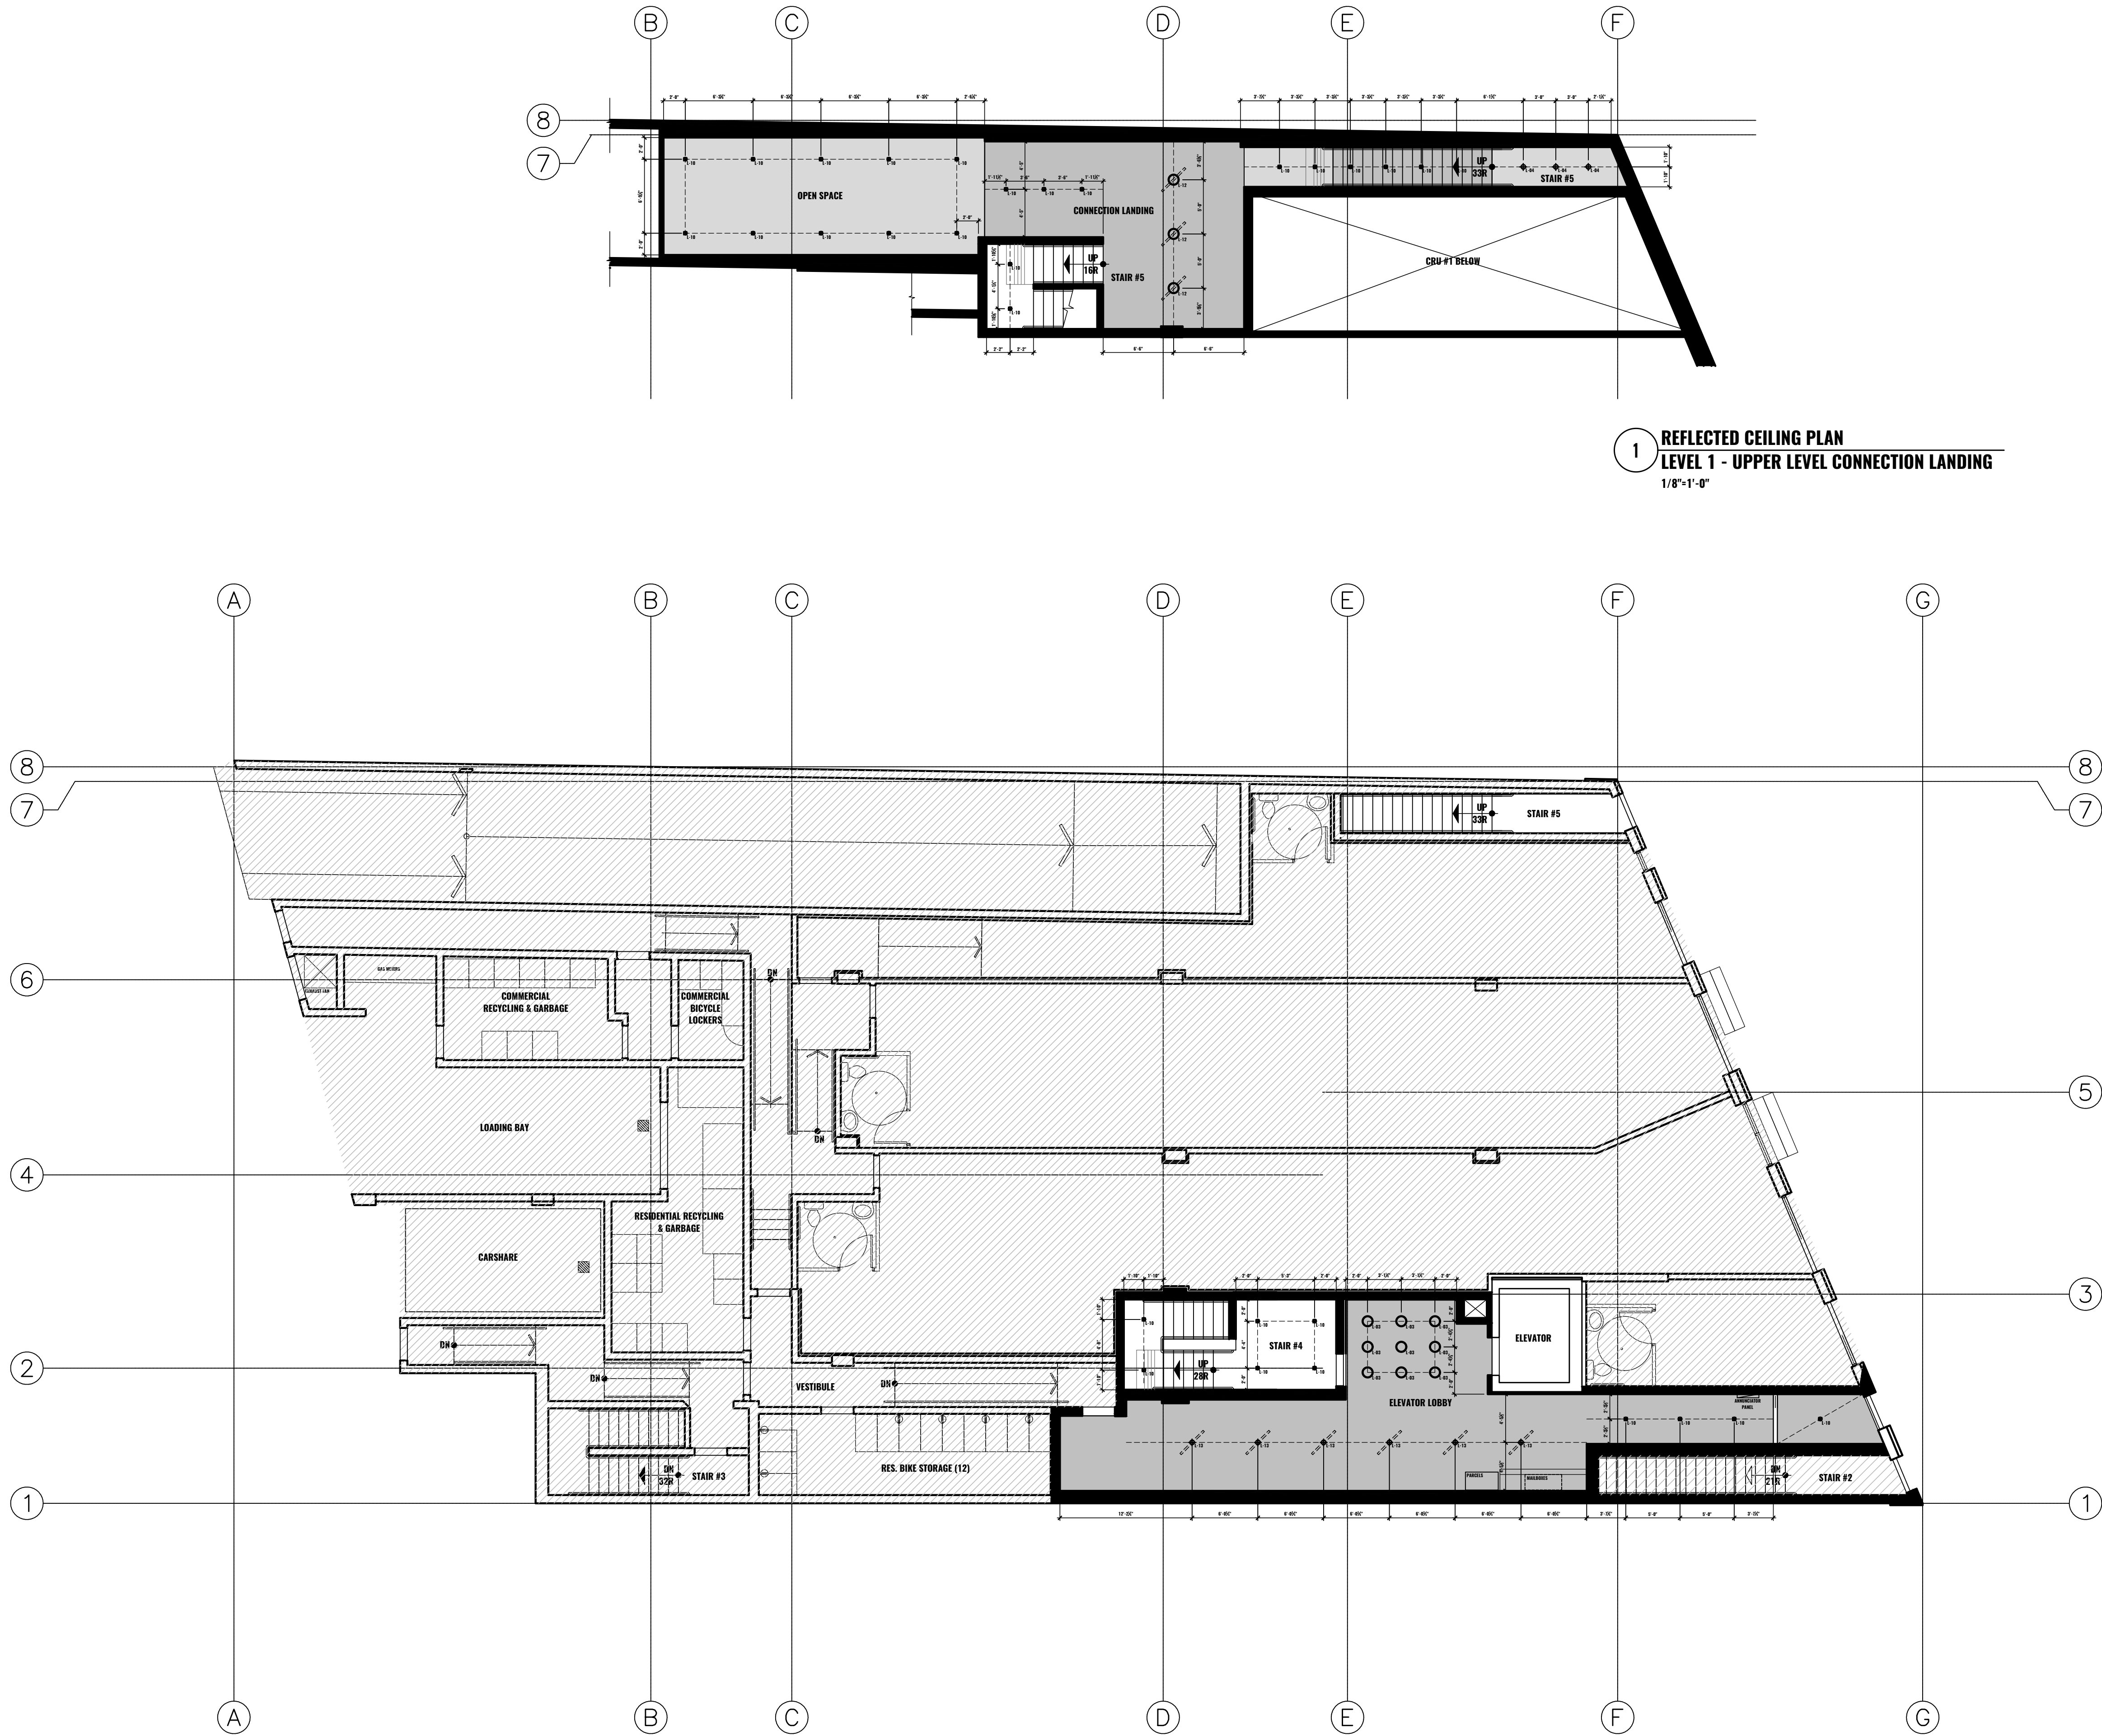


LIGHTING LEGEND	
	RECESSED POT LIGHT
	RECESSED CABINET LIGHT
	RECESSED LINEAR LIGHT
	WALL SCONCE
	CEILING LIGHT
	COVE LIGHT

1 REFLECTED CEILING PLAN
LEVEL 1 - UPPER LEVEL CONNECTION LANDING
1/8"=1'-0"


1 REFLECTED CEILING PLAN
LEVEL 1
1/8"=1'-0"

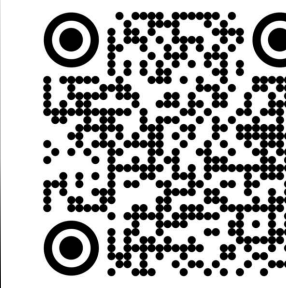


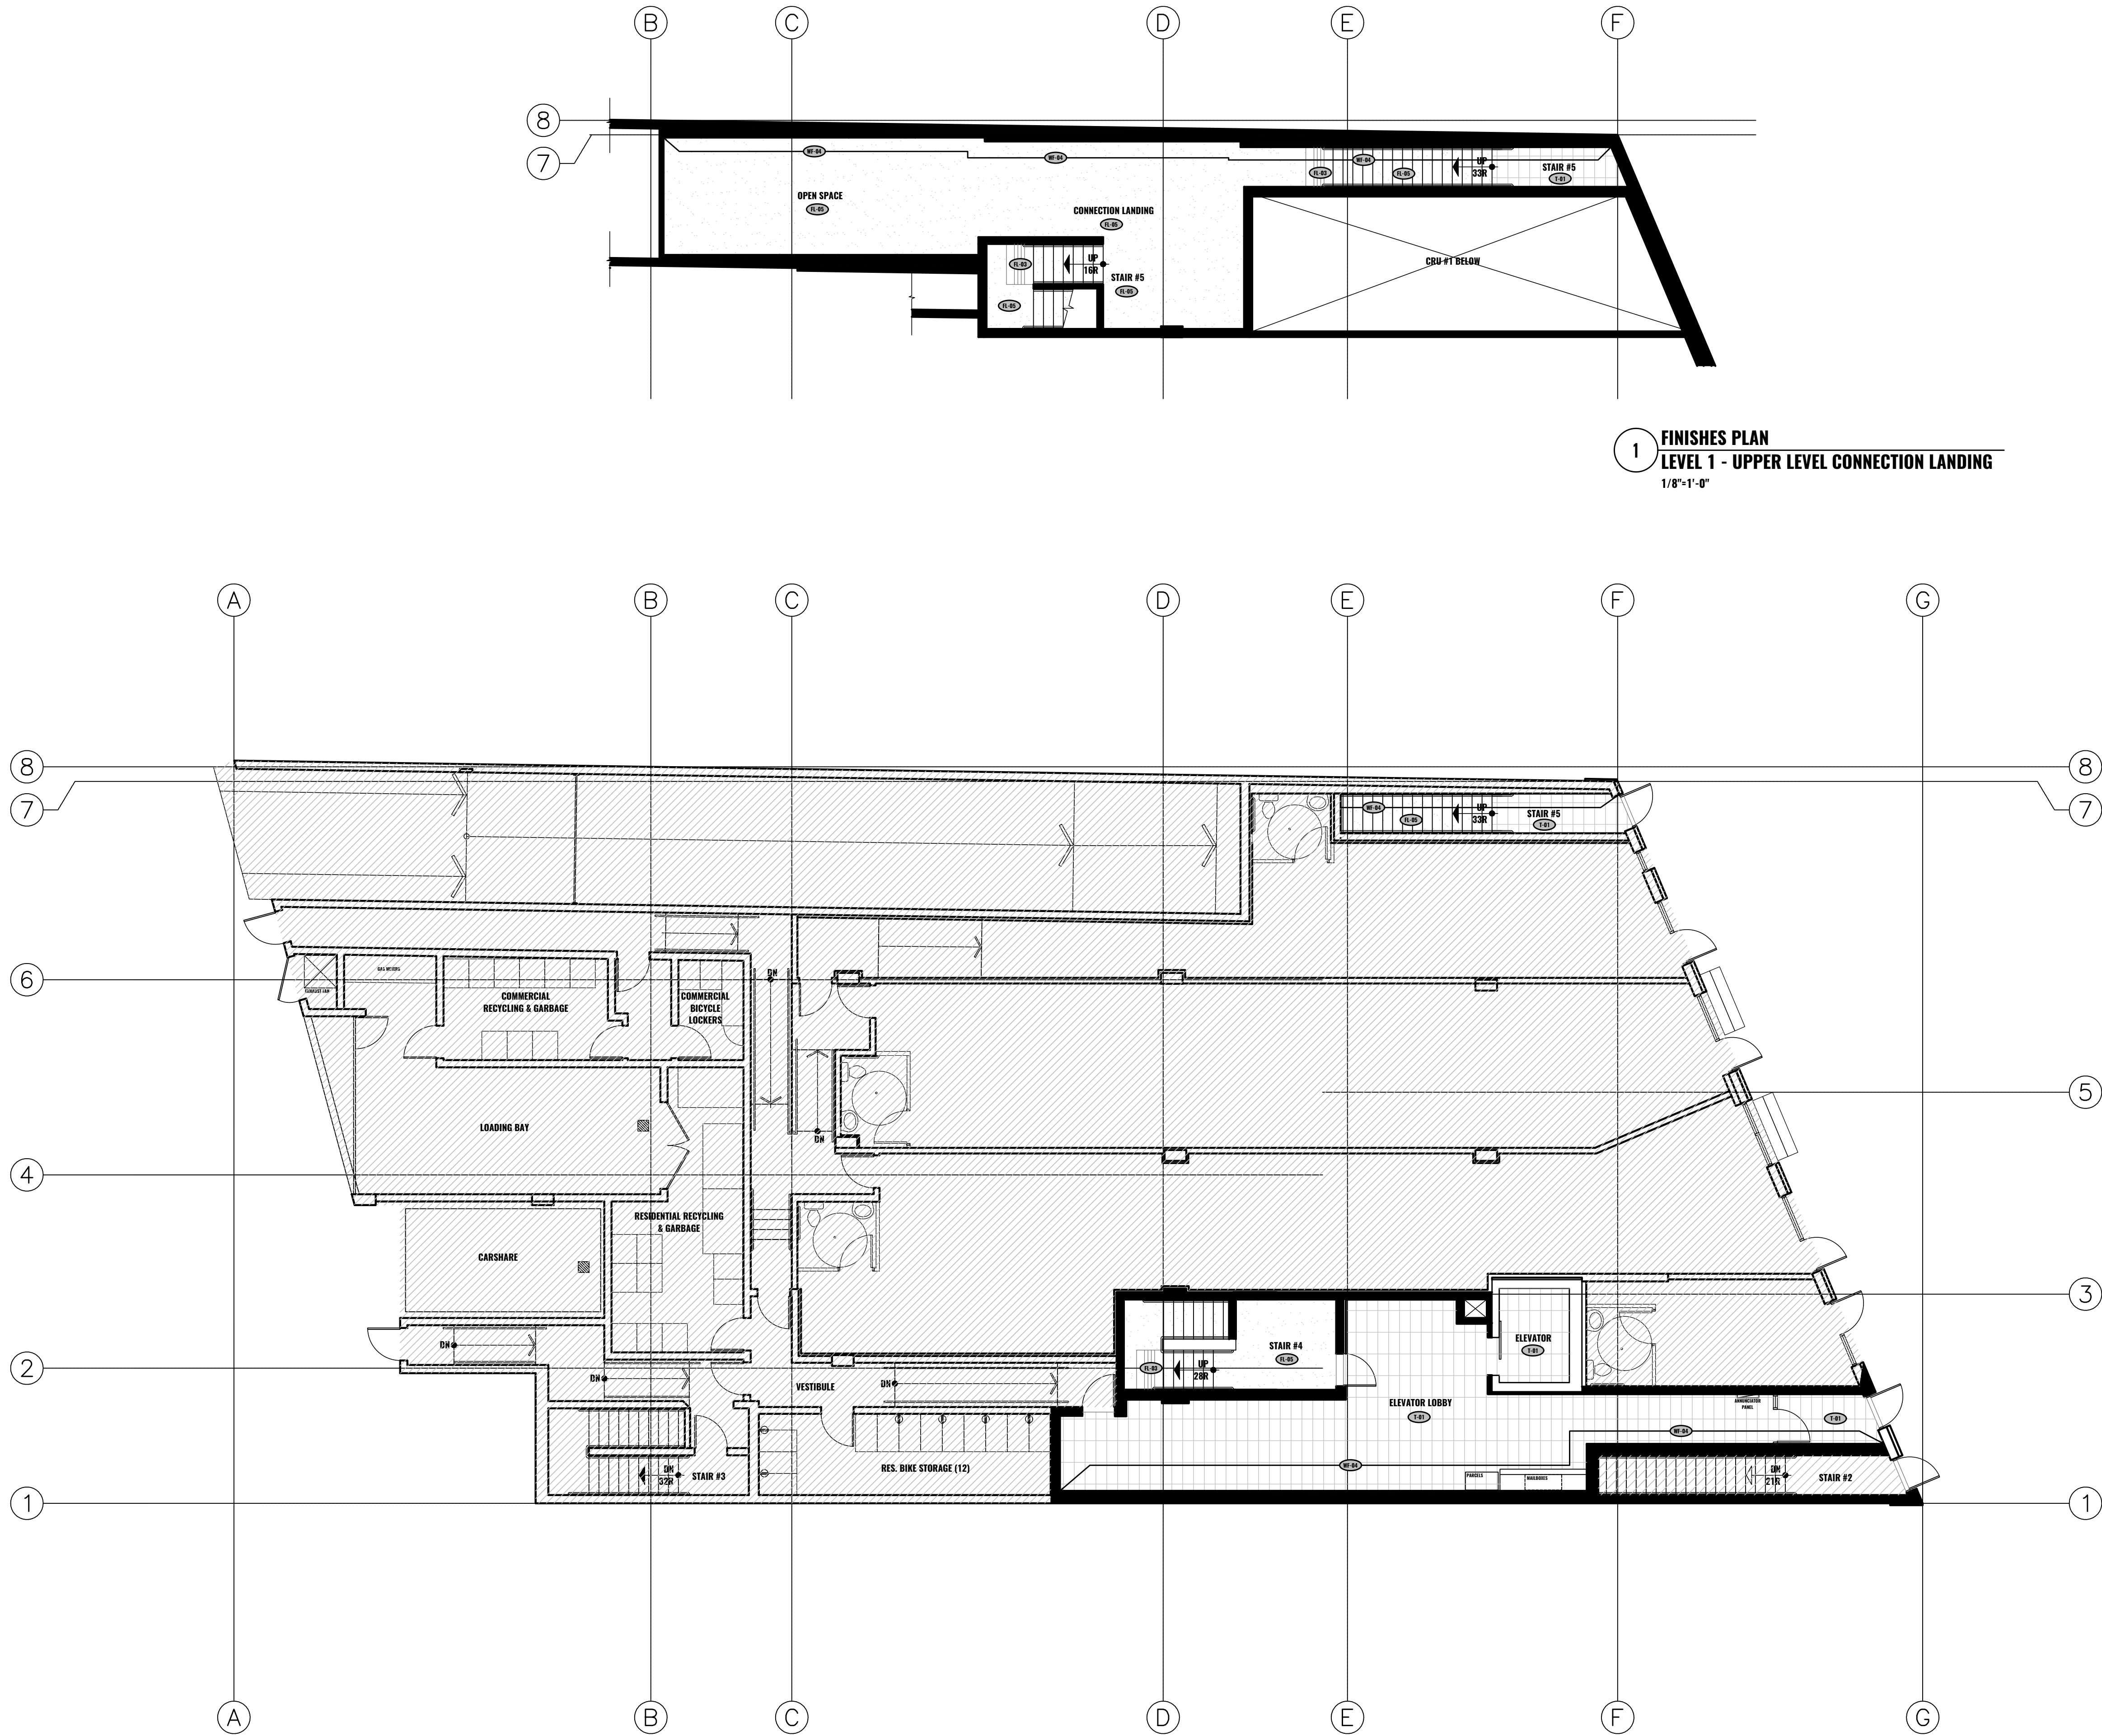

1 FINISHES PLAN
LEVEL 1 - UPPER LEVEL CONNECTION LANDING
1/8"=1'-0"

1 FINISHES PLAN
LEVEL 1
1/8"=1'-0"

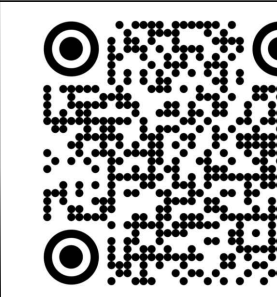

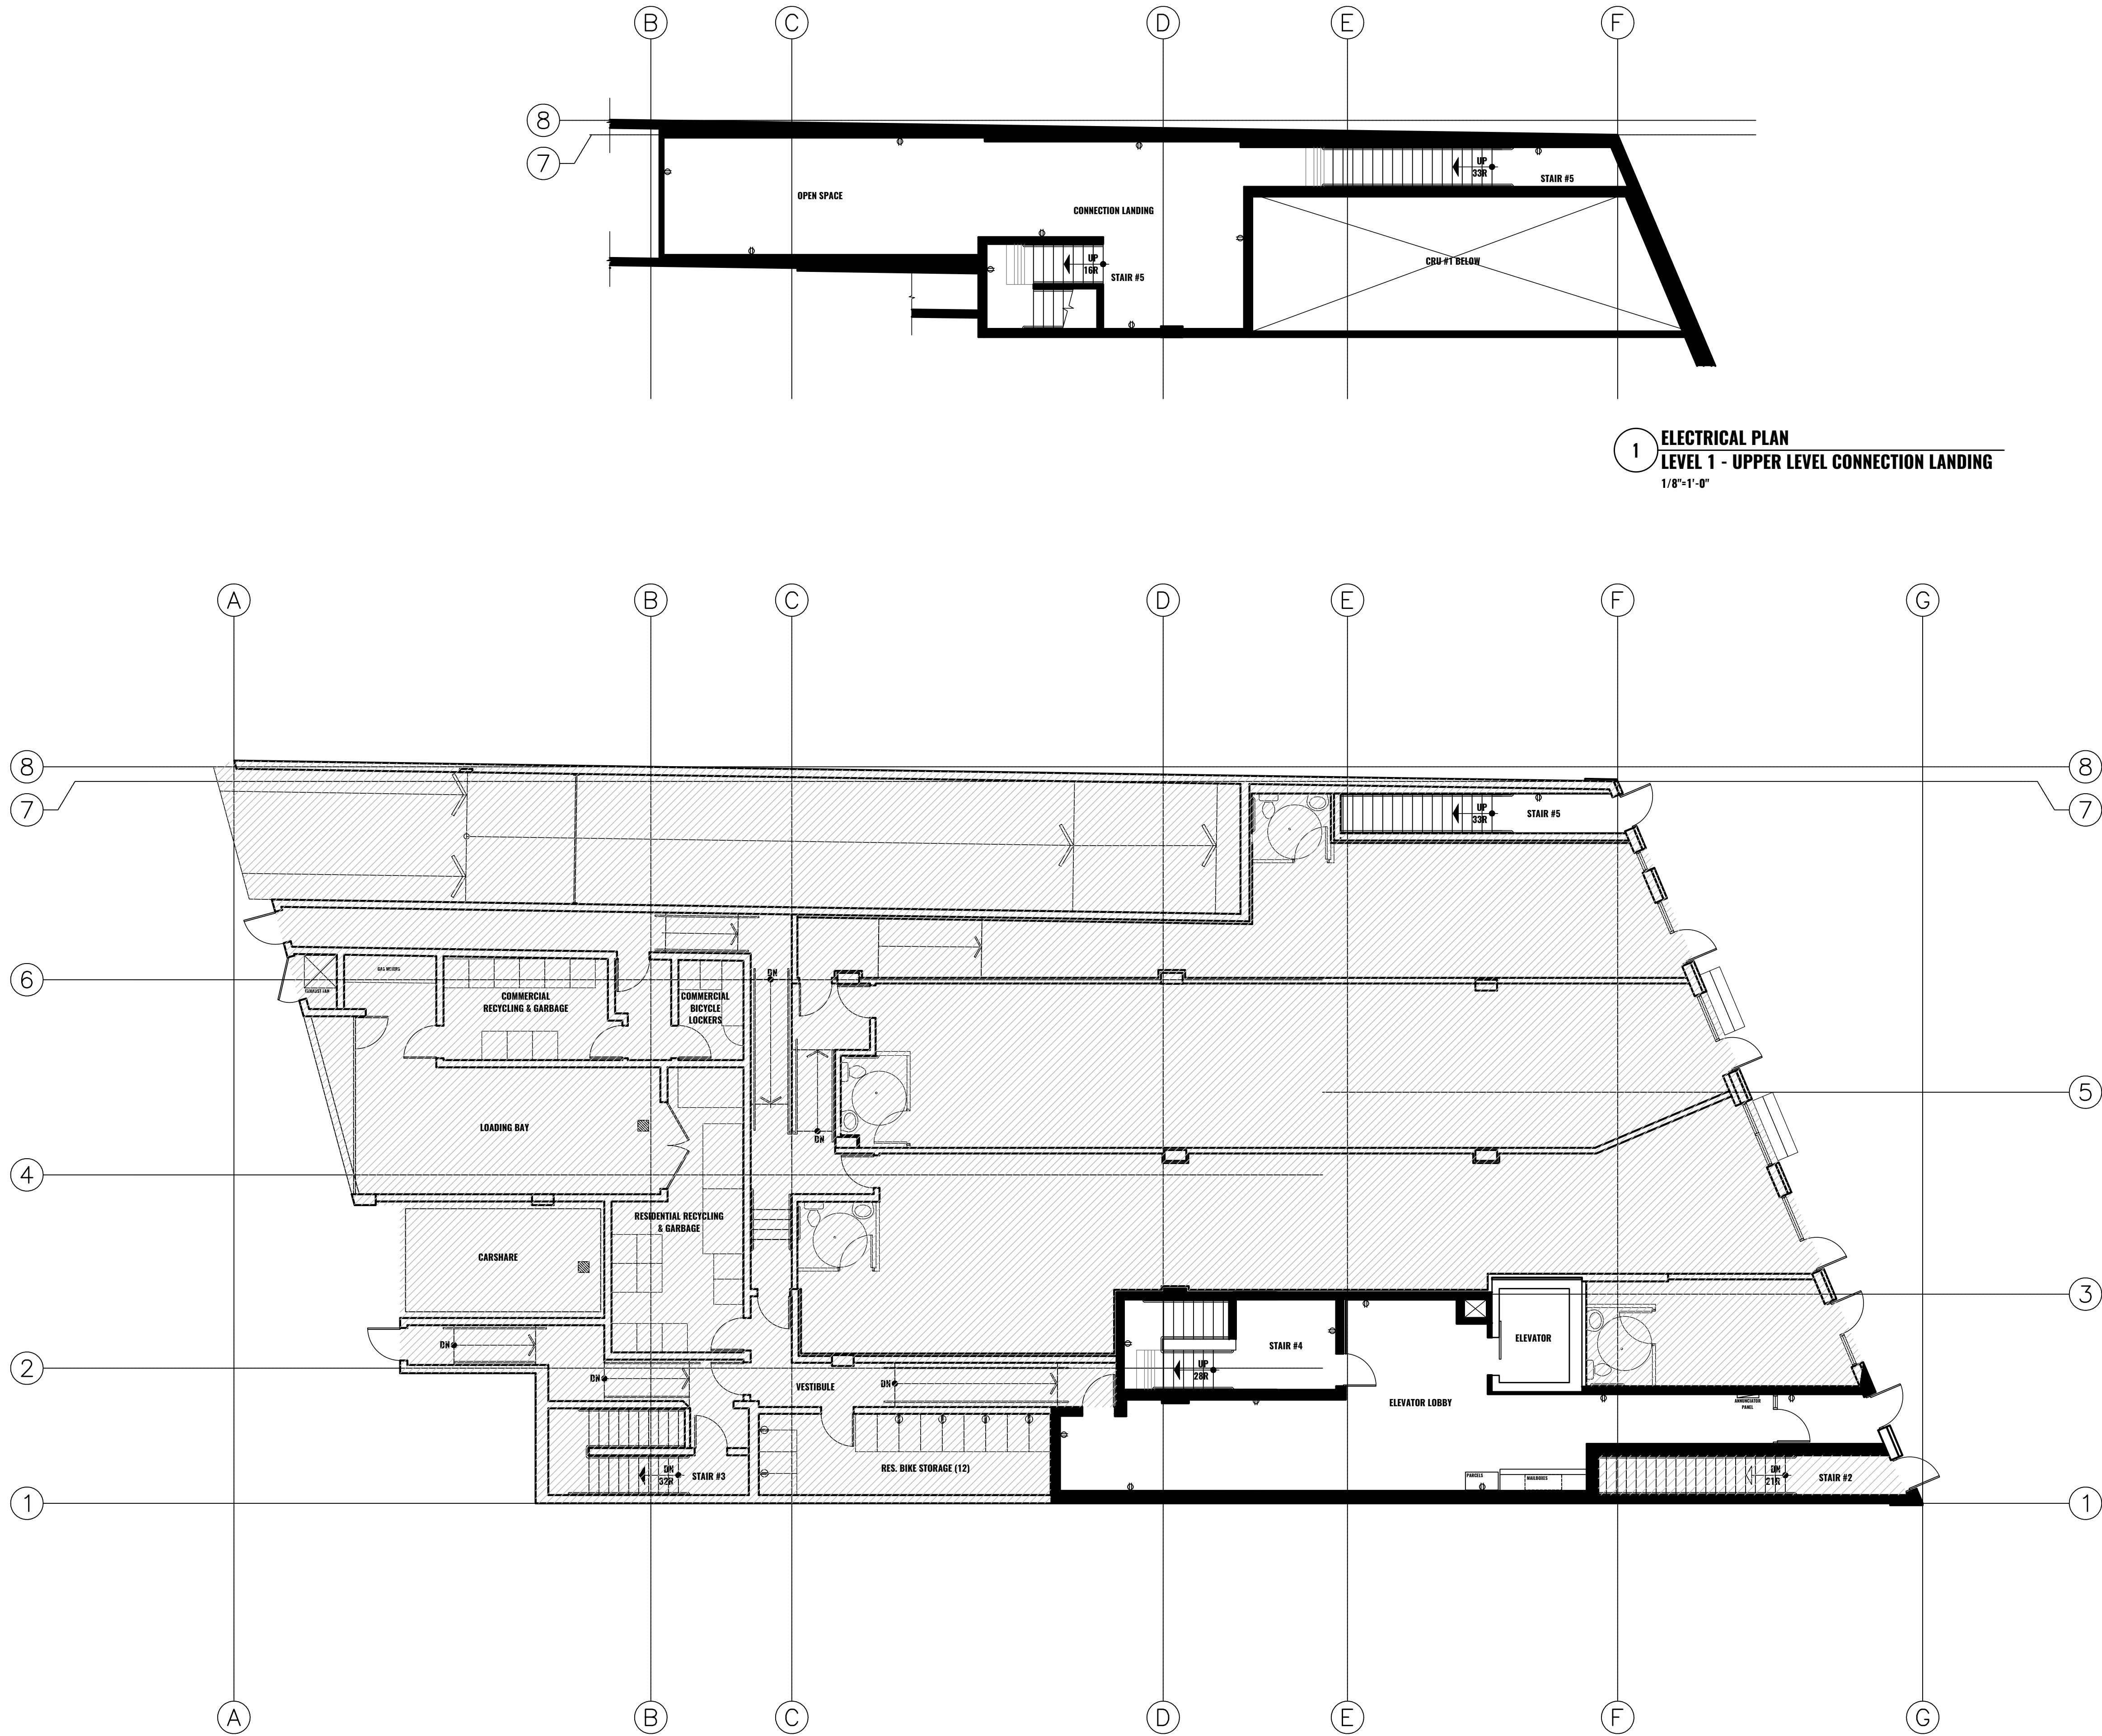



ELECTRICAL LEGEND

- CABLE OUTLET
- INTERNET OUTLET
- DUPLEX OR RECEPTACLE
- DUPLEX RECEPTACLE
- DEDICATED 200V RECEPTACLE


1 ELECTRICAL PLAN
LEVEL 1 - UPPER LEVEL CONNECTION LANDING
1/8"=1'-0"

1 ELECTRICAL PLAN
LEVEL 1
1/8"=1'-0"

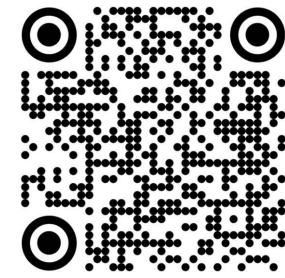

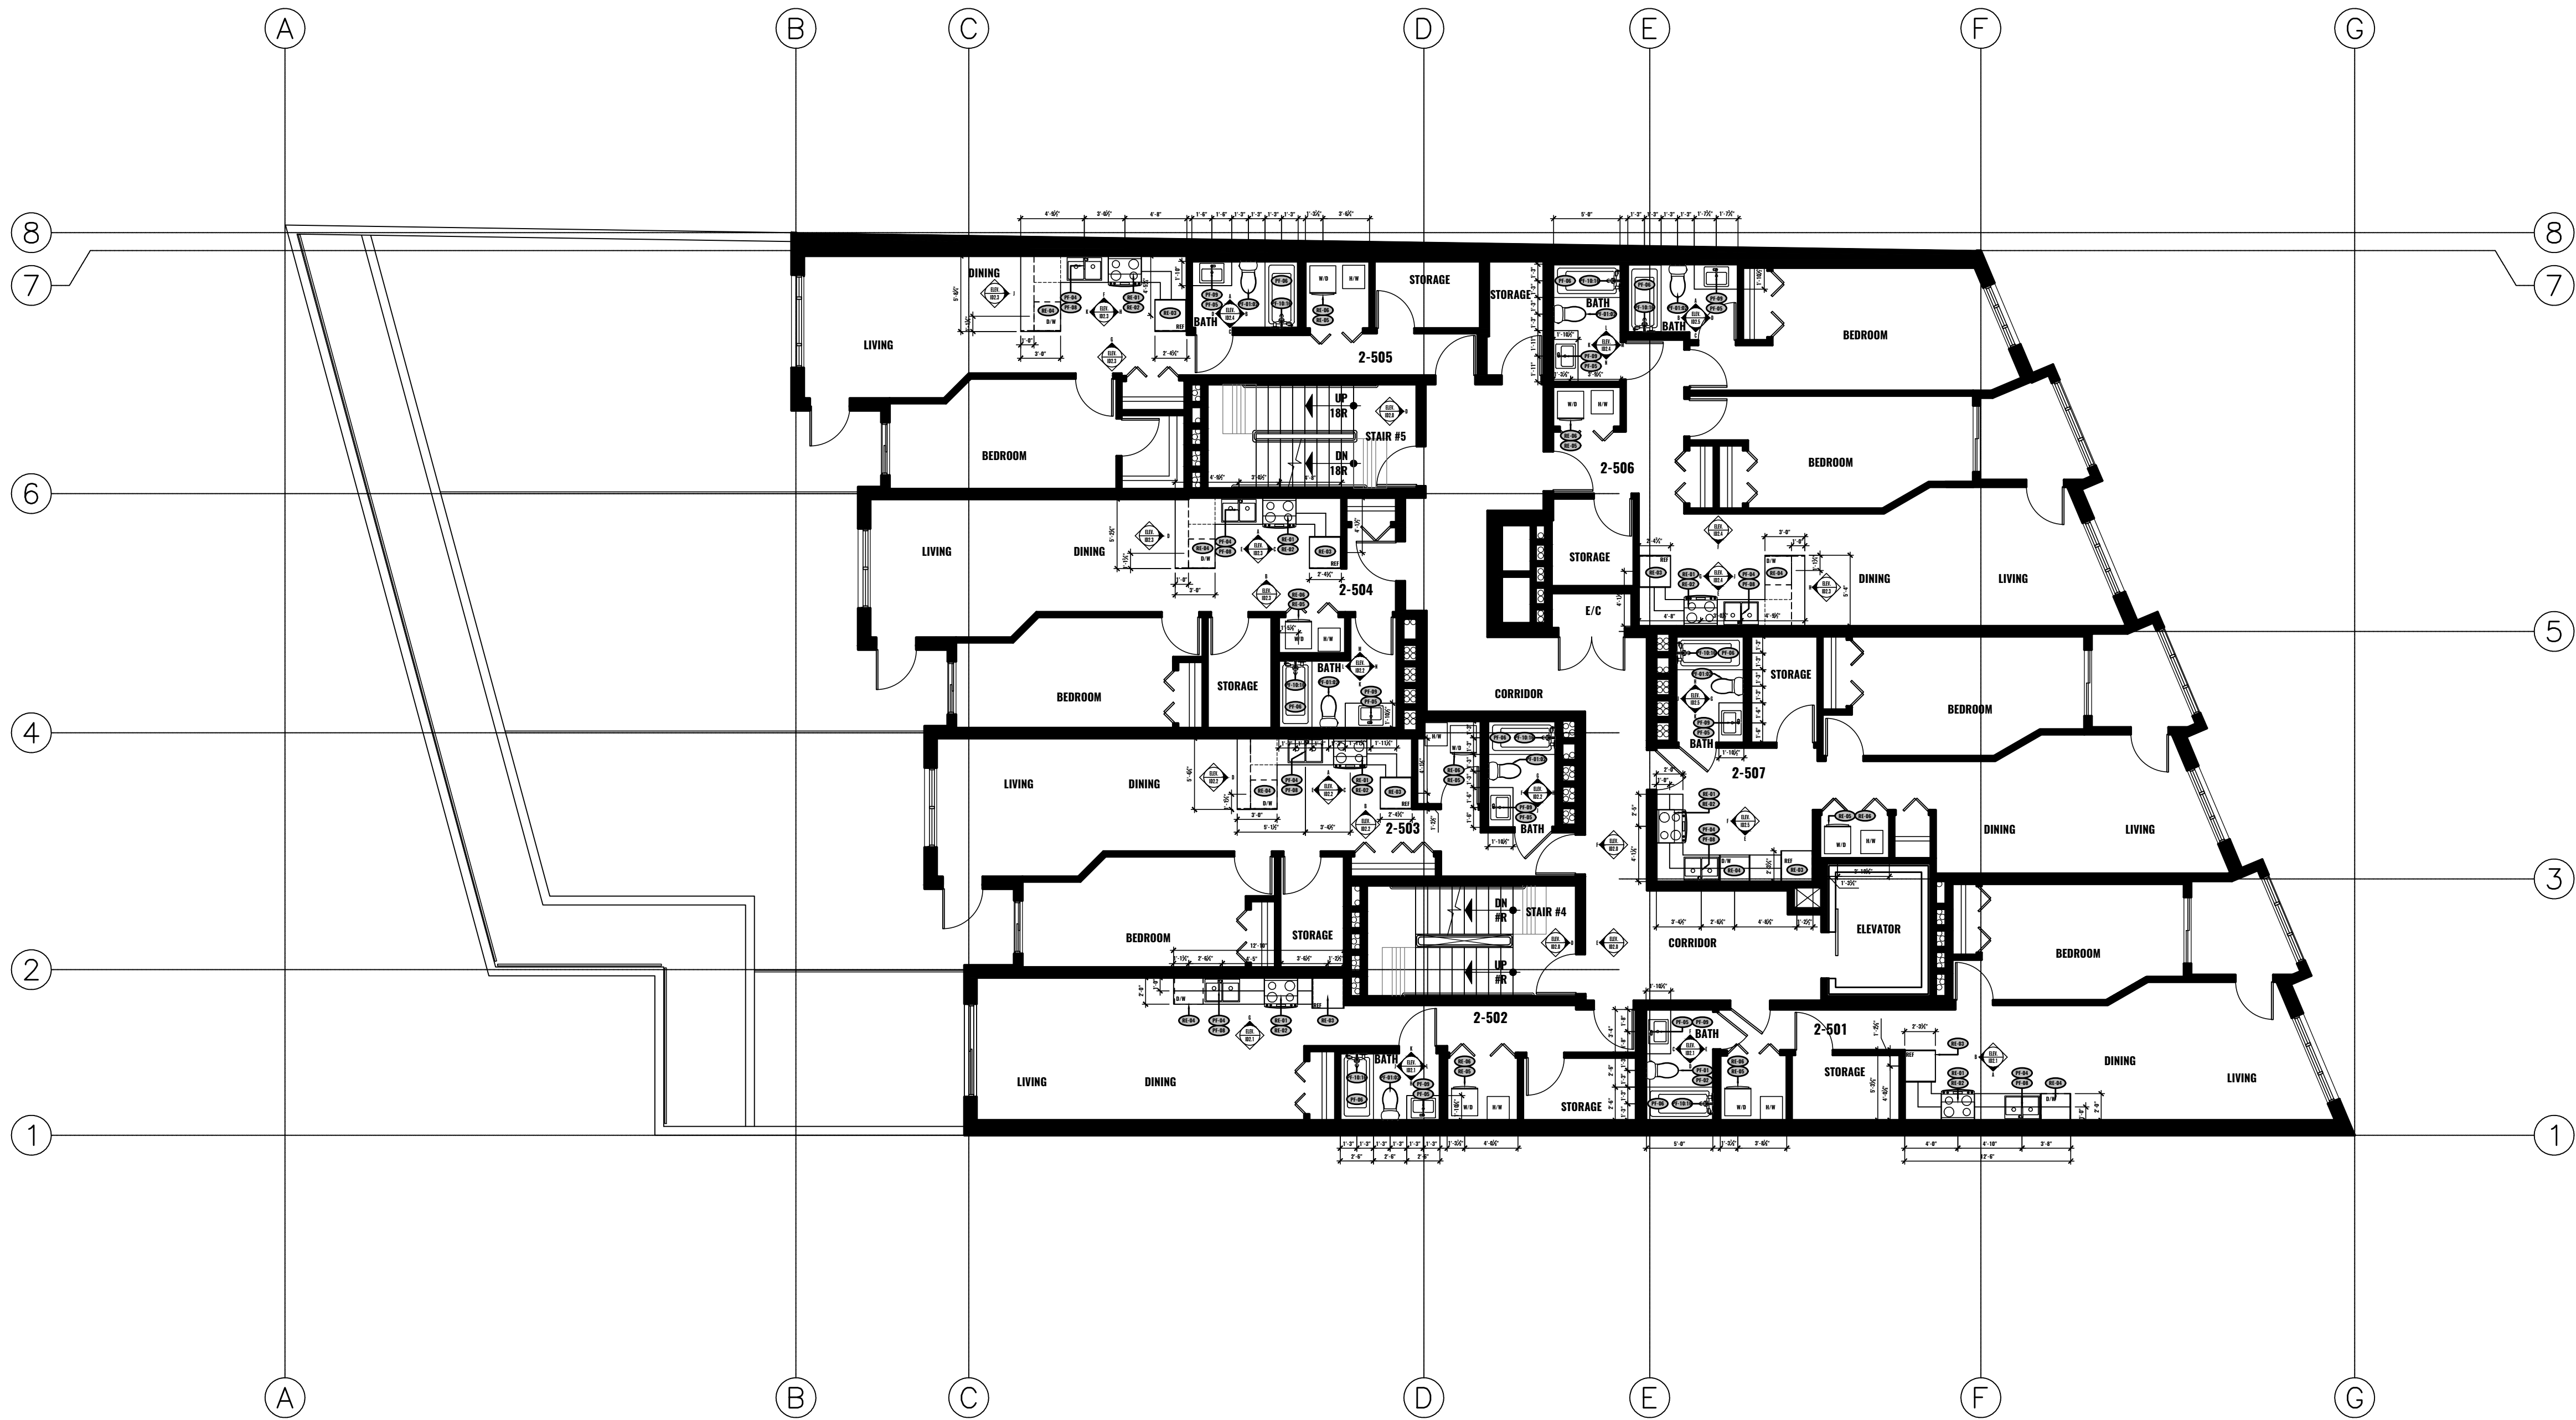

2 CONSTRUCTION PLAN
LEVELS 2-5
1/8"=1'-0"

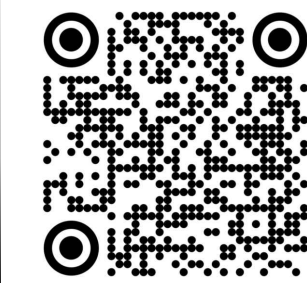

DRAWN BY
KLO/CC
DESCRIPTION
CONSTRUCTION PLAN

PROJECT NO.
P-22-09-04
PROJECT
[KINGSWAY]

ISSUE
2022.09.30
RE-ISSUE

CLIENT
LIONESTATE CONSTRUCTION

» FOCUSED INTERIORS
interior design + rendering studio
778.242.2778 | SALES@FOCUSEDINTERIORS.COM
WWW.FOCUSEDINTERIORS.COM | METRO VANCOUVER, BC, CANADA

ID1.1.0



2 REFLECTED CEILING PLAN
LEVELS 2-5
1/8"=1'-0"

» FOCUSED INTERIORS
interior design + rendering studio
778.242.2778 | SALES@FOCUSEDINTERIORS.COM
WWW.FOCUSEDINTERIORS.COM | METRO VANCOUVER, BC, CANADA


CLIENT
LIONESTATE CONSTRUCTION

ISSUE
2022.09.30
RE-ISSUE


PROJECT NO.
P-22-09-04
PROJECT
[KINGSWAY]

DRAWN BY
KLO/CC
DESCRIPTION
REFLECTED CEILING PLAN

ID1.1.1

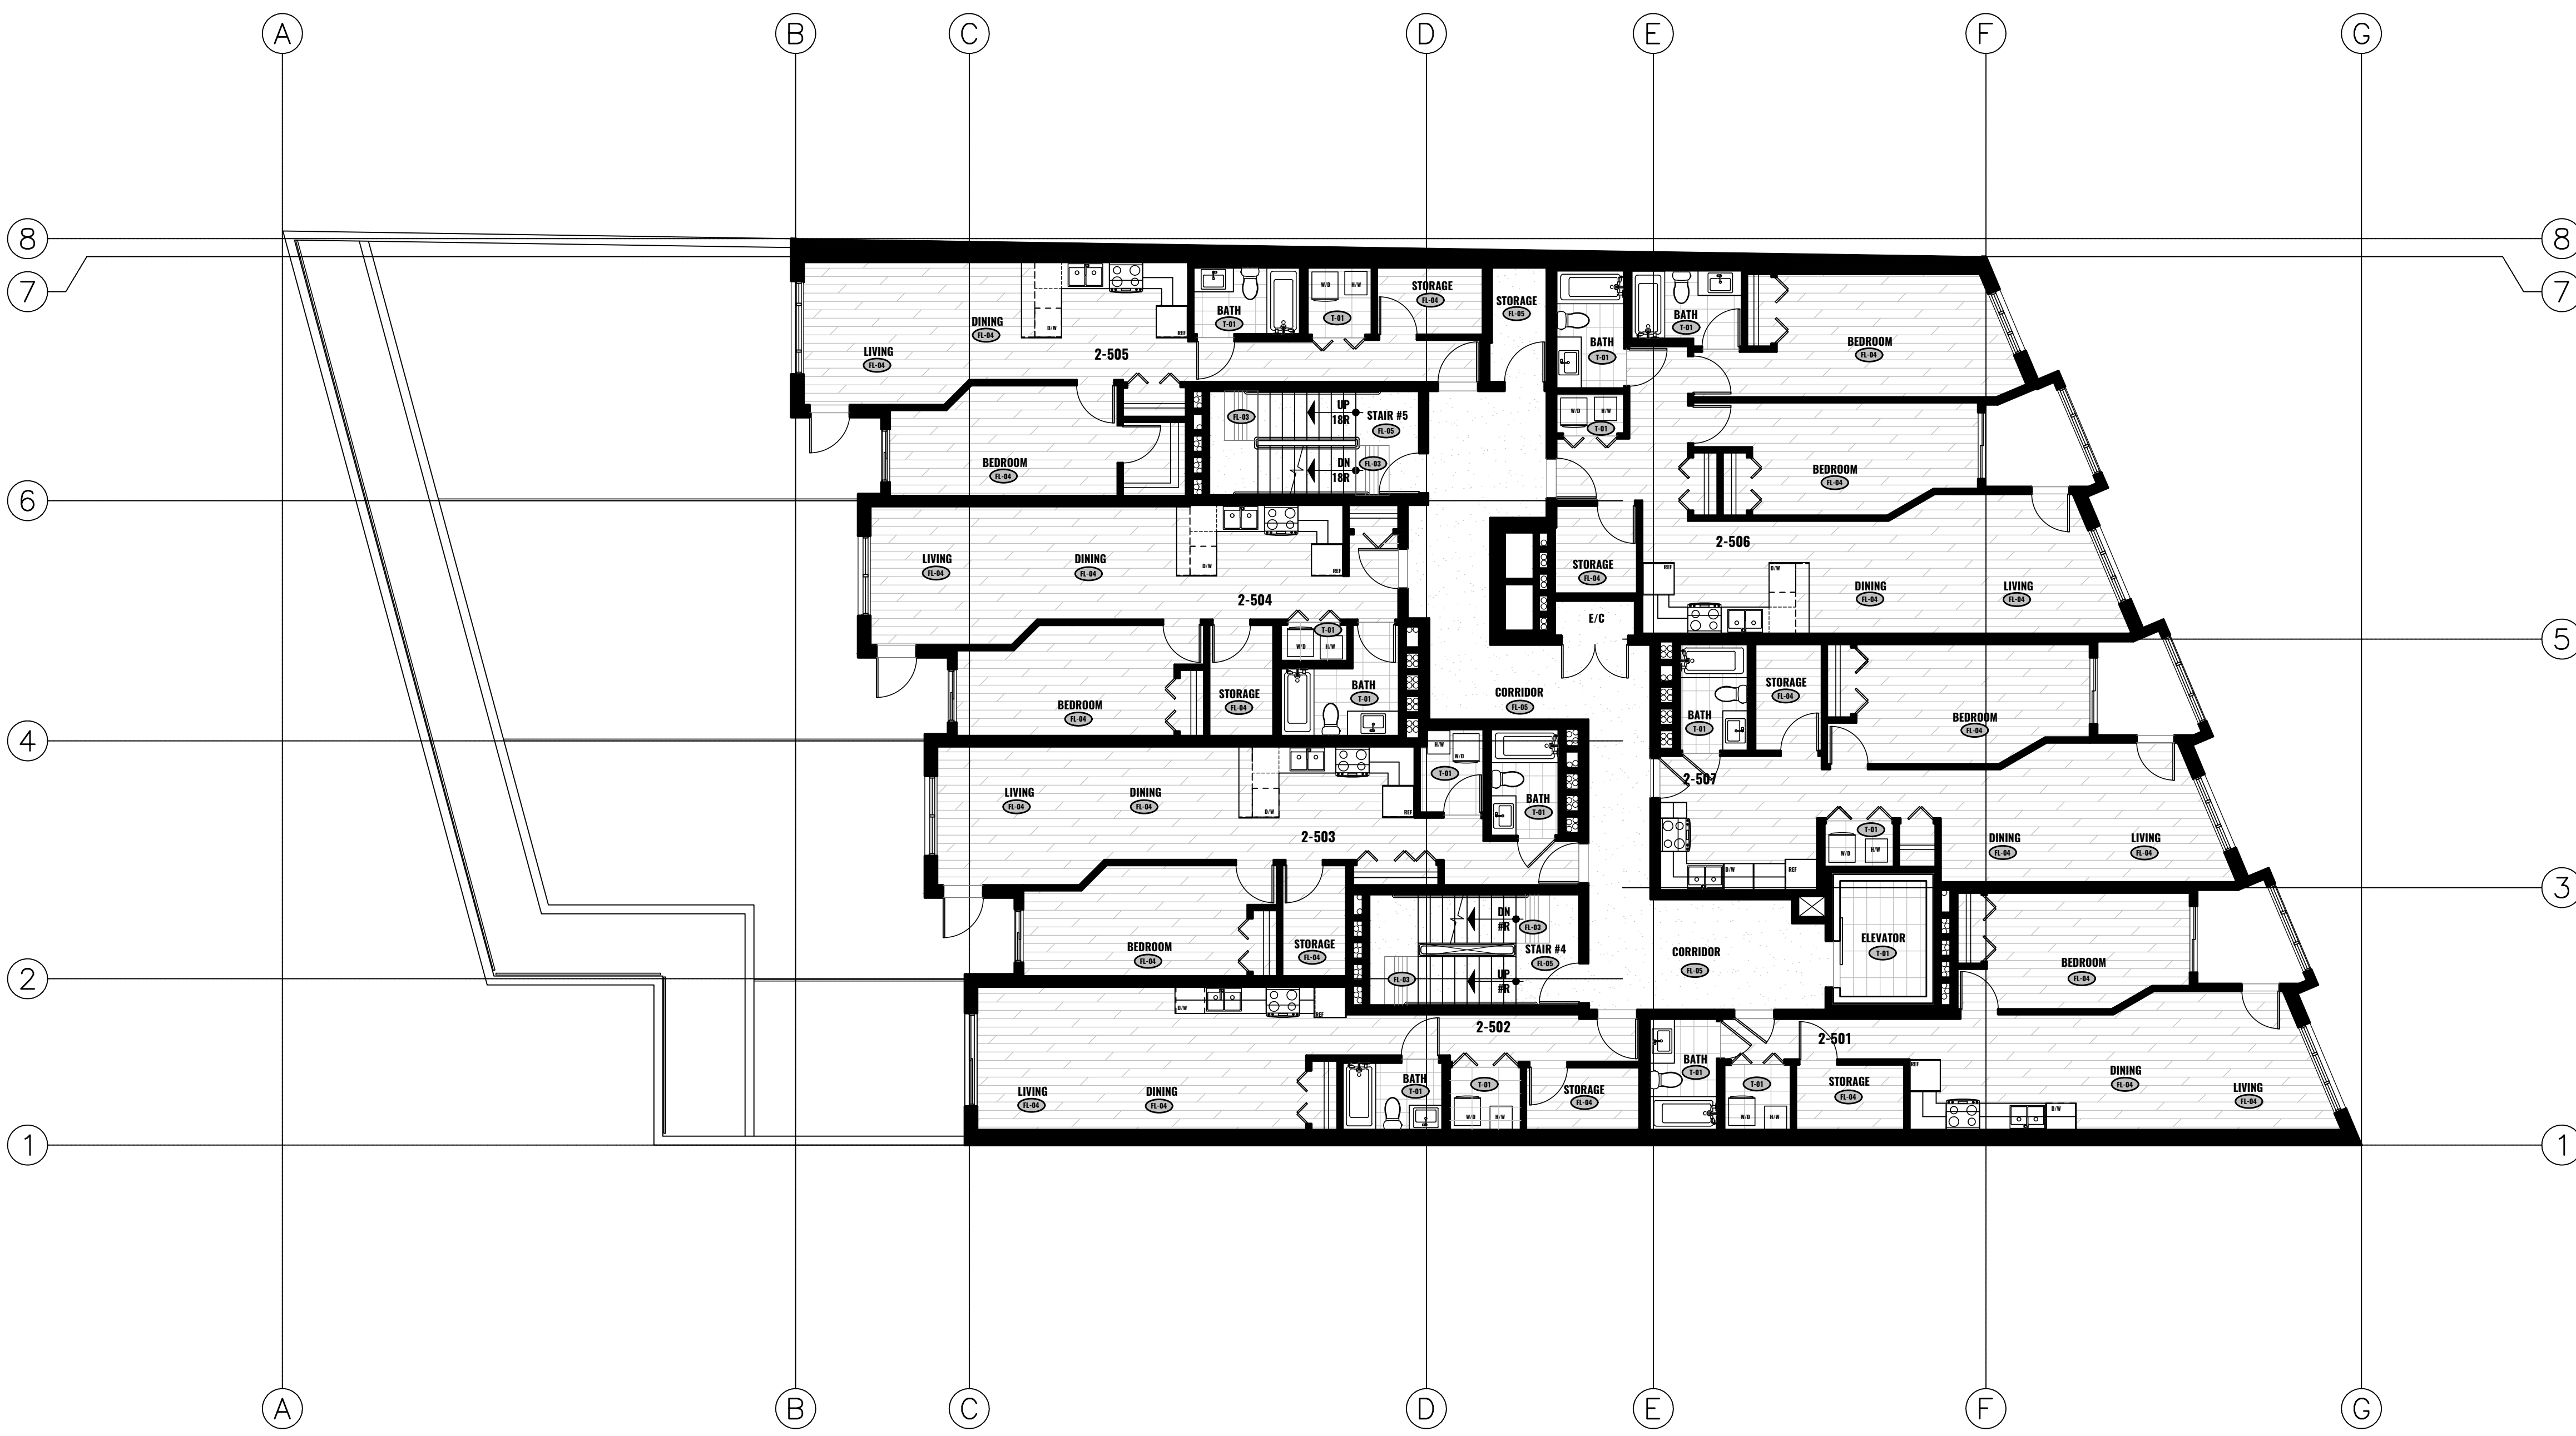

2 FINISHES PLAN
LEVELS 2-5
1/8"=1'-0"

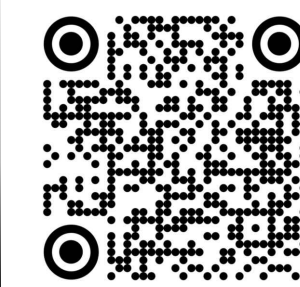


DRAWN BY
KLO/CC
DESCRIPTION
FINISHES PLAN

PROJECT NO.
P-22-09-04
PROJECT
[KINGSWAY]

ISSUE
2022.09.30
RE-ISSUE

CLIENT
LIONESTATE CONSTRUCTION


» FOCUSED INTERIORS
interior design + rendering studio
778.242.2778 | SALES@FOCUSEDINTERIORS.COM
WWW.FOCUSEDINTERIORS.COM | METRO VANCOUVER, BC, CANADA

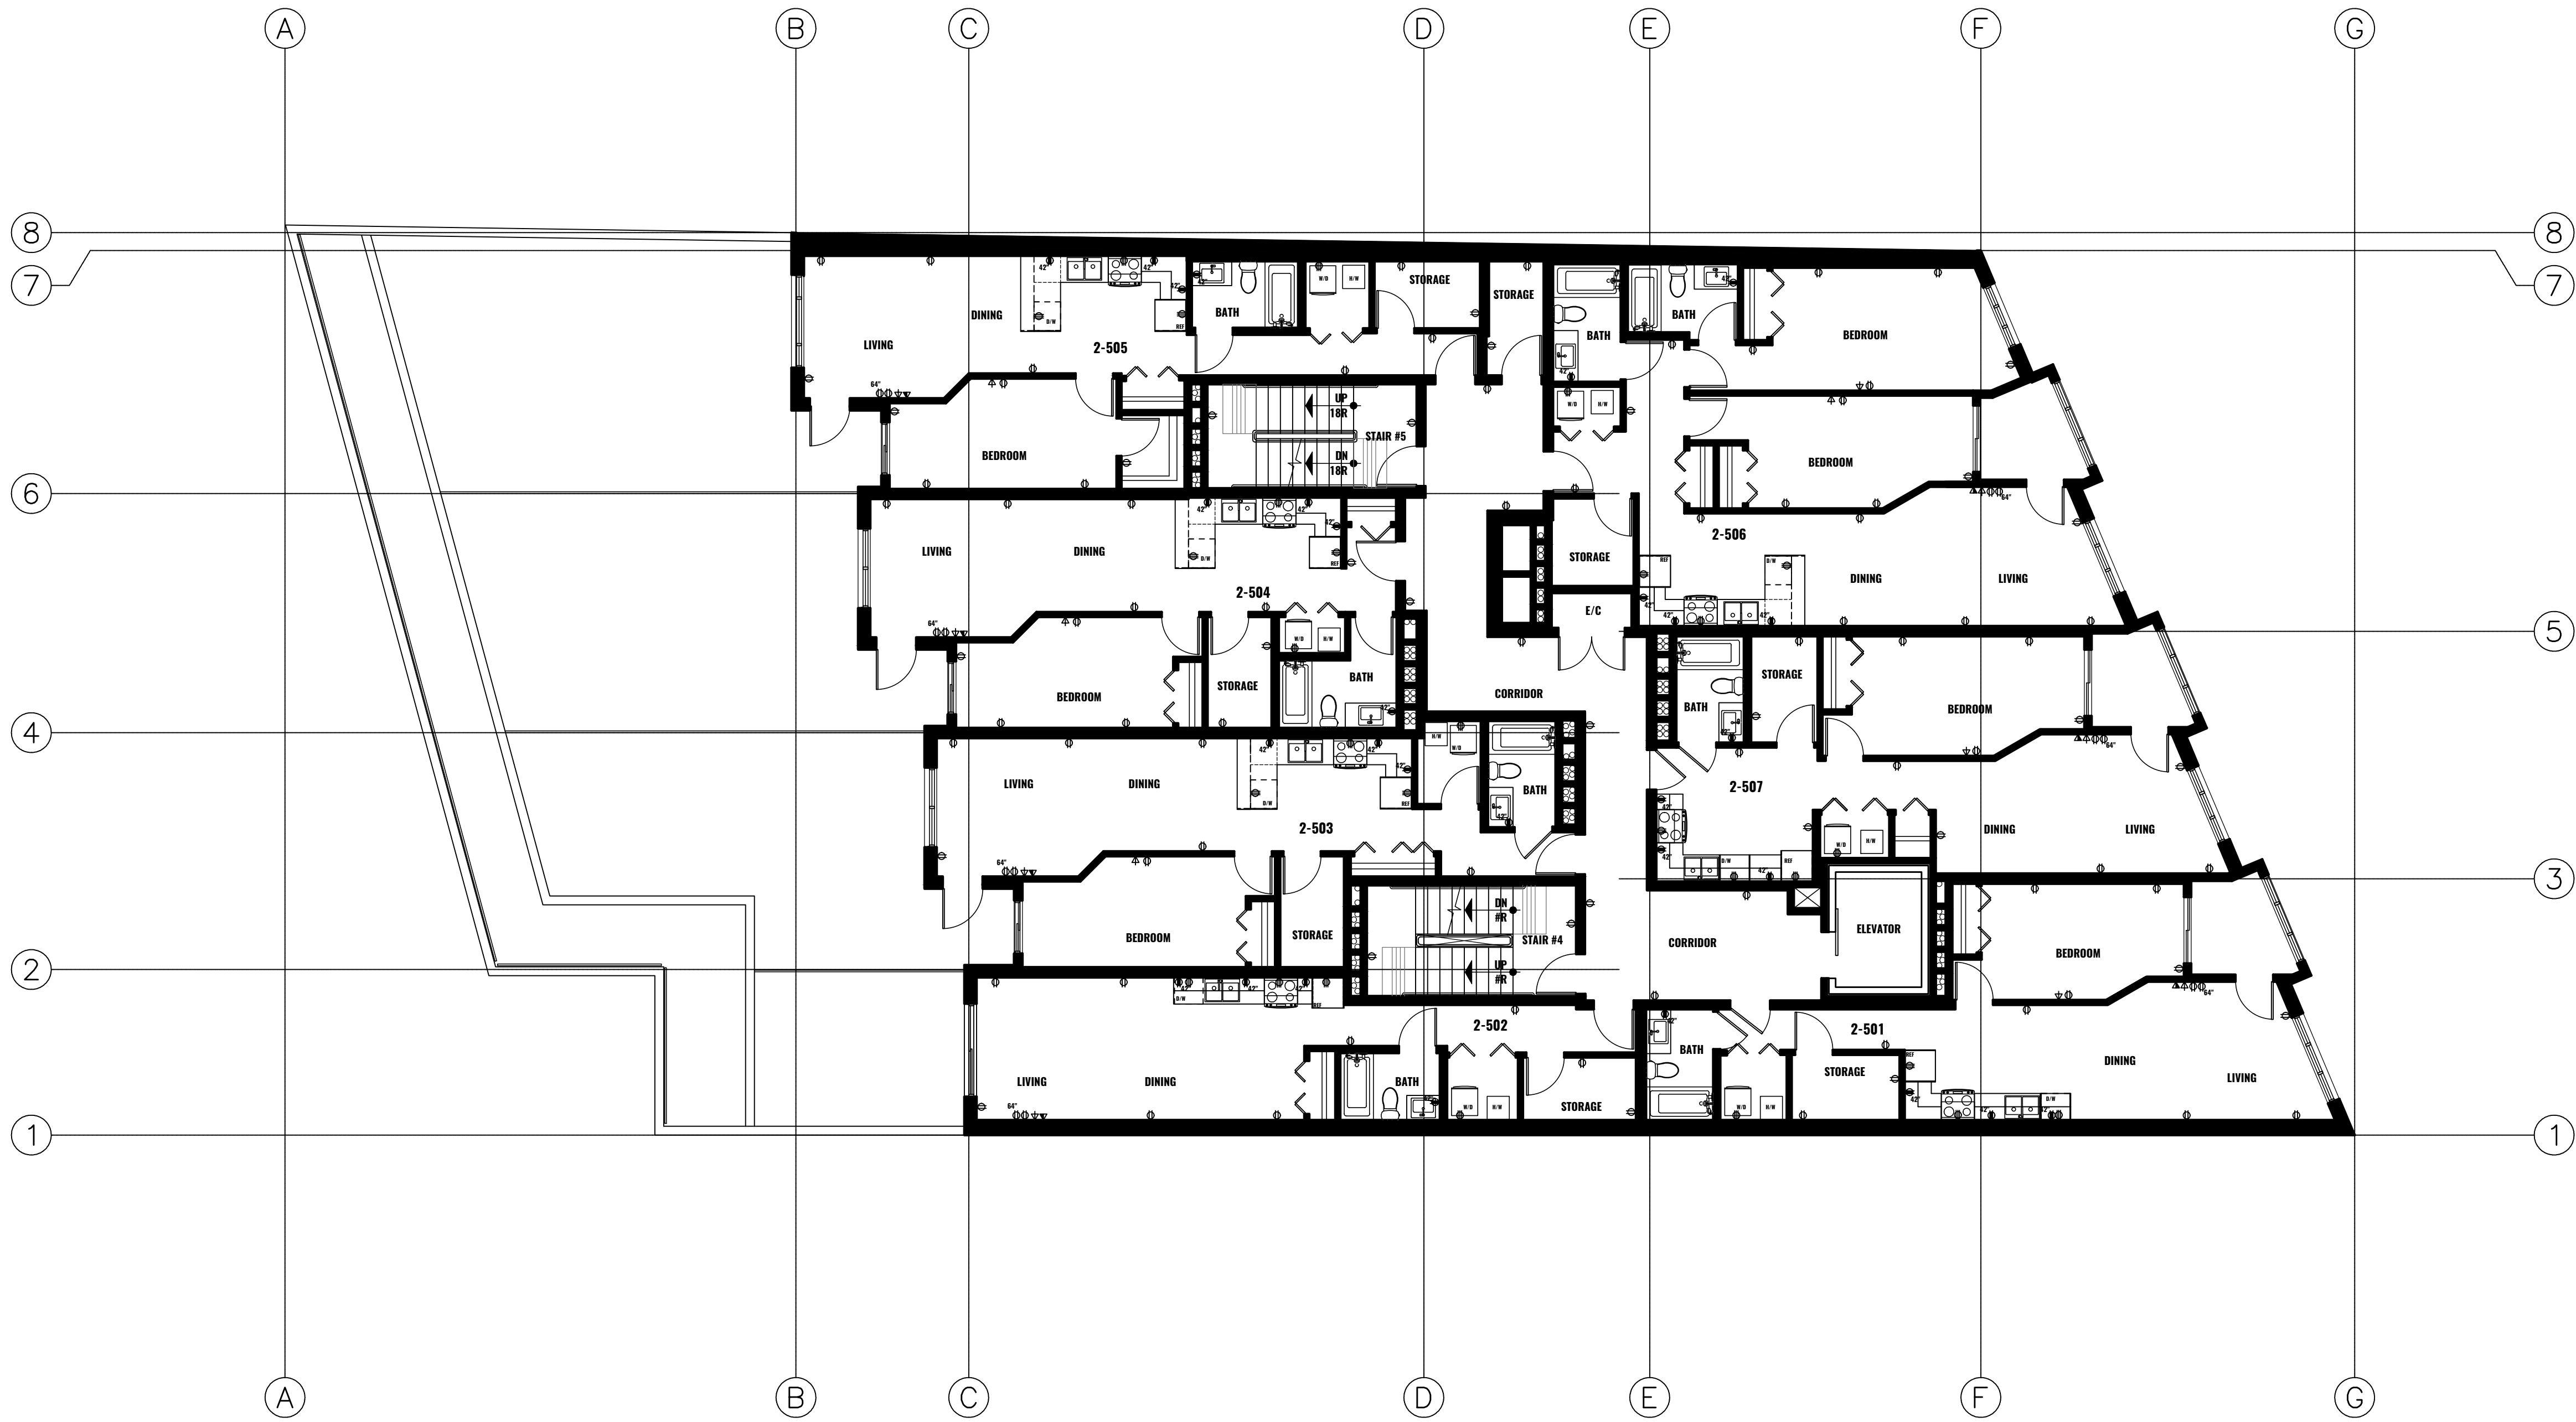


ELECTRICAL LEGEND

- CABLE OUTLET
- INTERCOM OUTLET
- DUPLEX GFI RECEPTACLE
- DUPLEX RECEPTACLE
- DEDICATED 250V RECEPTACLE

2 ELECTRICAL PLAN
LEVELS 2-5
1/8"=1'-0"

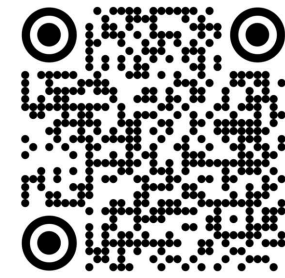

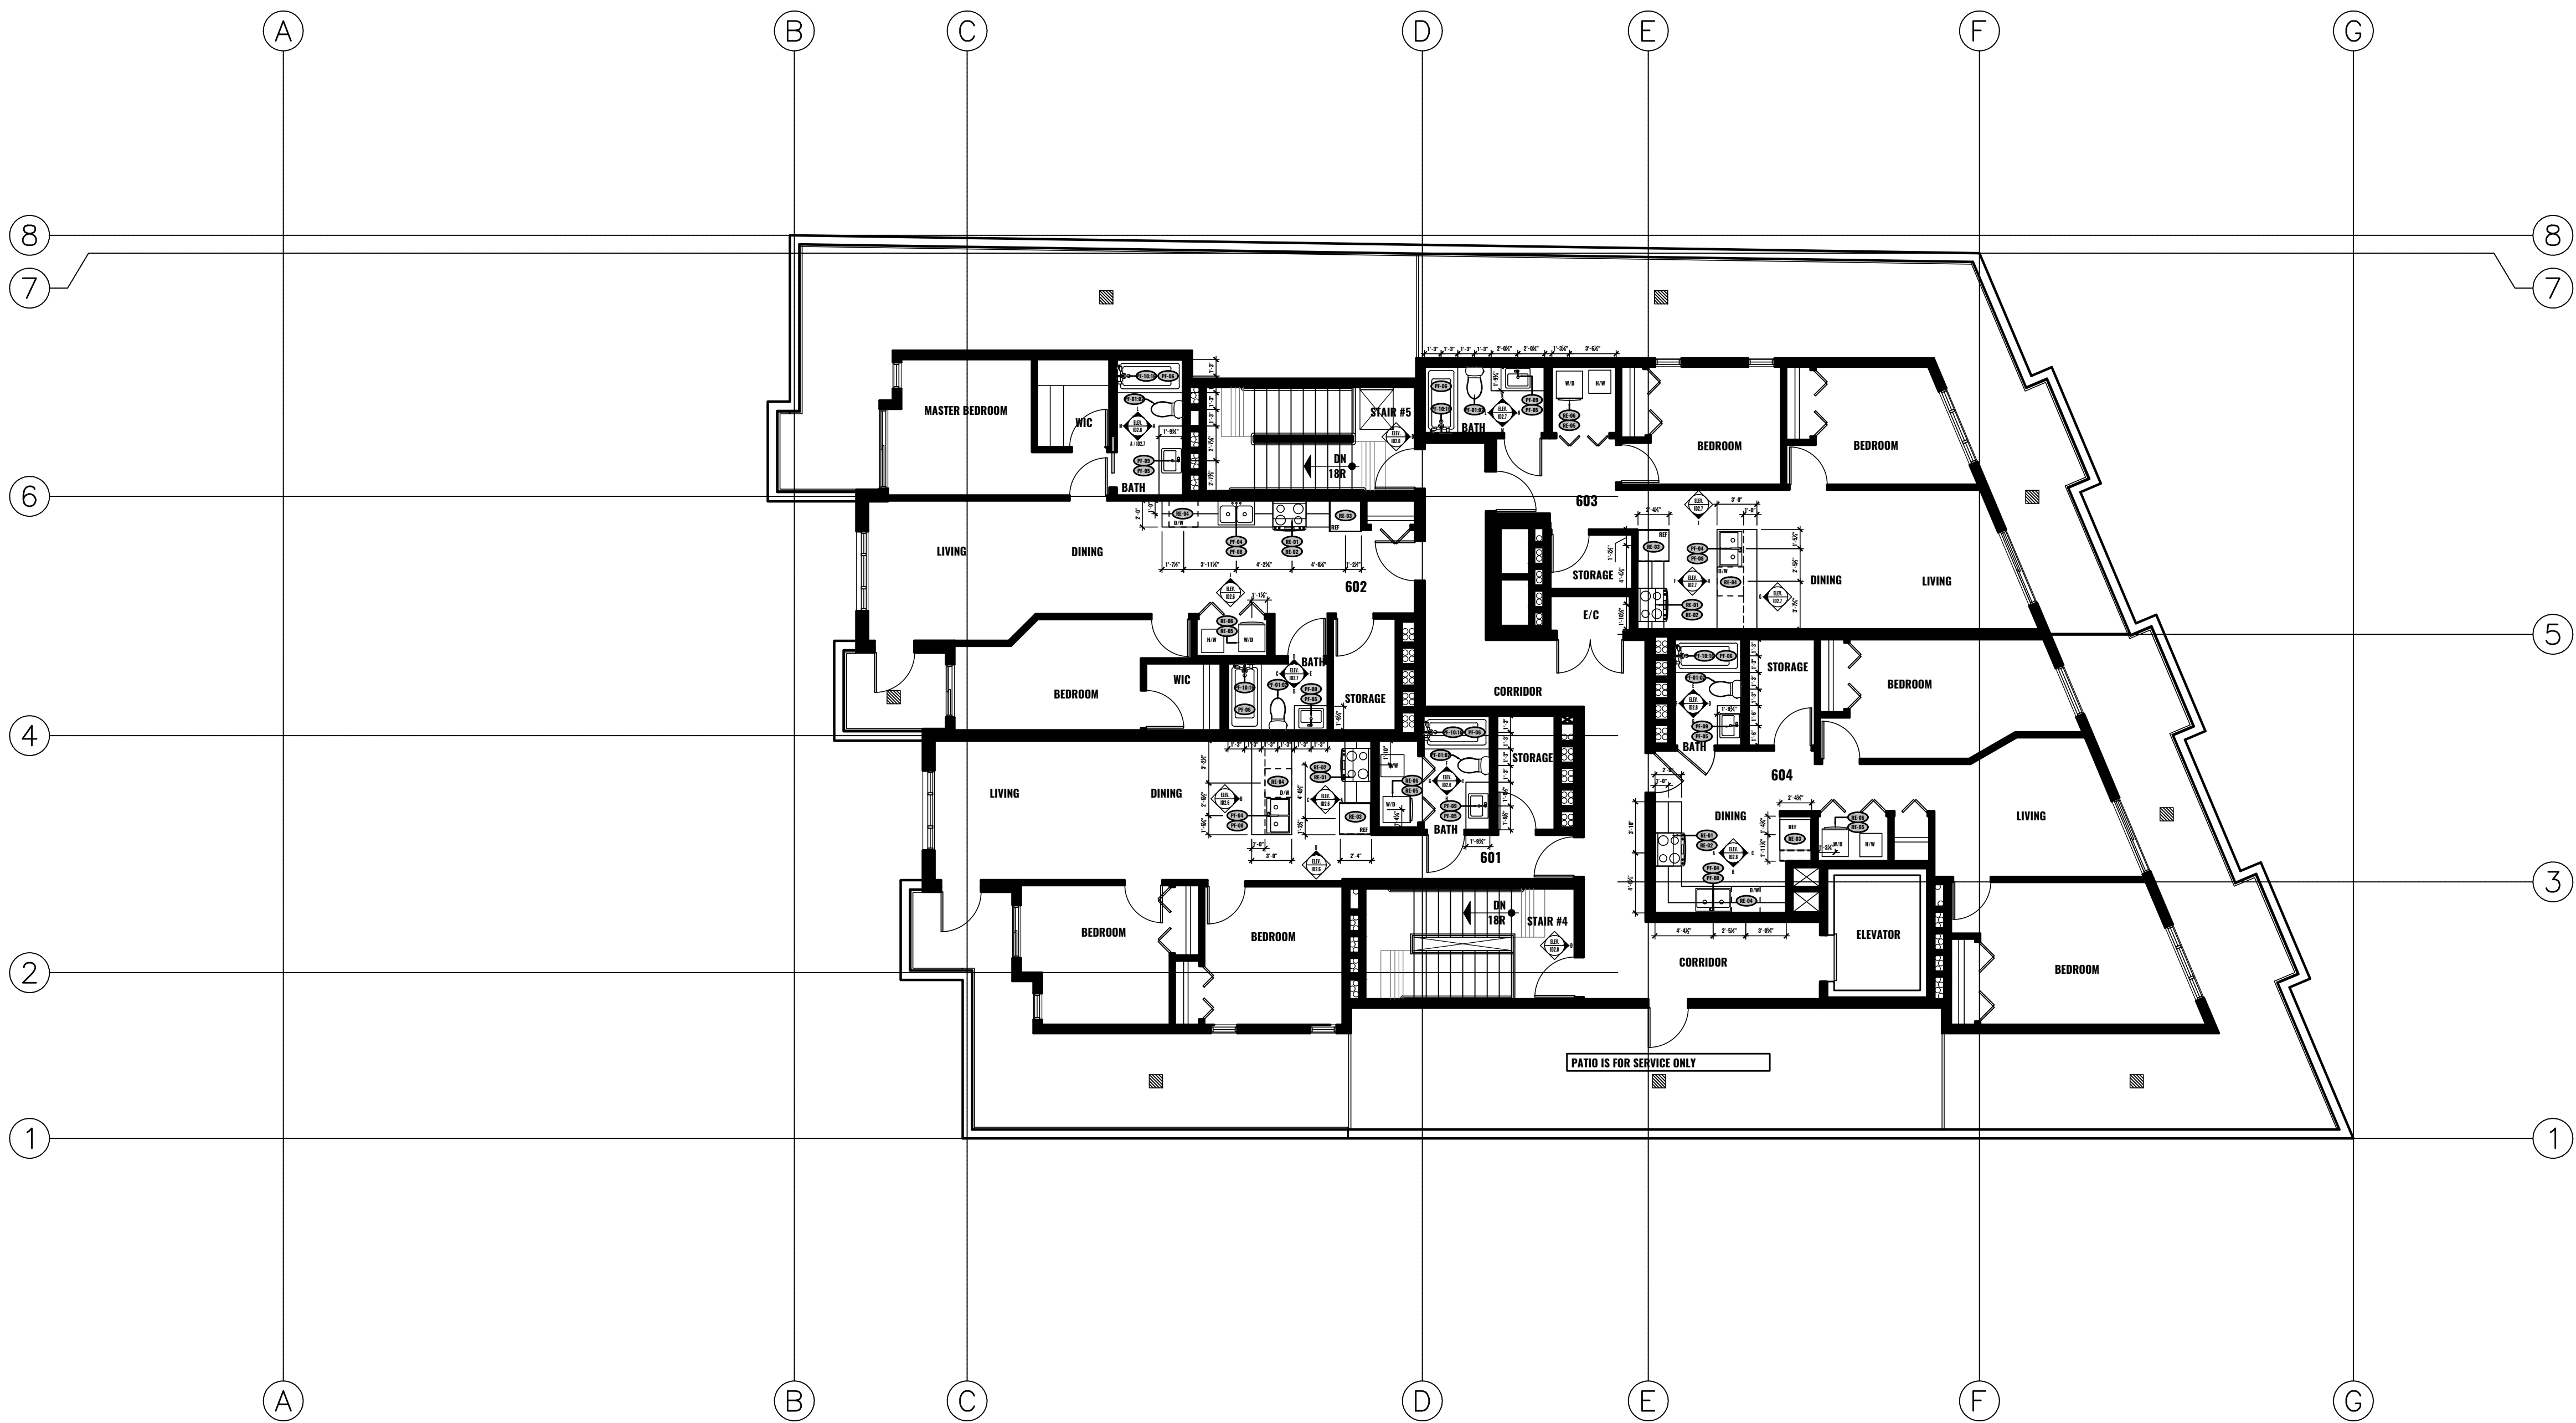

3 CONSTRUCTION PLAN
LEVEL 6
1/8"=1'-0"



DRAWN BY
KLO/CC
DESCRIPTION
CONSTRUCTION PLAN


PROJECT NO.
P-22-09-04
PROJECT
[KINGSWAY]

ISSUE
2022.09.30
RE-ISSUE


CLIENT
LIONESTATE CONSTRUCTION


» FOCUSED INTERIORS
interior design + rendering studio
778.242.2778 | SALES@FOCUSEDINTERIORS.COM
WWW.FOCUSEDINTERIORS.COM | METRO VANCOUVER, BC, CANADA

ID1.2.0

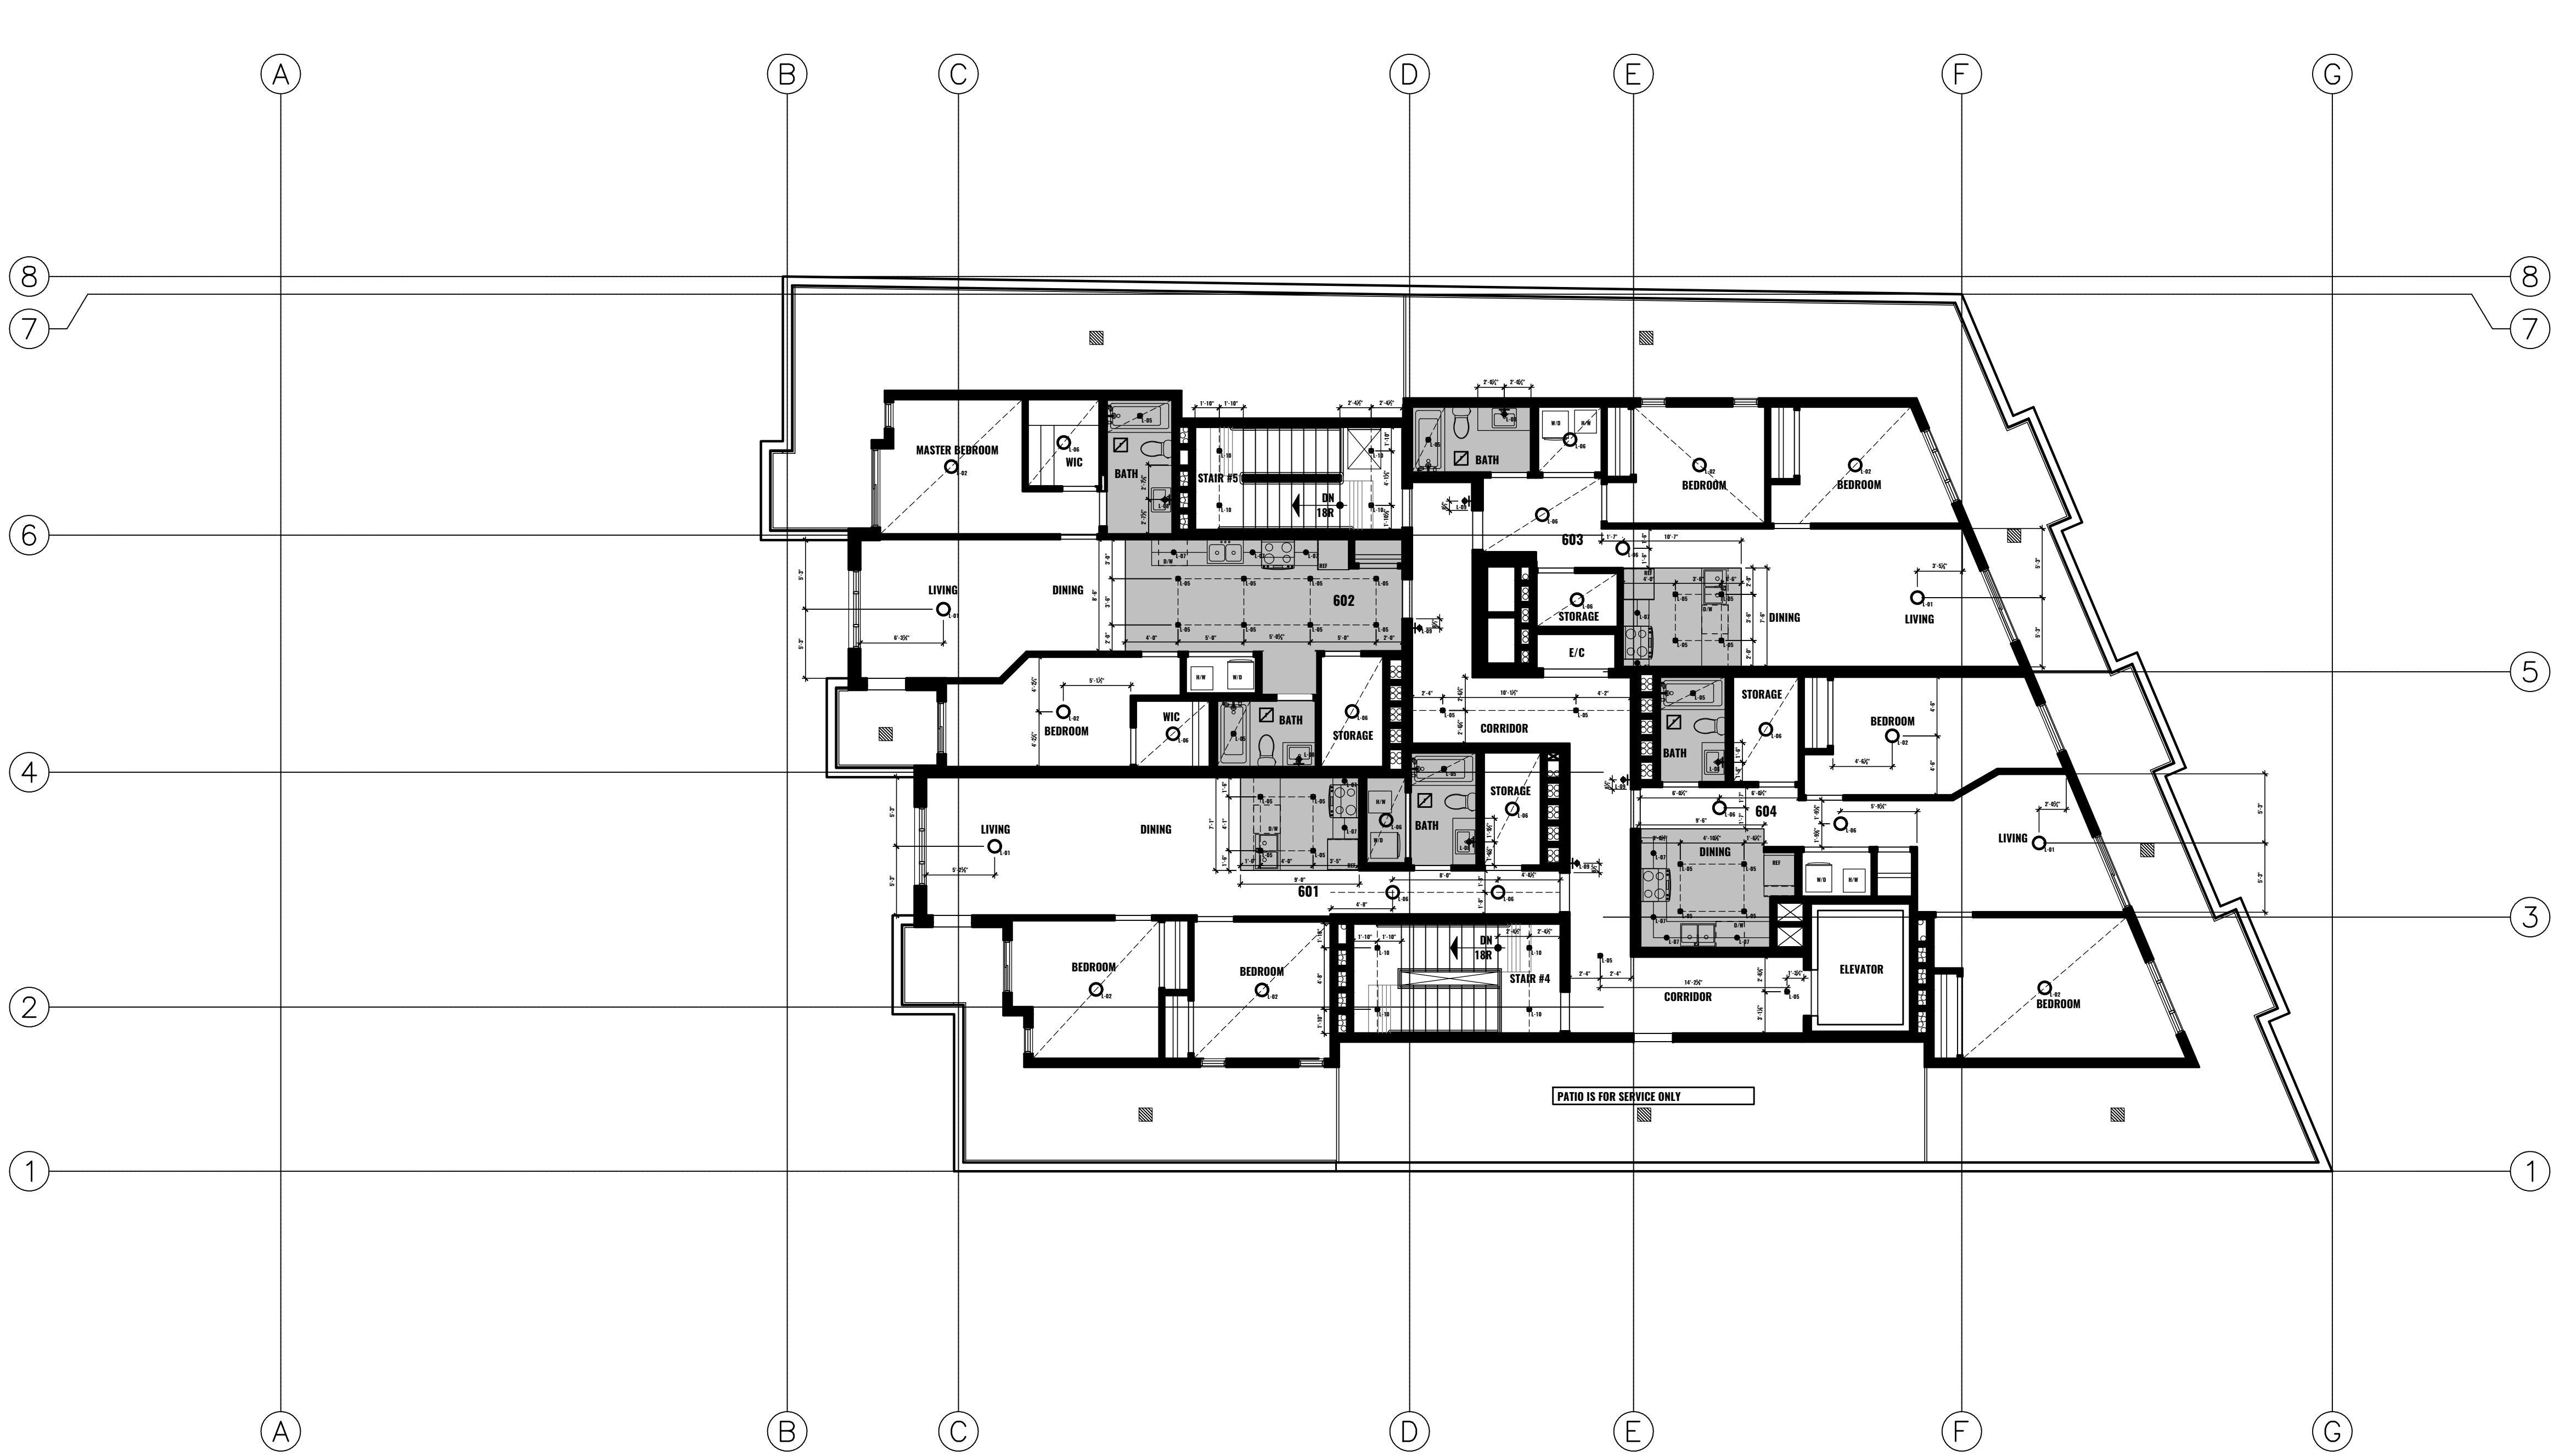


3 REFLECTED CEILING PLAN
LEVEL 6
1/8"=1'-0"

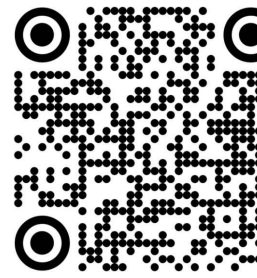

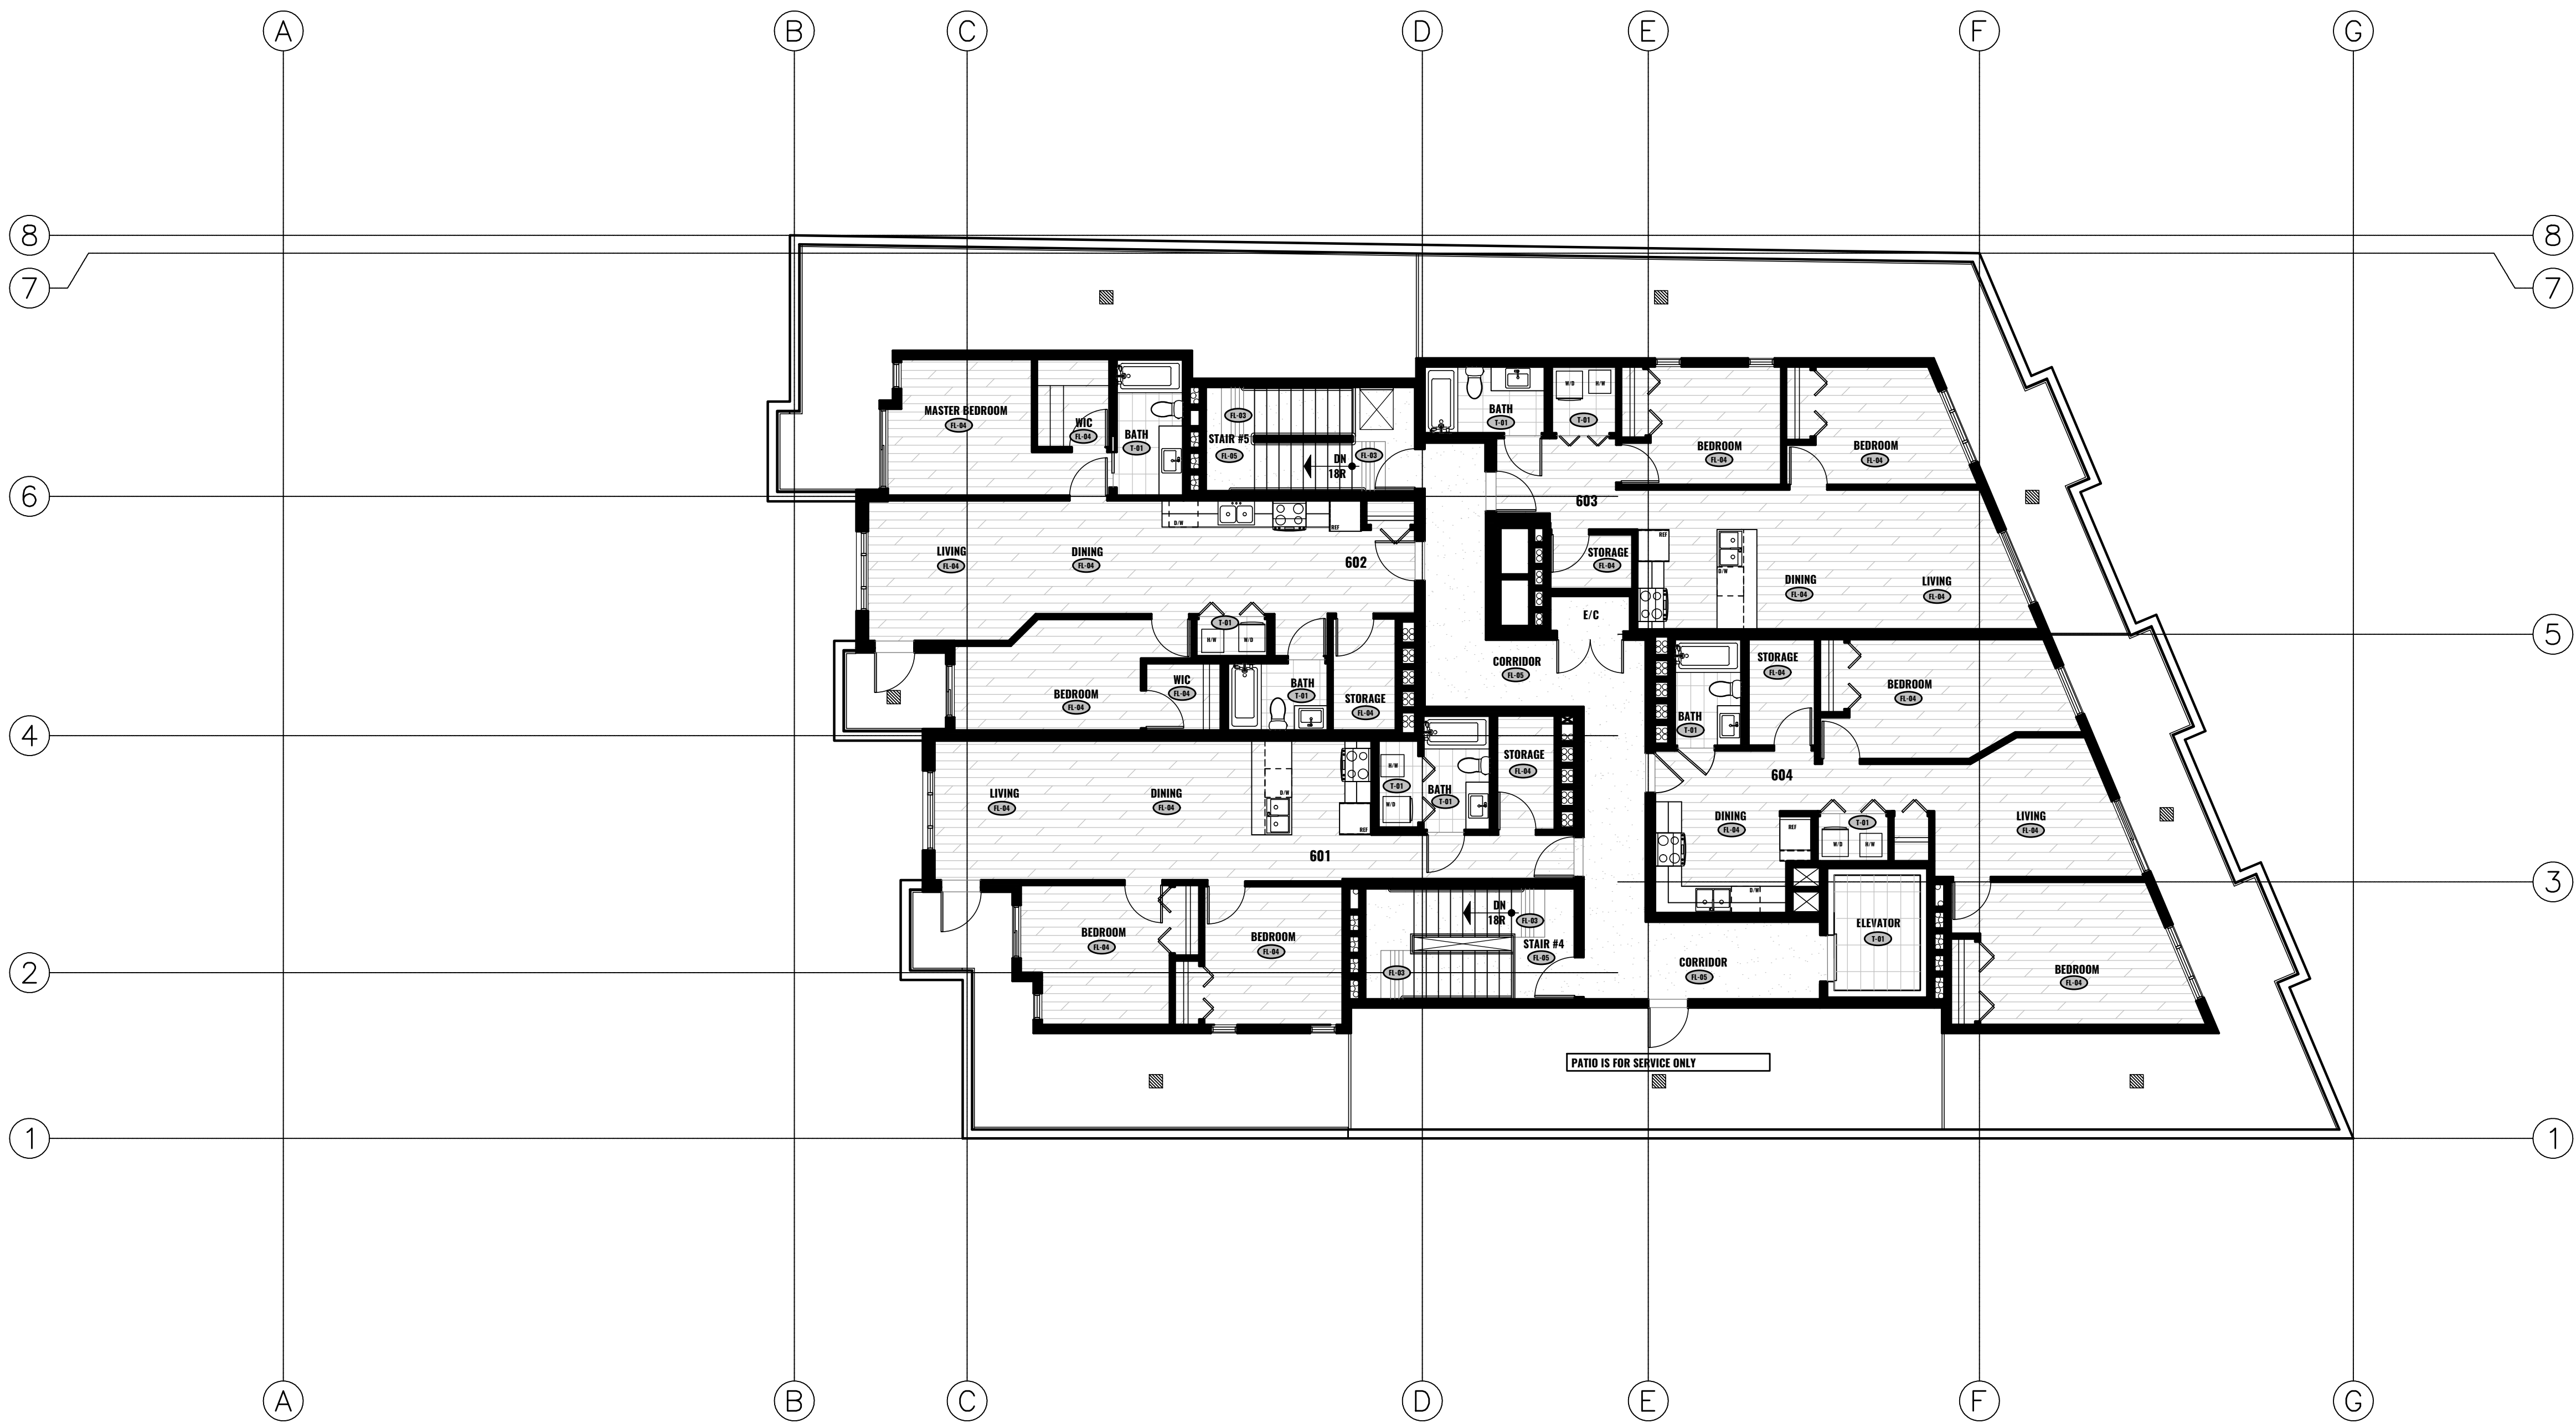

3 FINISHES PLAN
LEVEL 6
1/8"=1'-0"

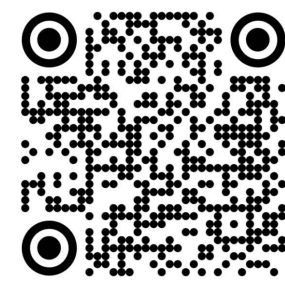

DRAWN BY
KLO/CC
DESCRIPTION
FINISHES PLAN


PROJECT NO.
P-22-09-04
PROJECT
[KINGSWAY]

ISSUE
2022.09.30
RE-ISSUE

CLIENT
LIONESTATE CONSTRUCTION


» FOCUSED INTERIORS
interior design + rendering studio
778.242.2778 | SALES@FOCUSEDINTERIORS.COM
WWW.FOCUSEDINTERIORS.COM | METRO VANCOUVER, BC, CANADA

ID1.2.2

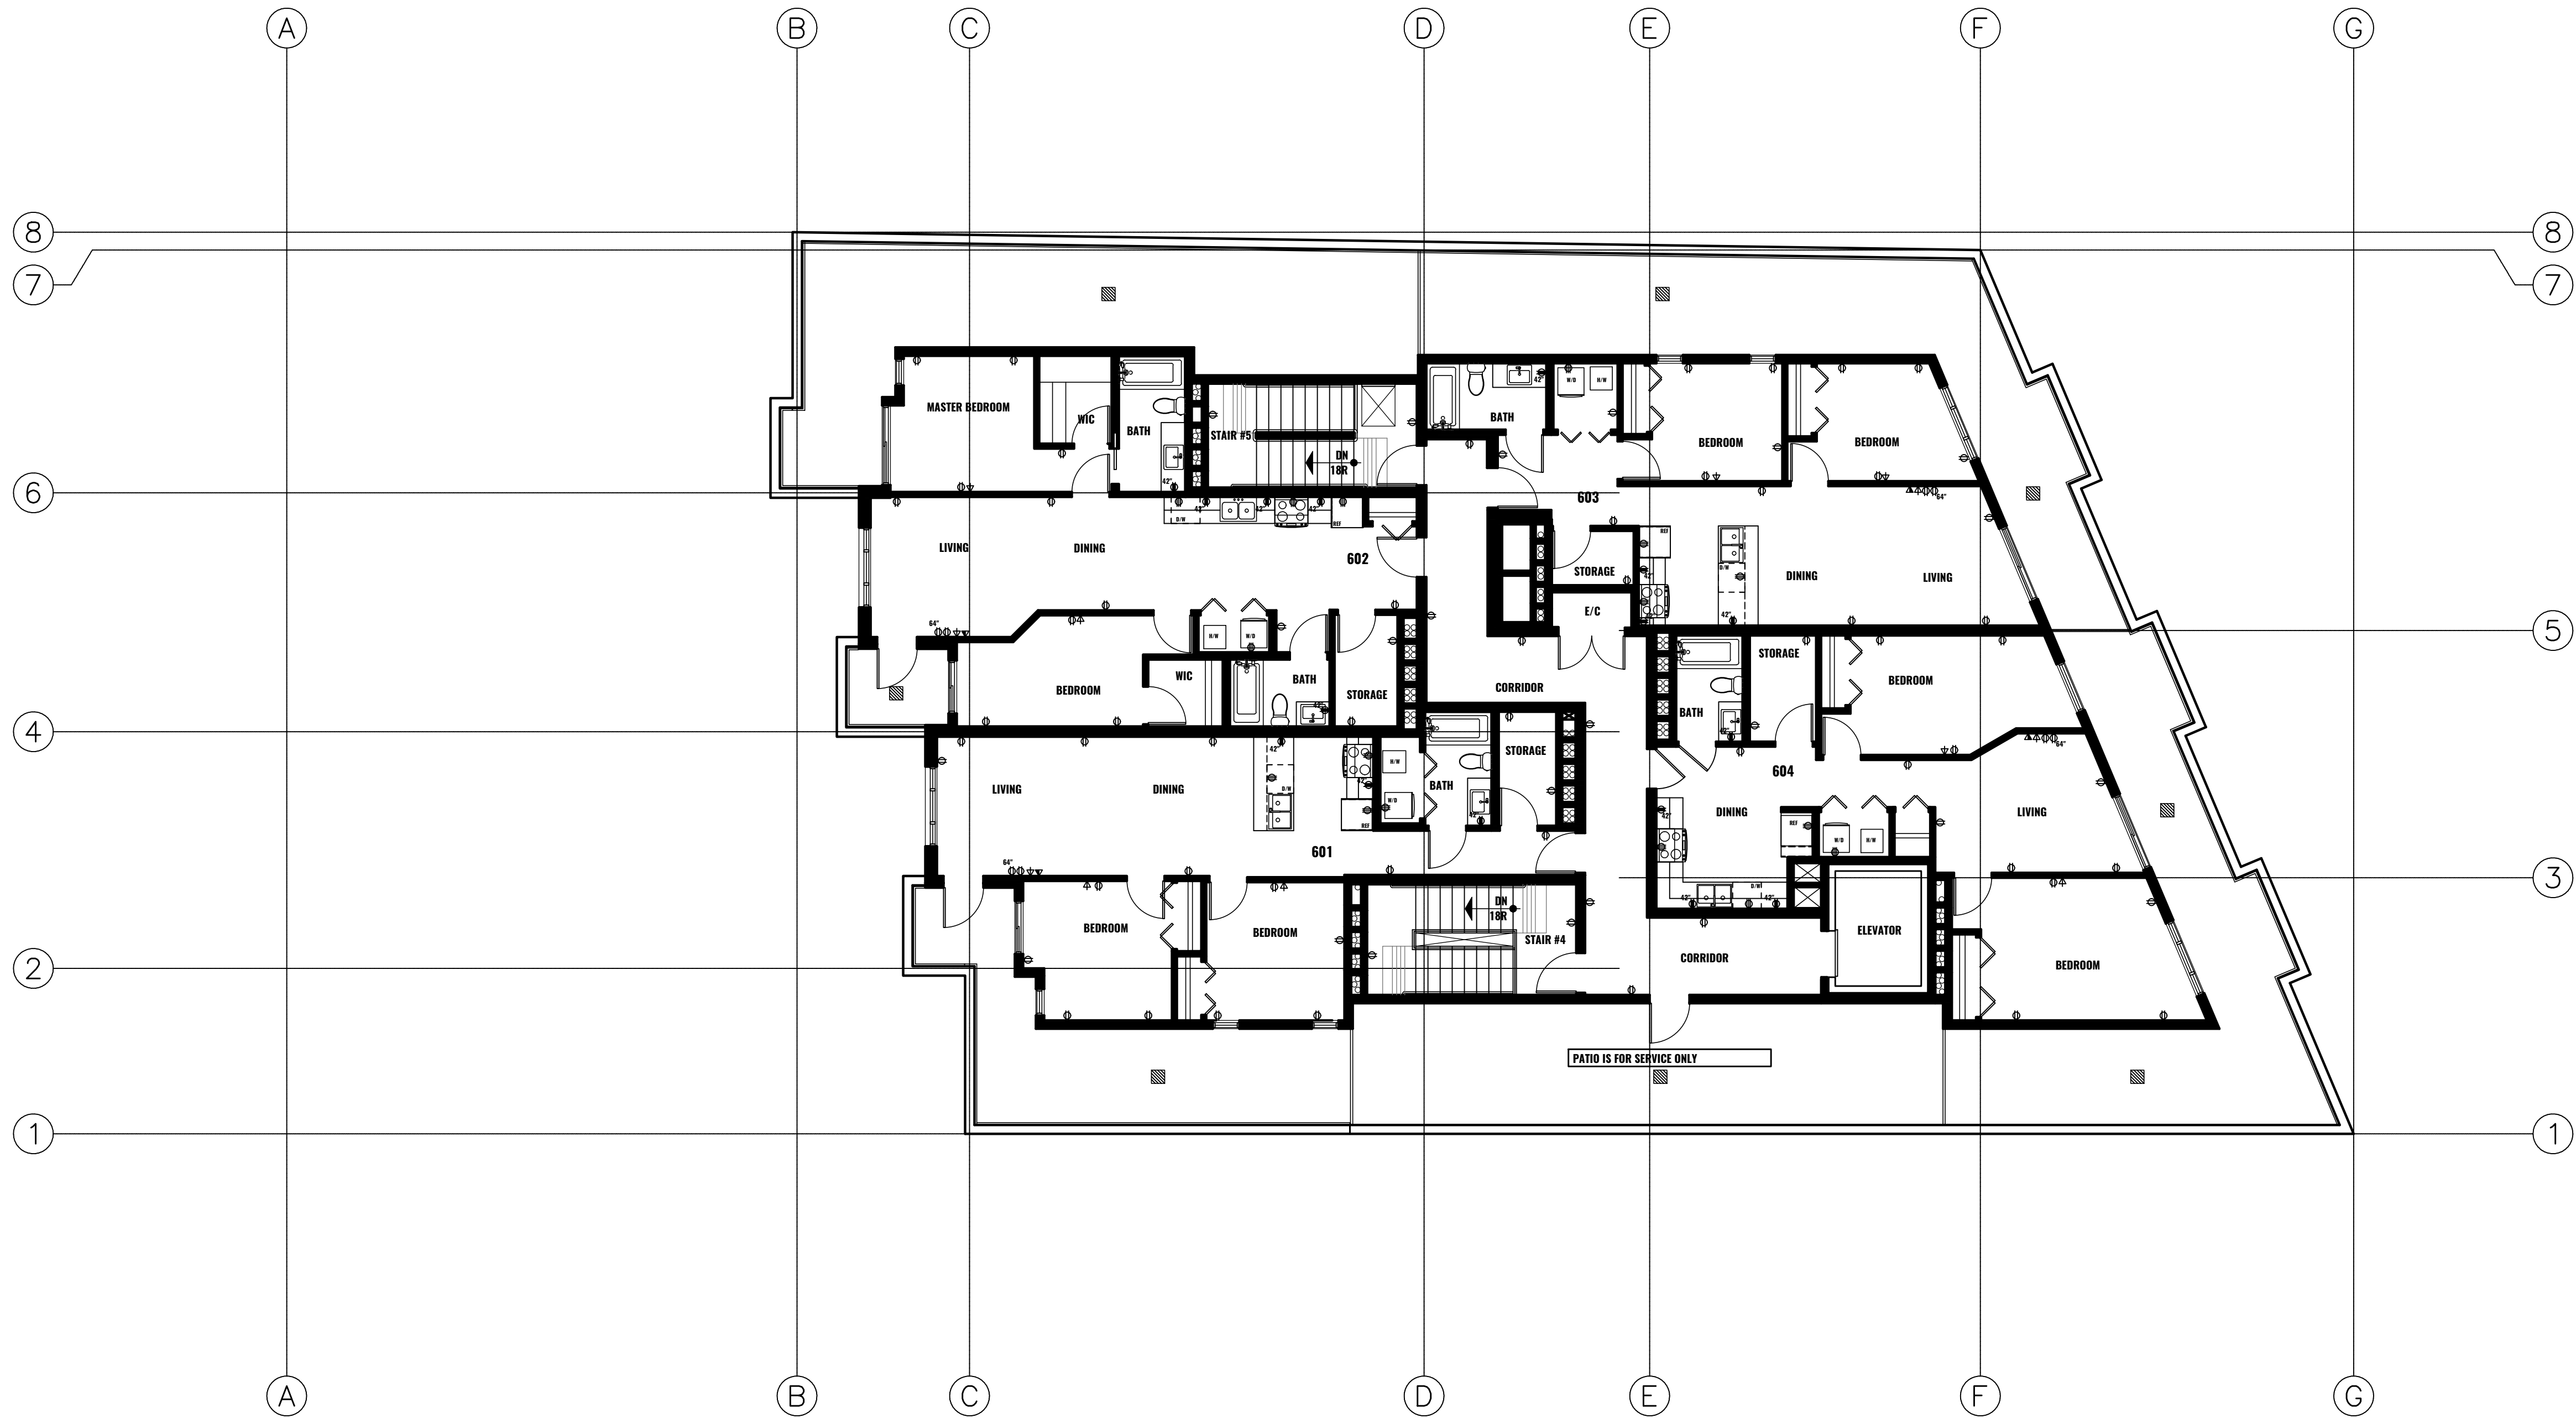

ELECTRICAL LEGEND	
	CABLE OUTLET
	INTERNET OUTLET
	DUPLEX 400 RECEPTACLE
	DUPLEX RECEPTACLE
	DEDICATED 2000 RECEPTACLE

3 ELECTRICAL PLAN
LEVEL 6
1/8"=1'-0"

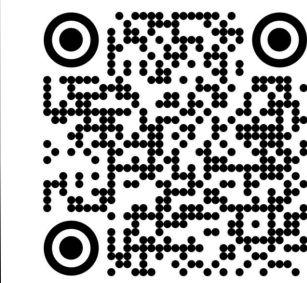

DRAWN BY
KLO/CC
DESCRIPTION
ELECTRICAL PLAN


PROJECT NO.
P-22-09-04
PROJECT
[KINGSWAY]

ISSUE
2022.09.30
RE-ISSUE


CLIENT
LIONESTATE CONSTRUCTION

» FOCUSED INTERIORS
interior design + rendering studio
778.242.2778 | SALES@FOCUSEDINTERIORS.COM
WWW.FOCUSEDINTERIORS.COM | METRO VANCOUVER, BC, CANADA


ID1.2.3

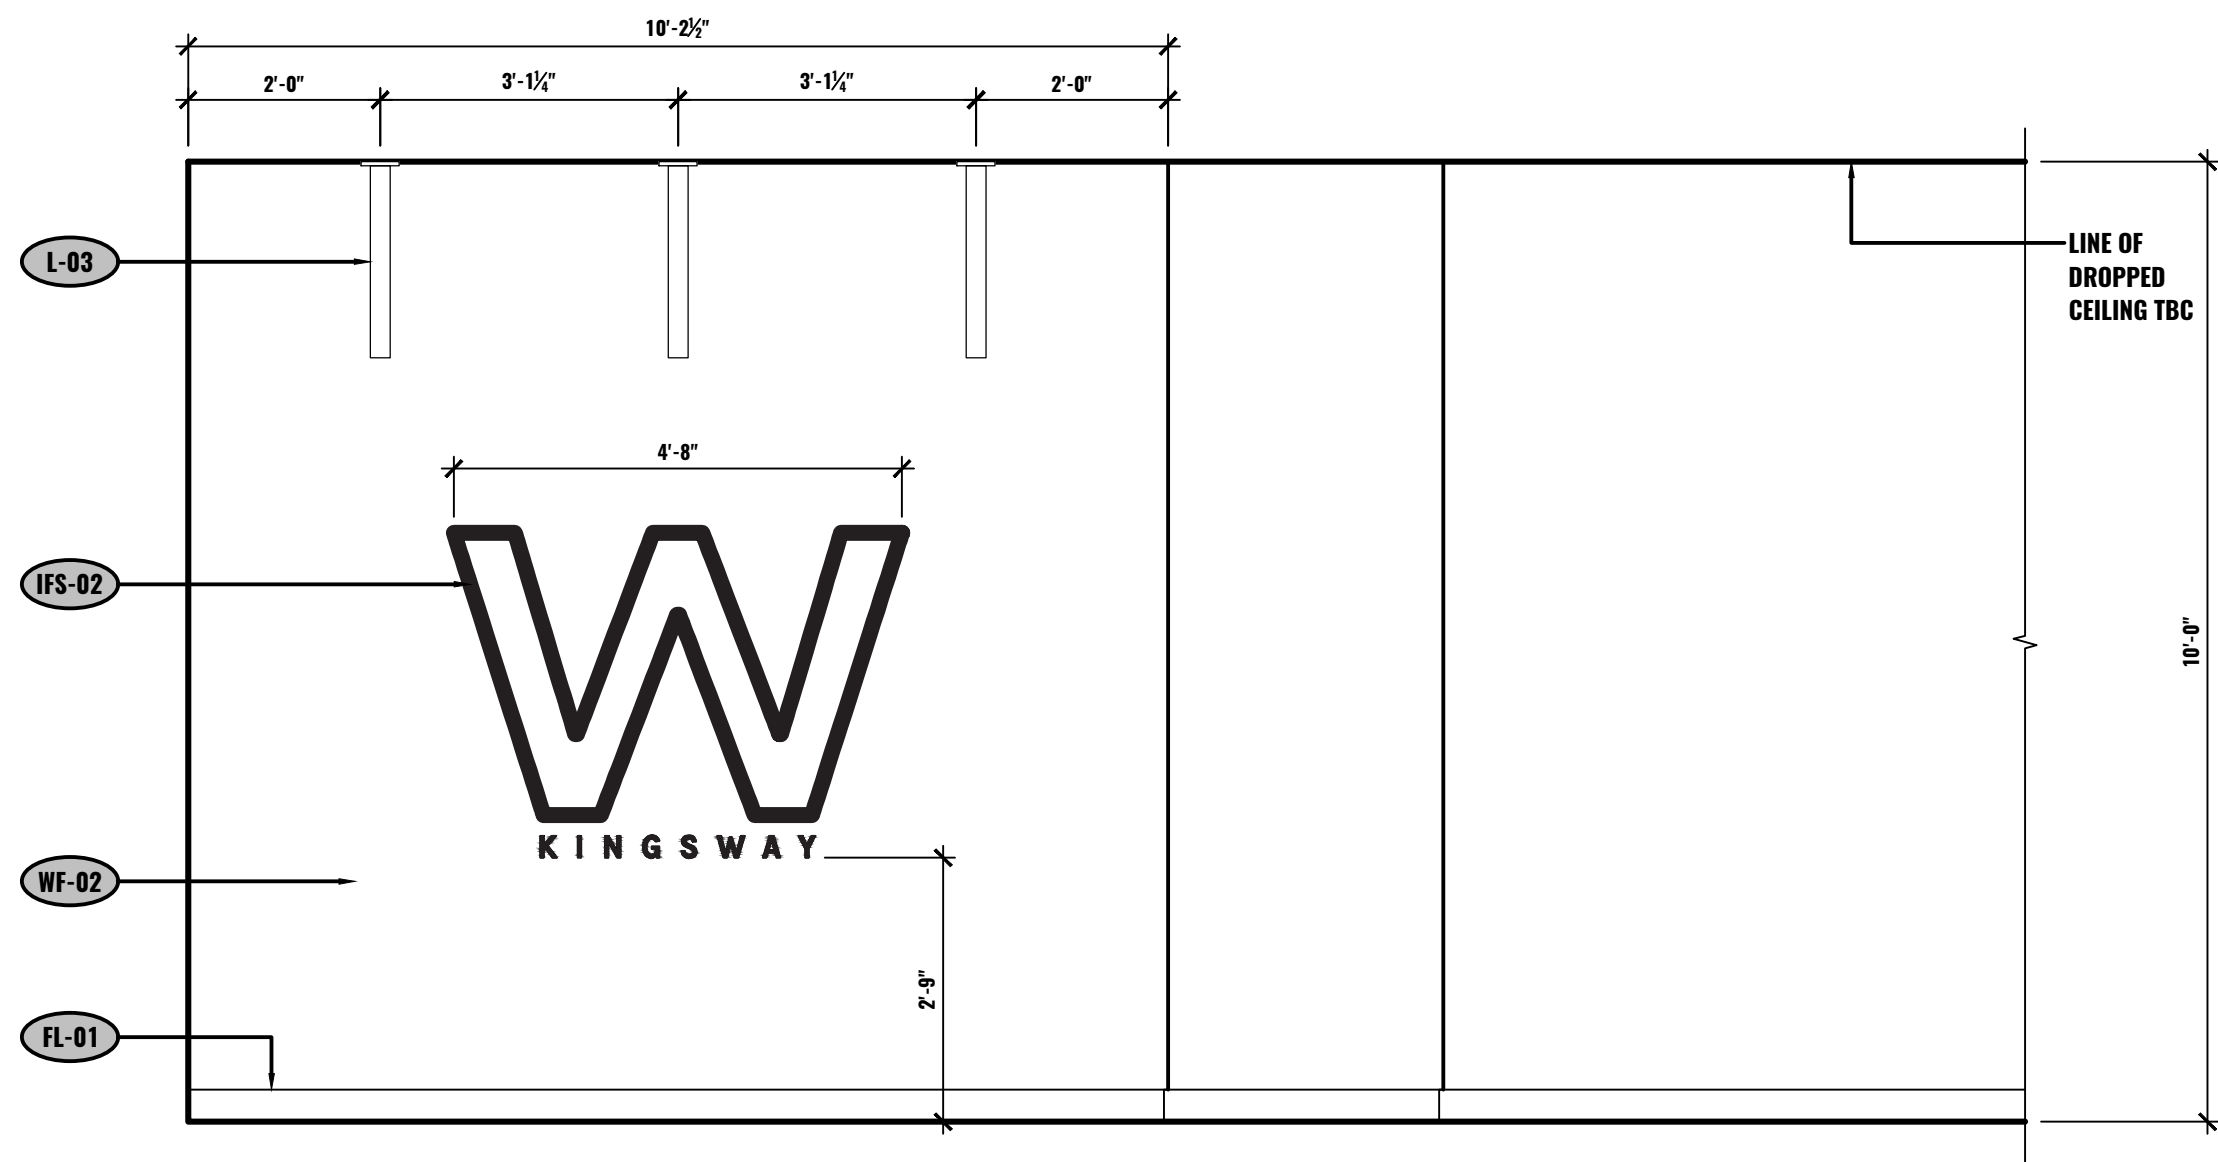


A ELEVATION - ELEVATOR LOBBY
LEVEL 1
1/2"=1'-0"

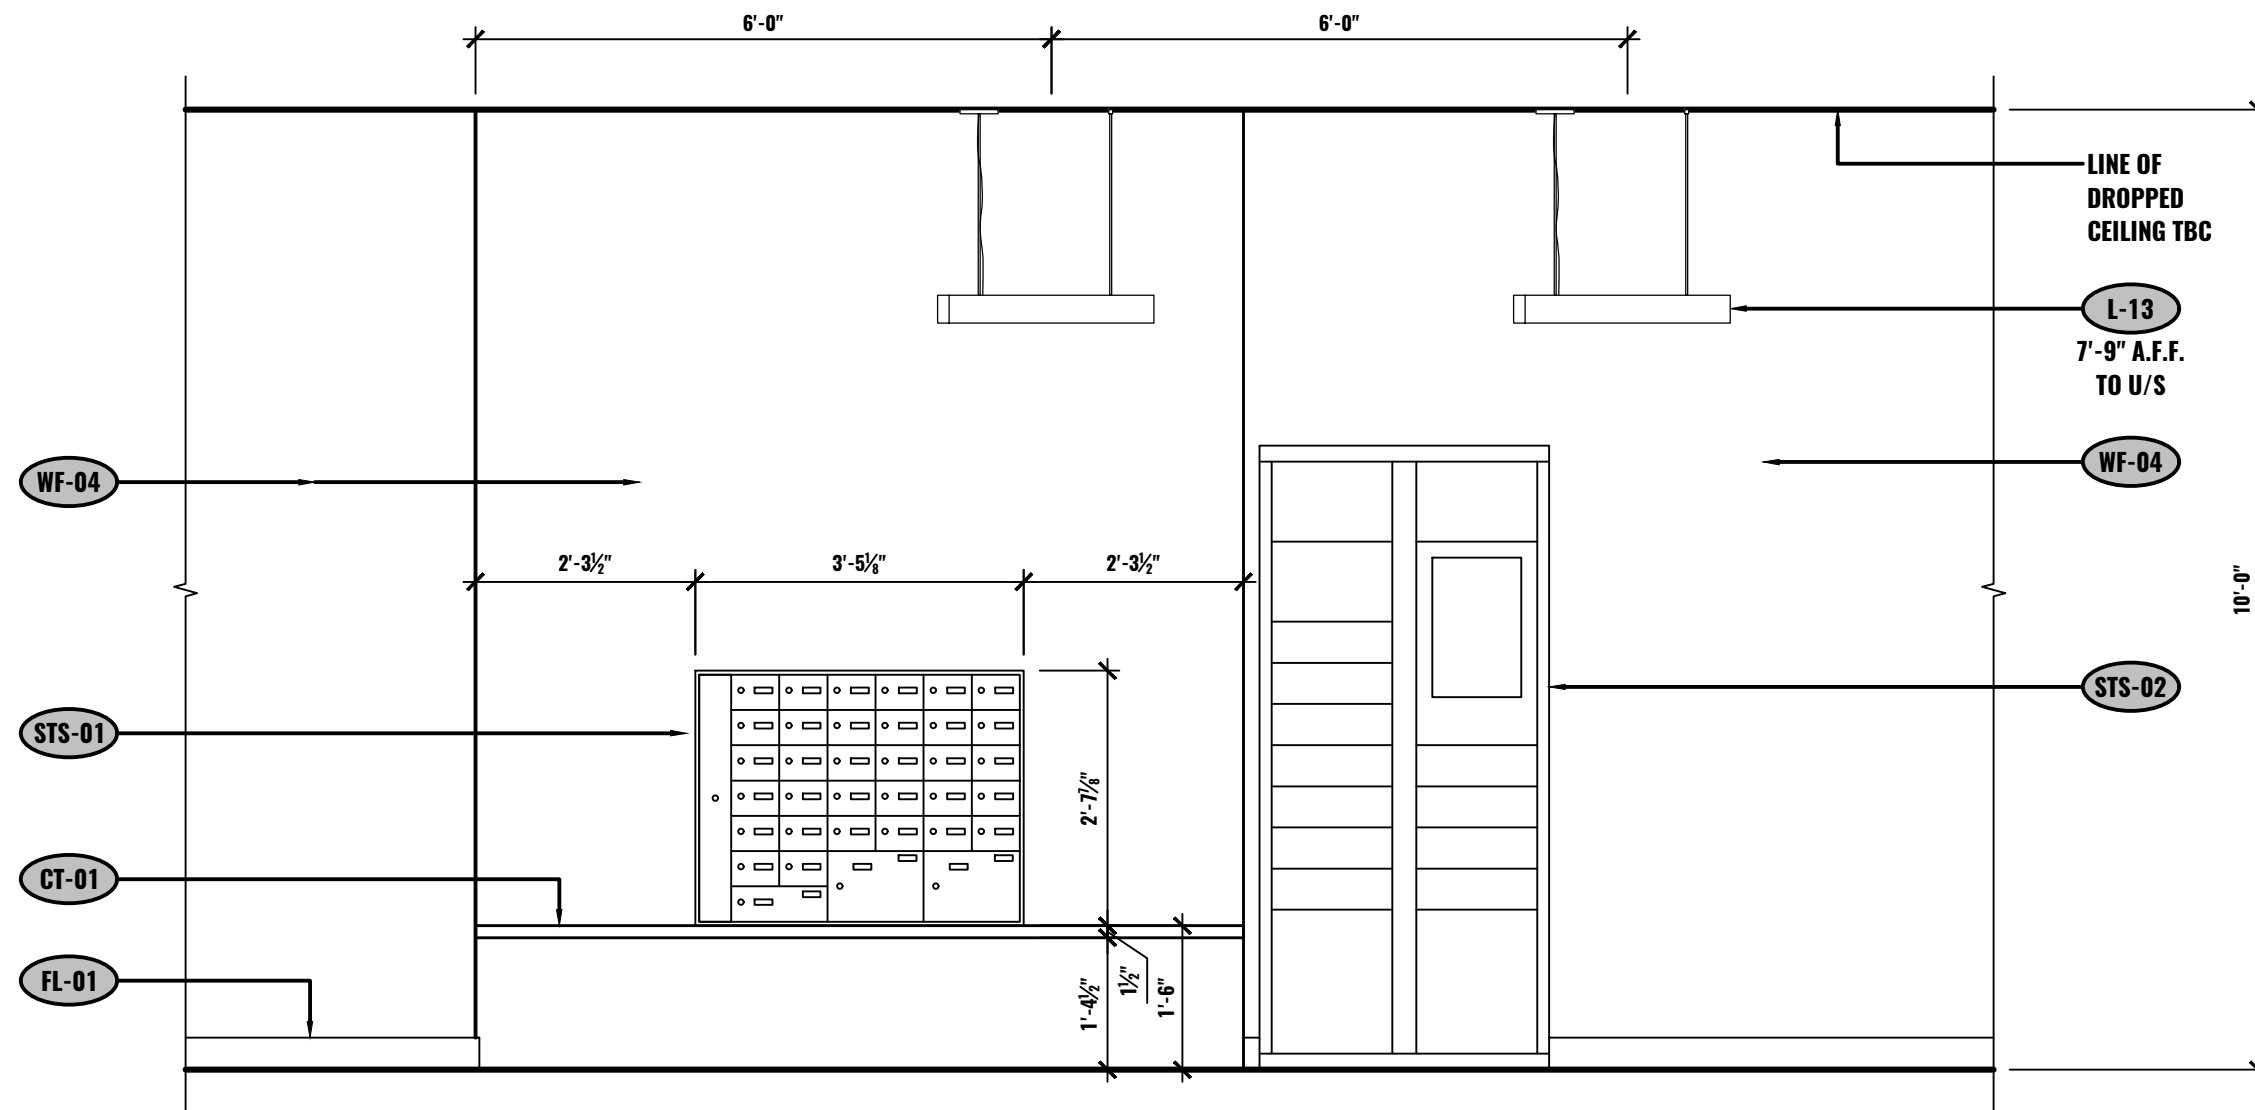


B ELEVATION - ELEVATOR LOBBY
LEVEL 1
1/2"=1'-0"

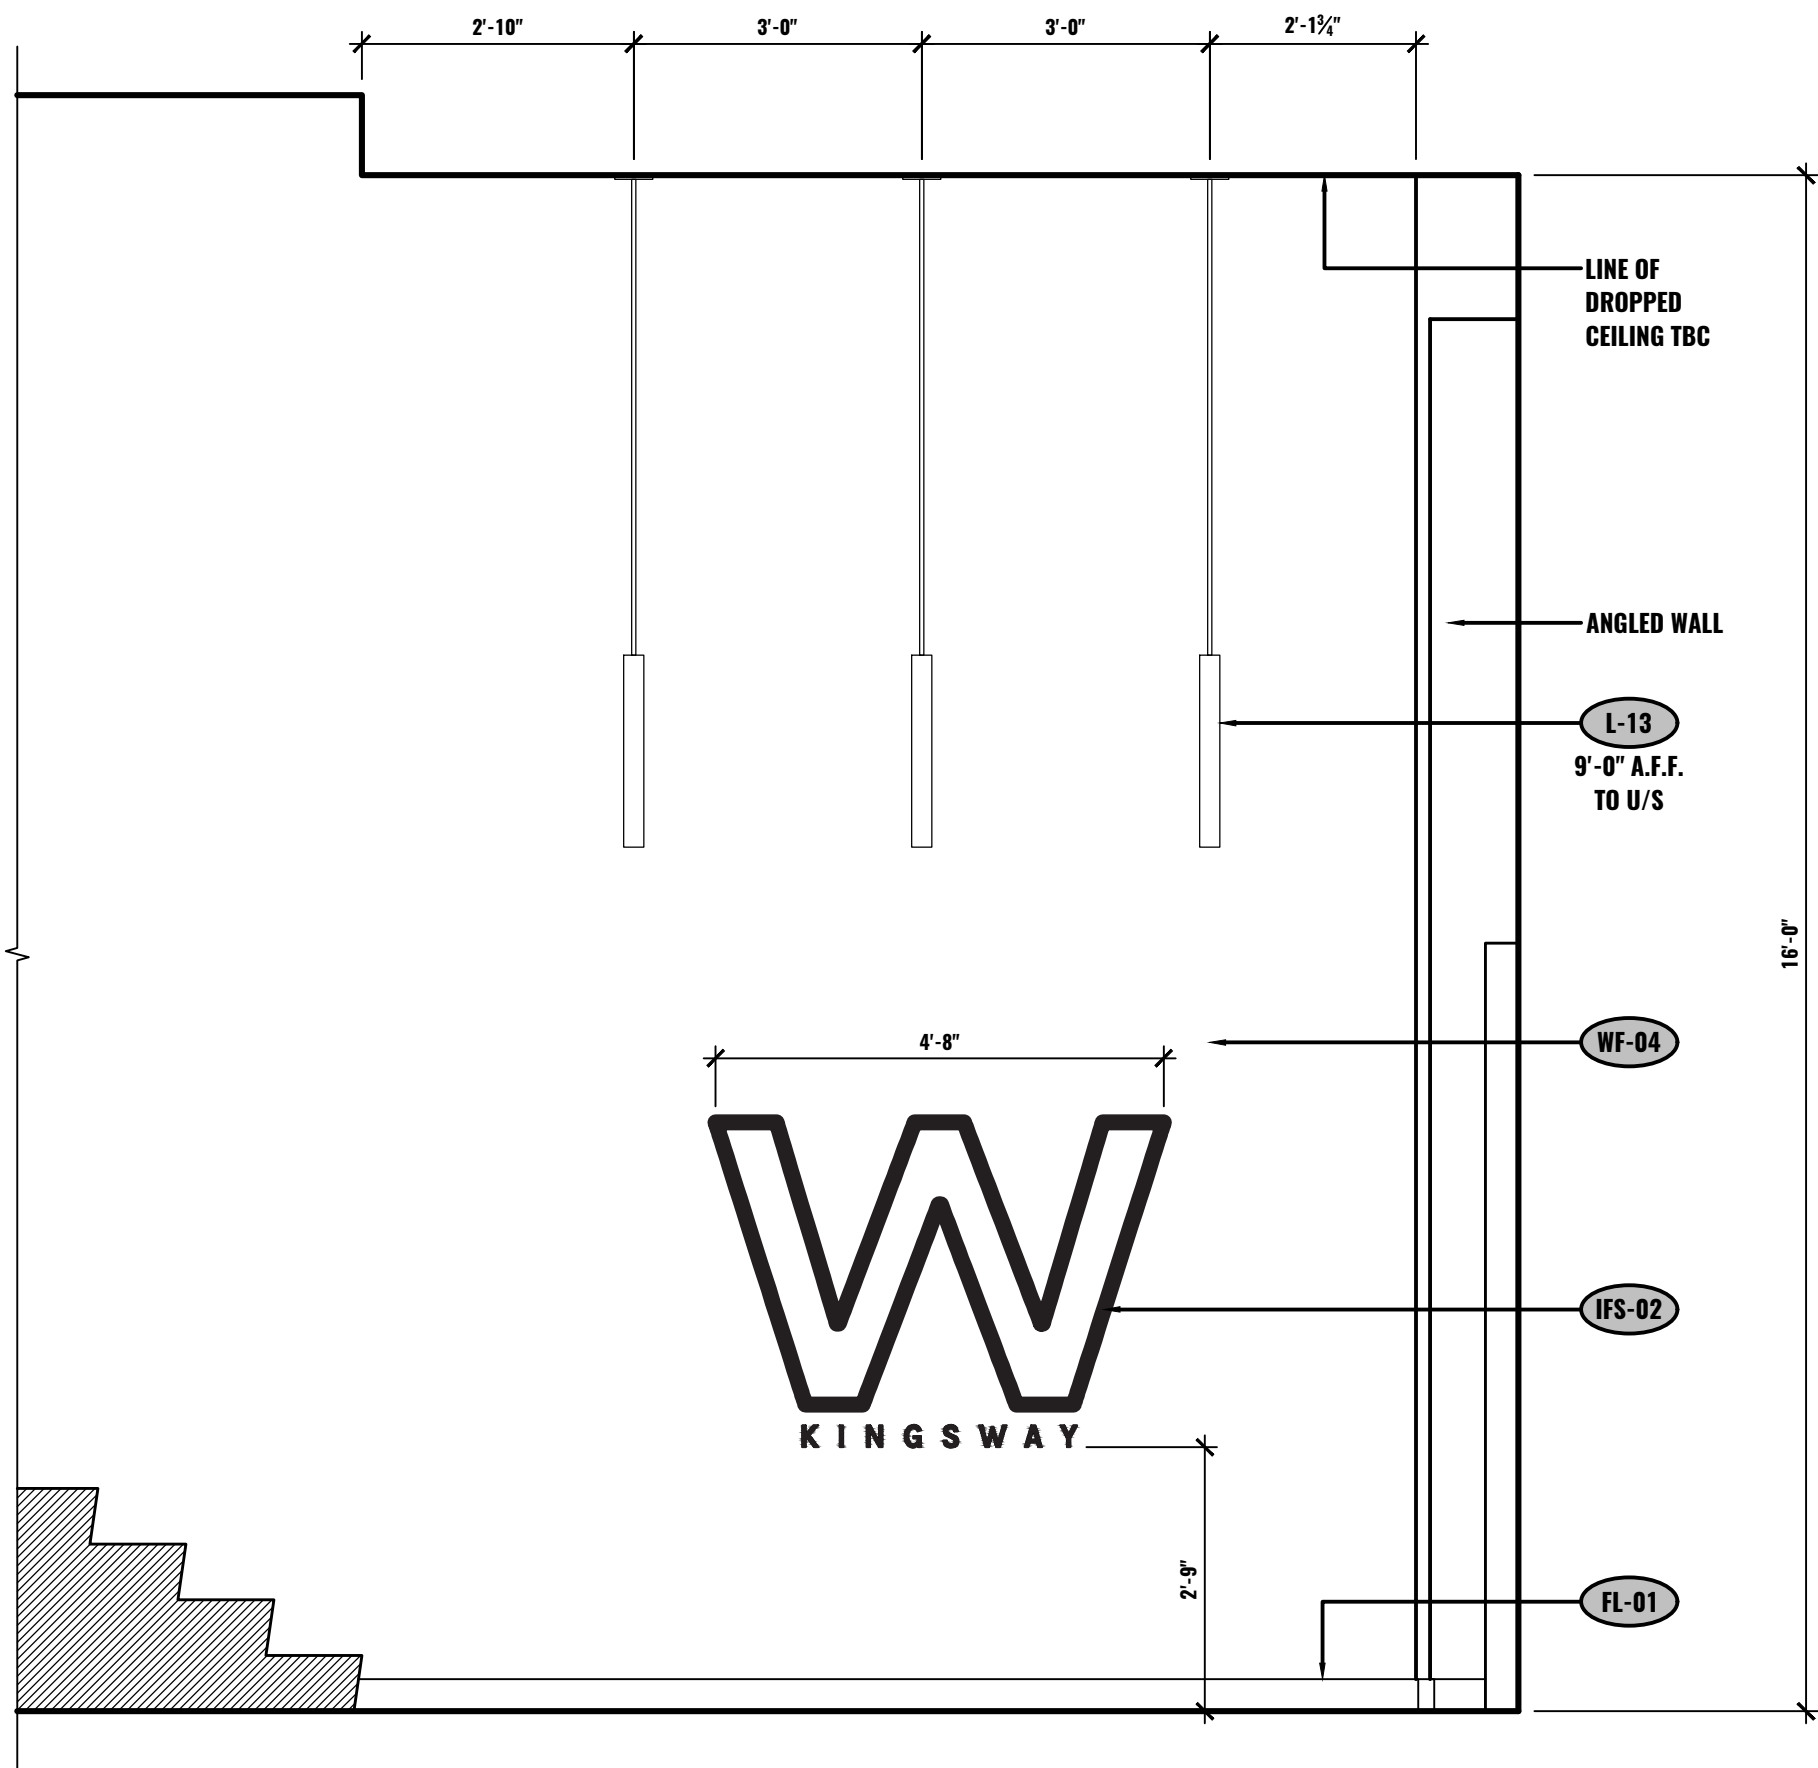


C ELEVATION - STAIR #5 LOBBY
LEVEL 1
1/2"=1'-0"

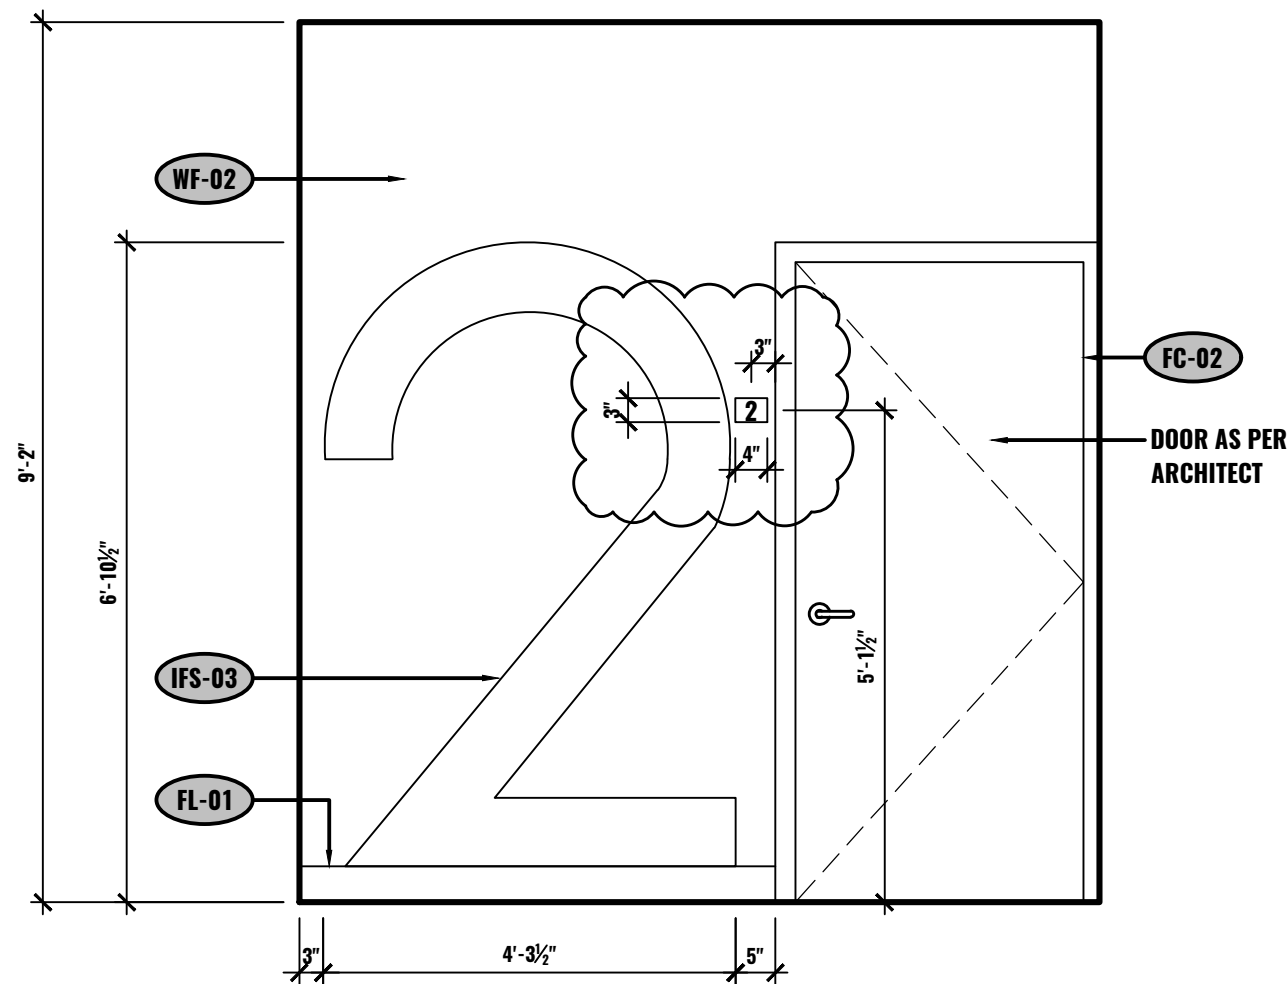


D ELEVATION - STAIRS #4 & STAIRS #5
ALL LEVELS
1/2"=1'-0"

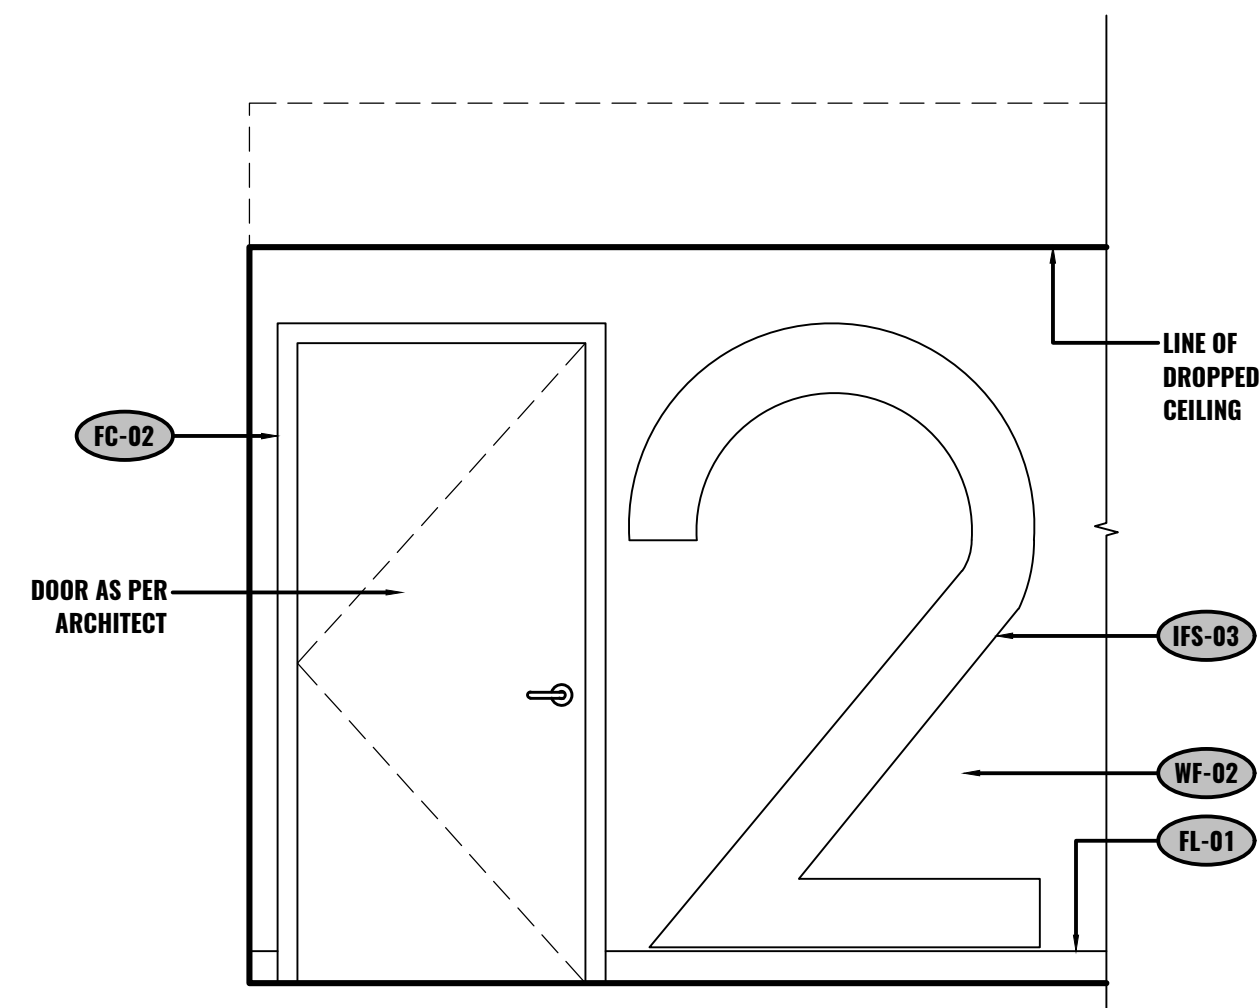


E ELEVATION - CORRIDOR STAIRWELL DOORS
ALL LEVELS
1/2"=1'-0"

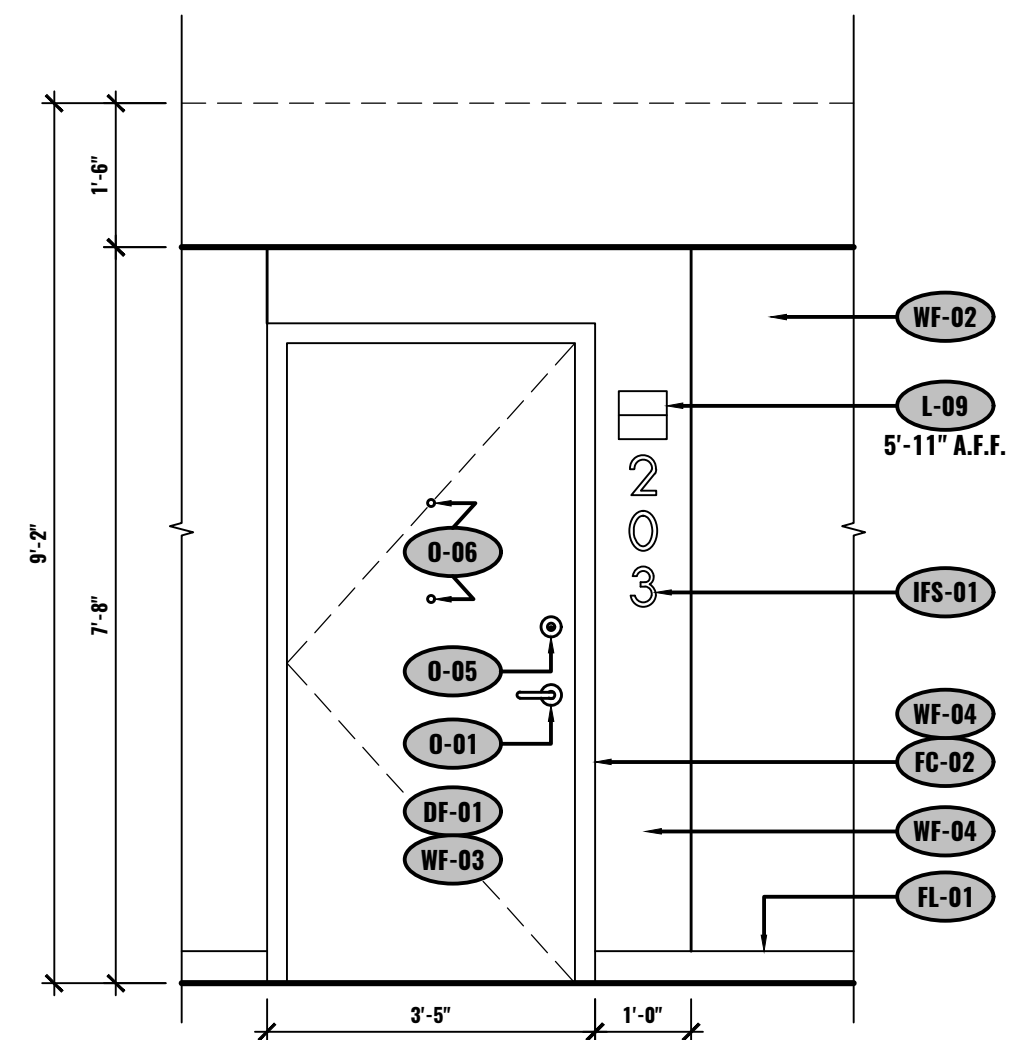


F ELEVATION - SUITE ENTRY
ALL LEVELS
1/2"=1'-0"

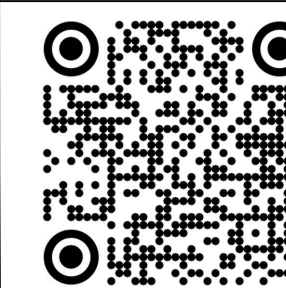


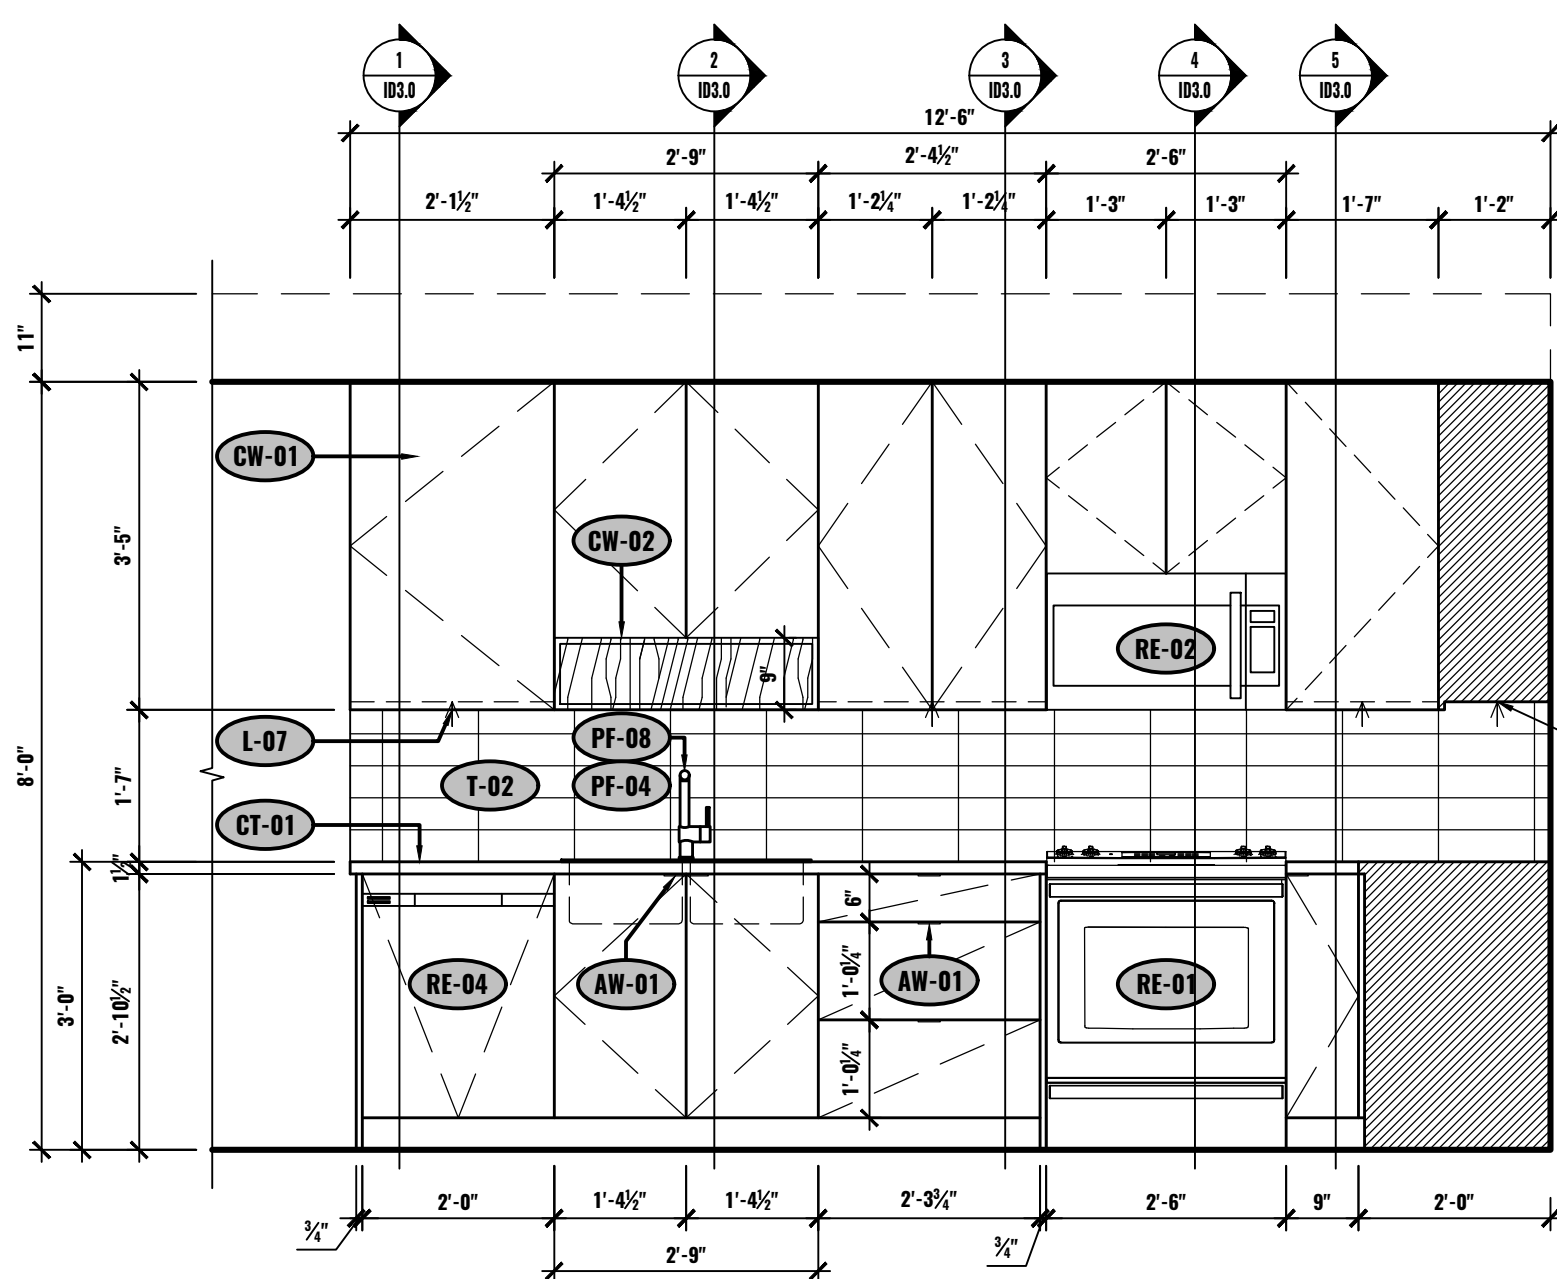


A ELEVATION - KITCHEN
UNIT #2-501
1/2"=1'-0"

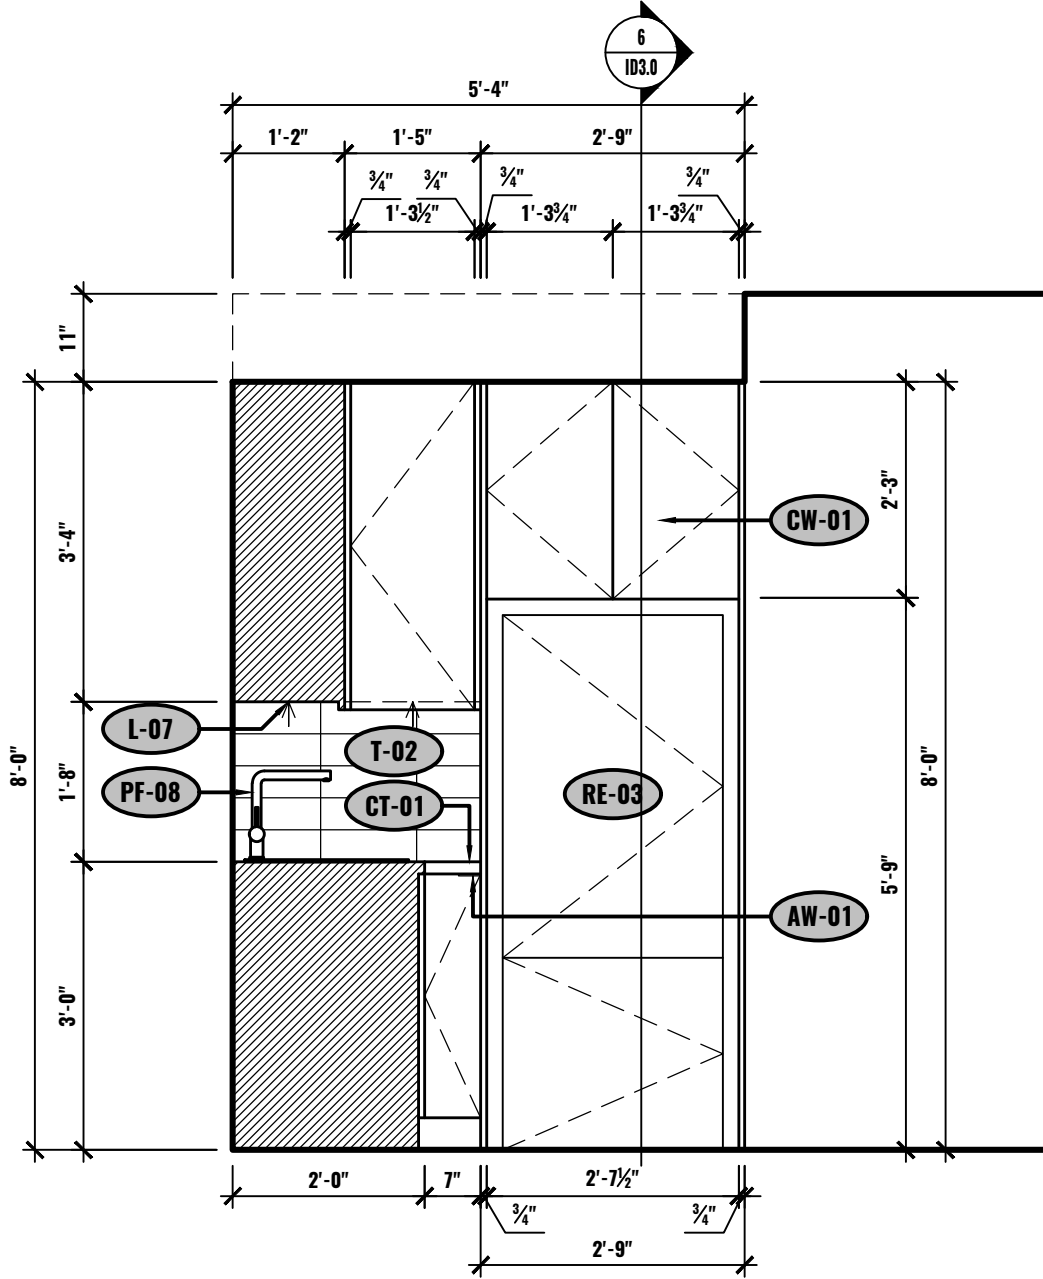


B ELEVATION - KITCHEN
UNIT #2-501
1/2"=1'-0"

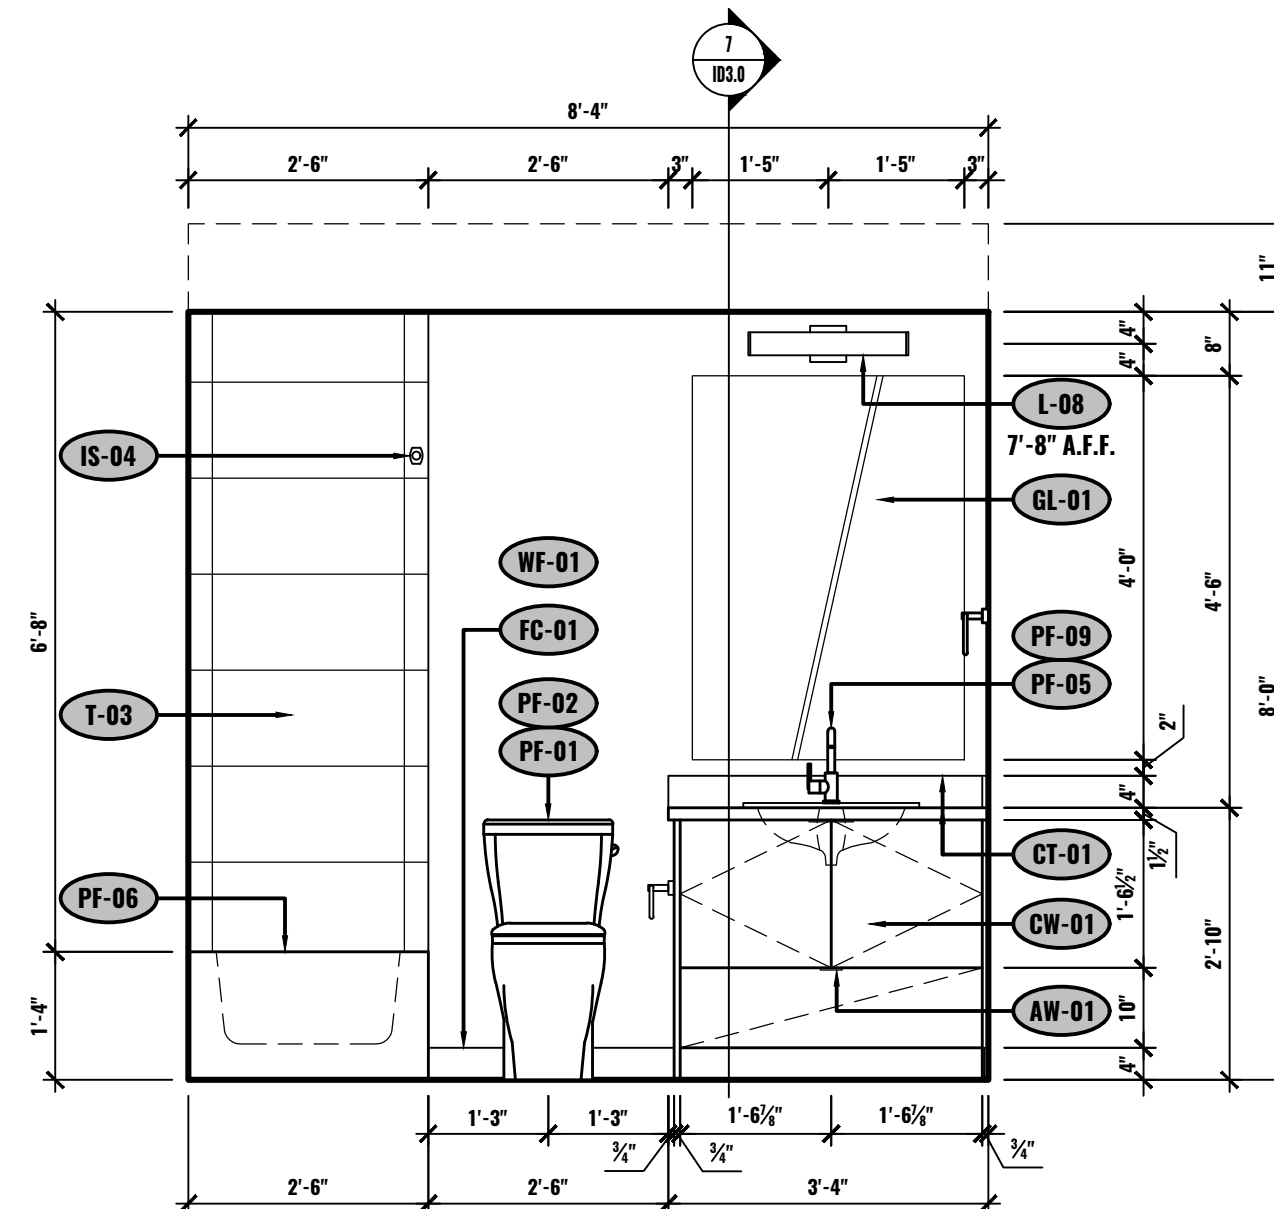


C ELEVATION - BATHROOM
UNIT #2-501
1/2"=1'-0"

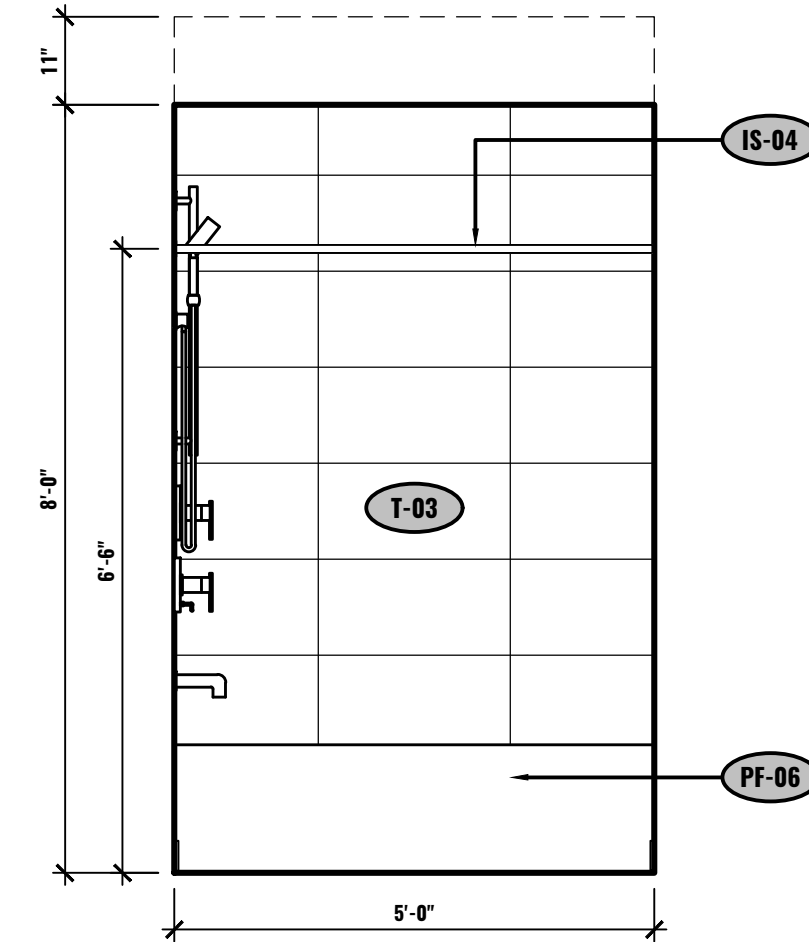


D ELEVATION - BATHROOM
UNIT #2-501
1/2"=1'-0"

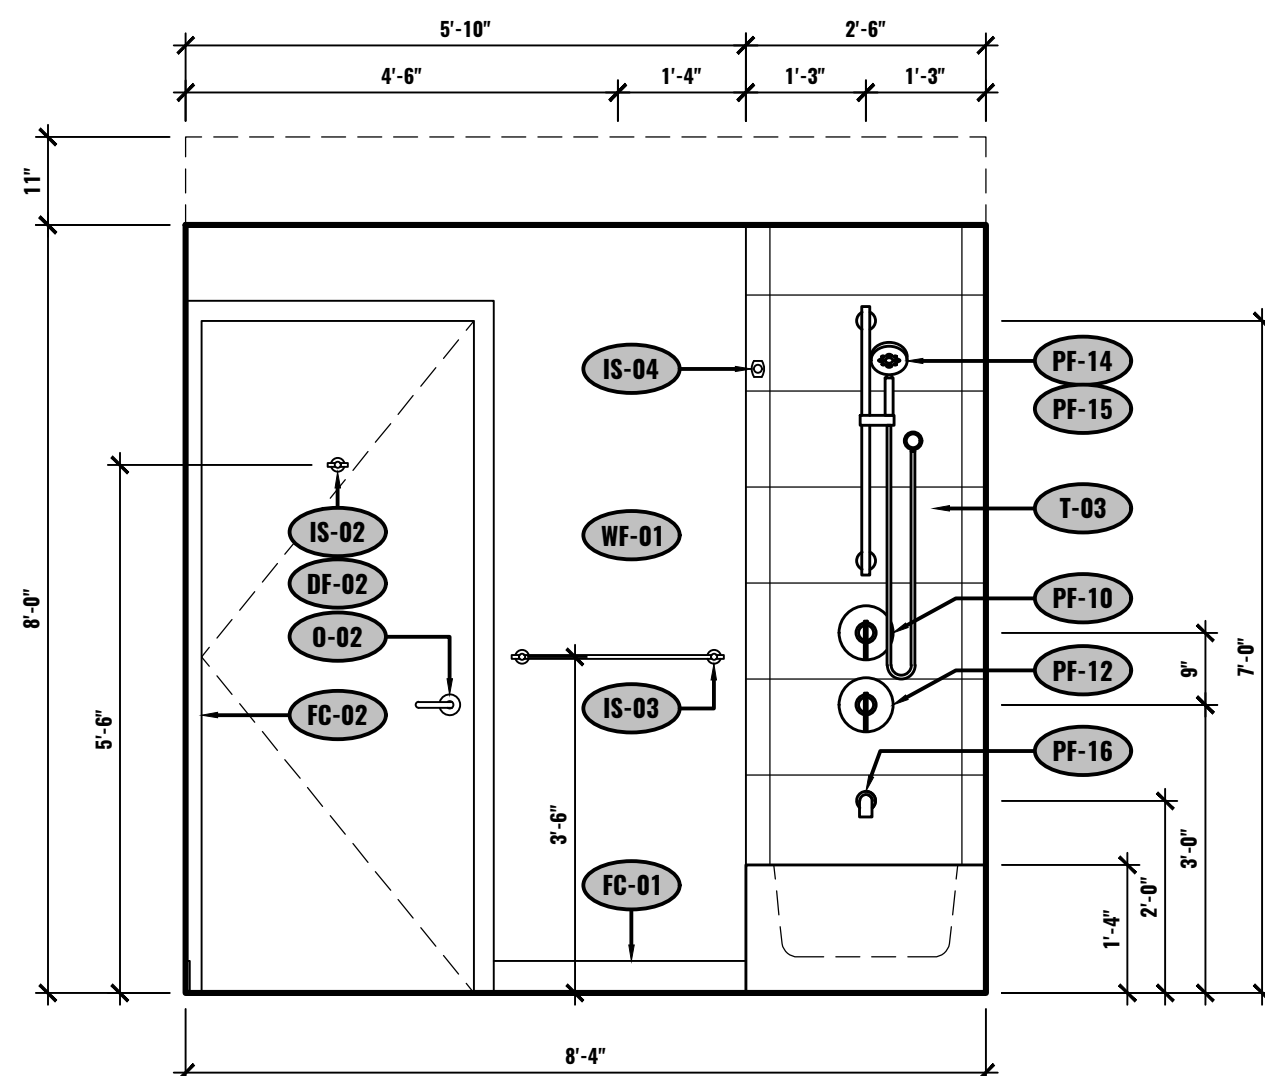


E ELEVATION - BATHROOM
UNIT #2-501
1/2"=1'-0"

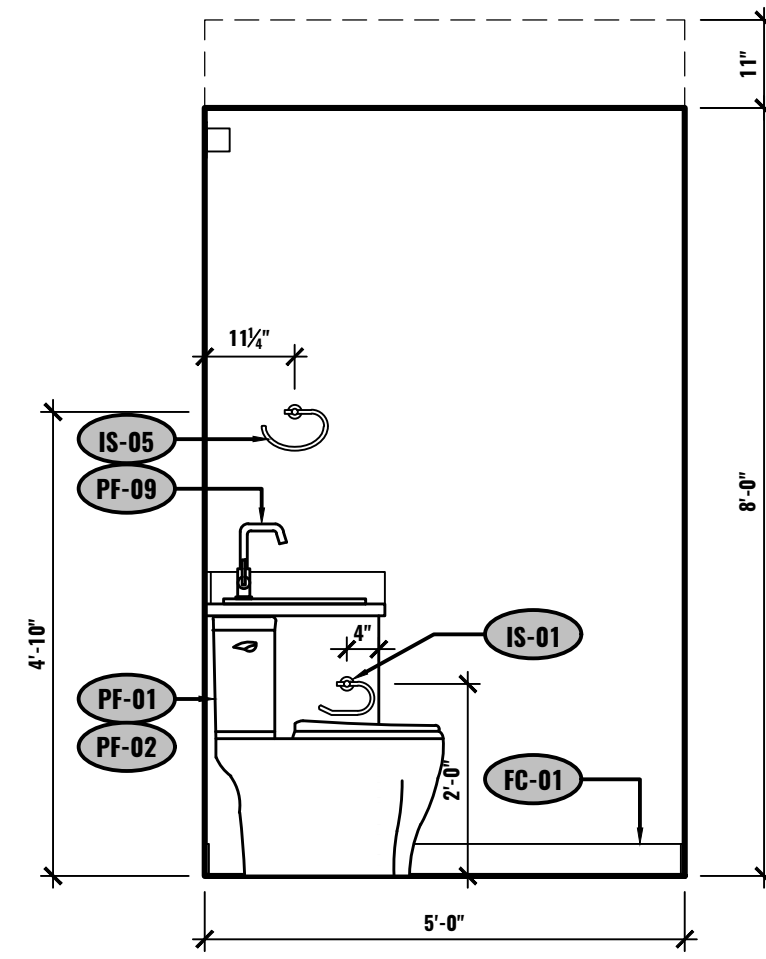


F ELEVATION - BATHROOM
UNIT #2-501
1/2"=1'-0"

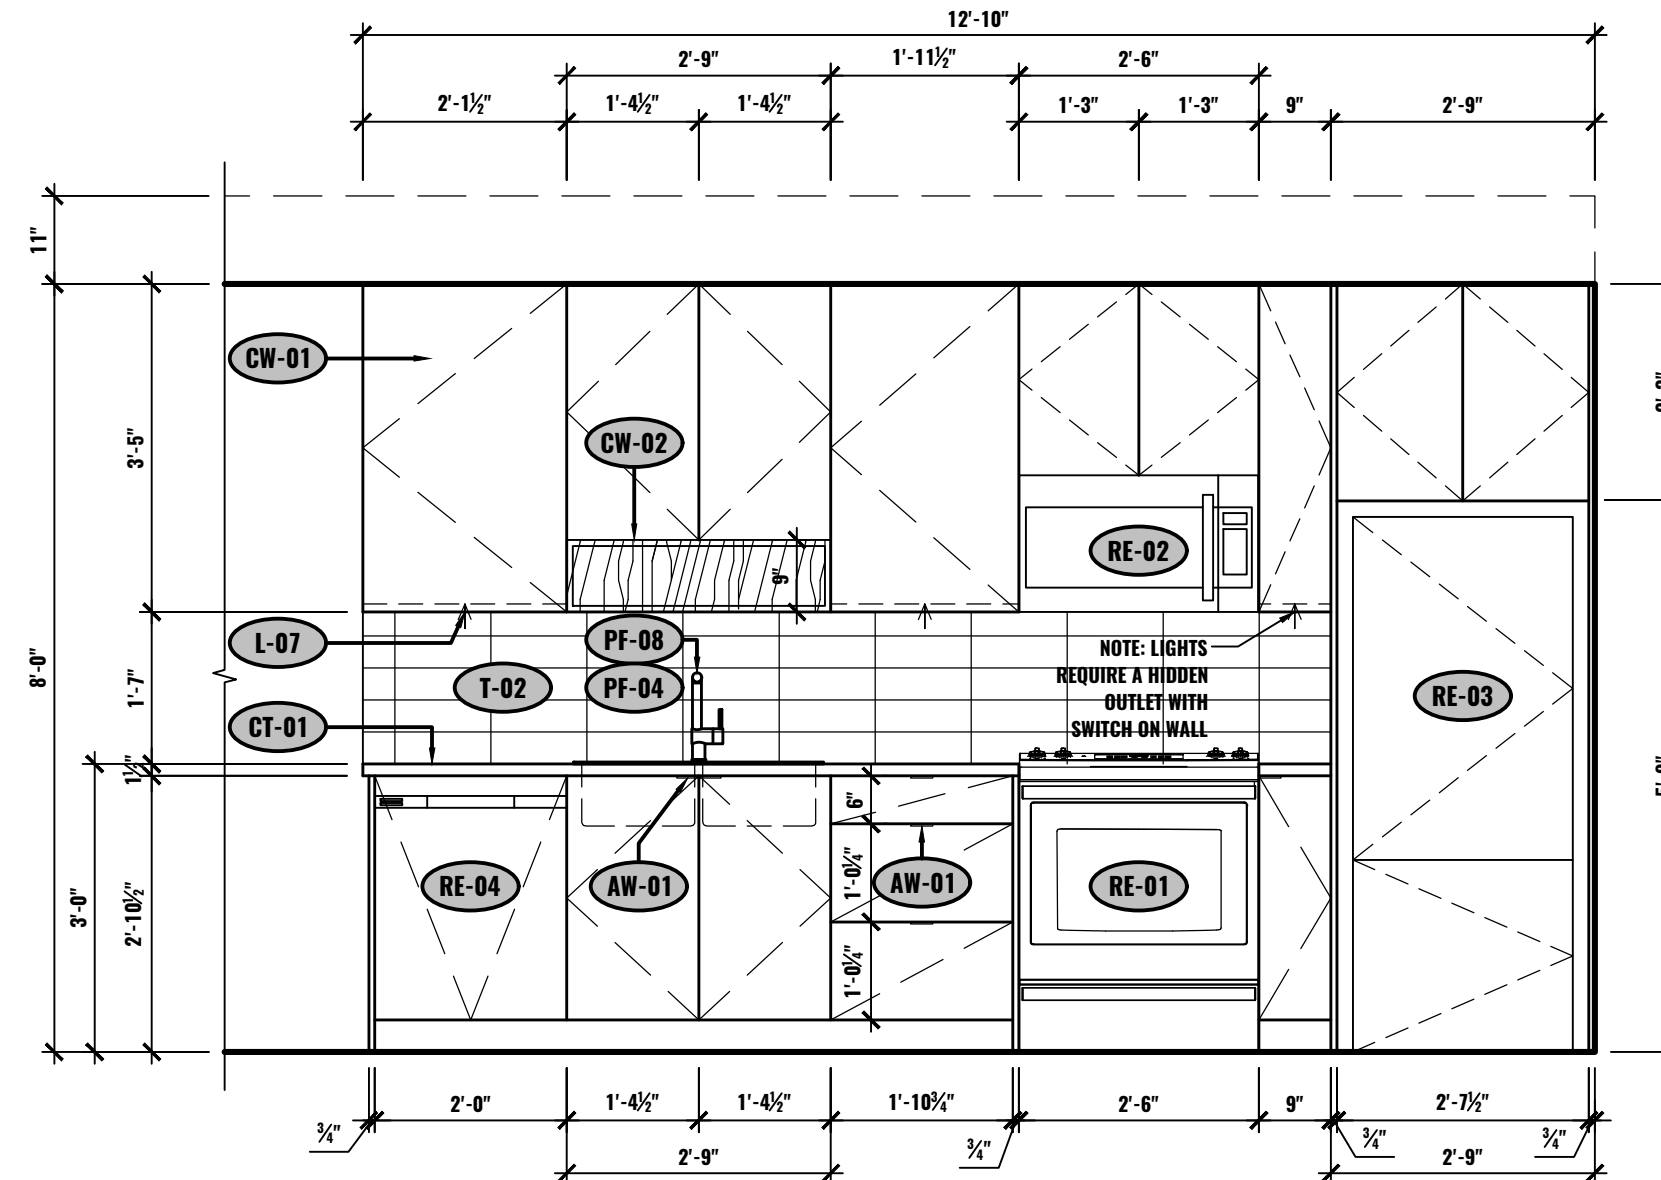


G ELEVATION - KITCHEN
UNIT #2-502
1/2"=1'-0"

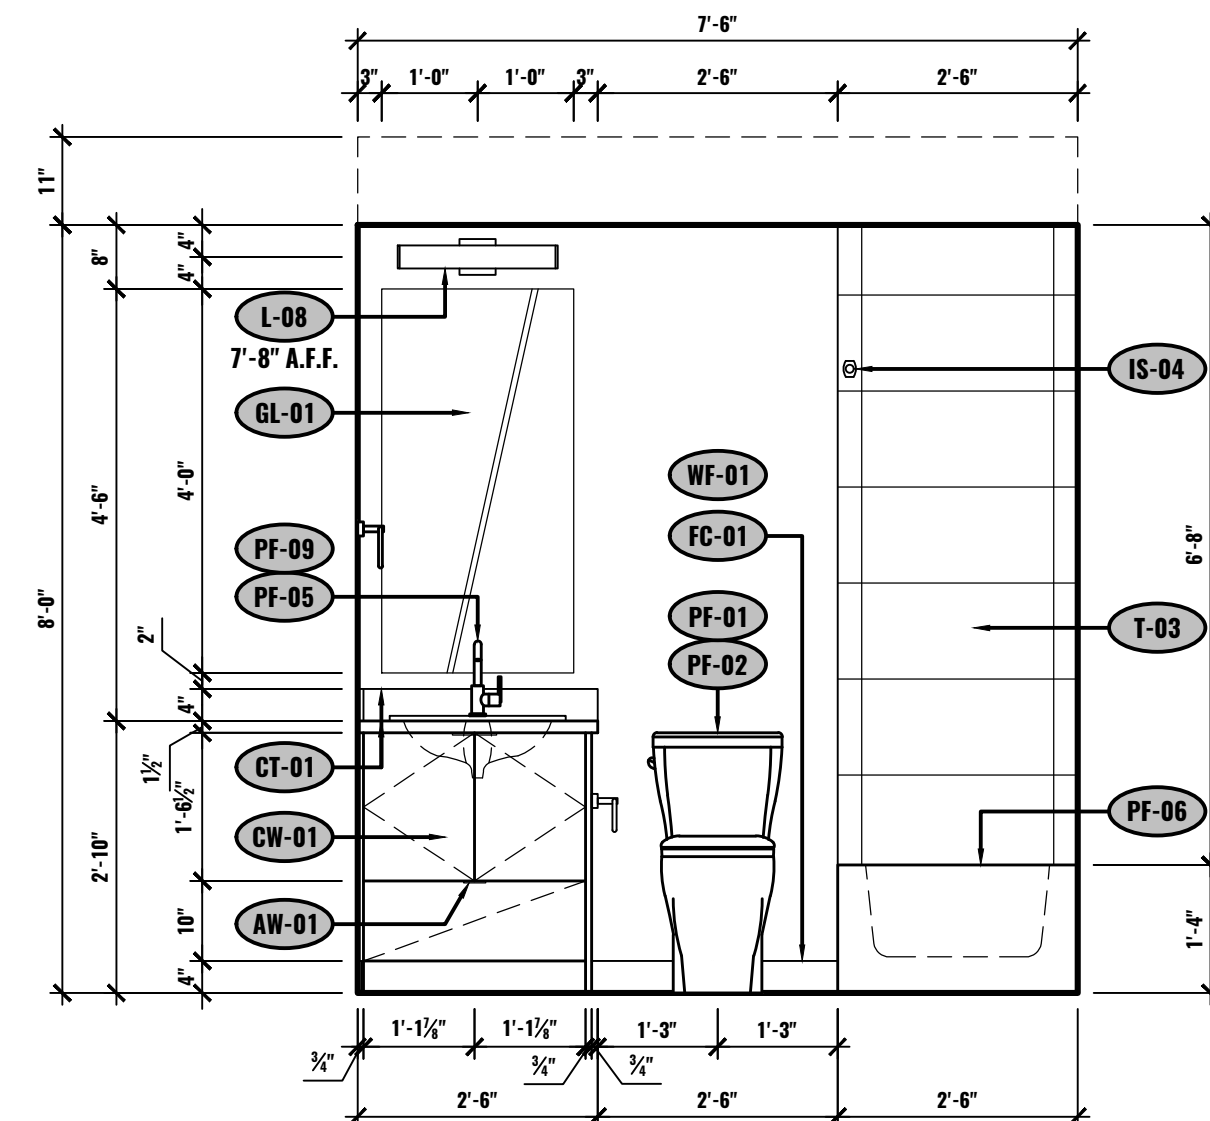


H ELEVATION - BATHROOM
UNIT #2-502
1/2"=1'-0"

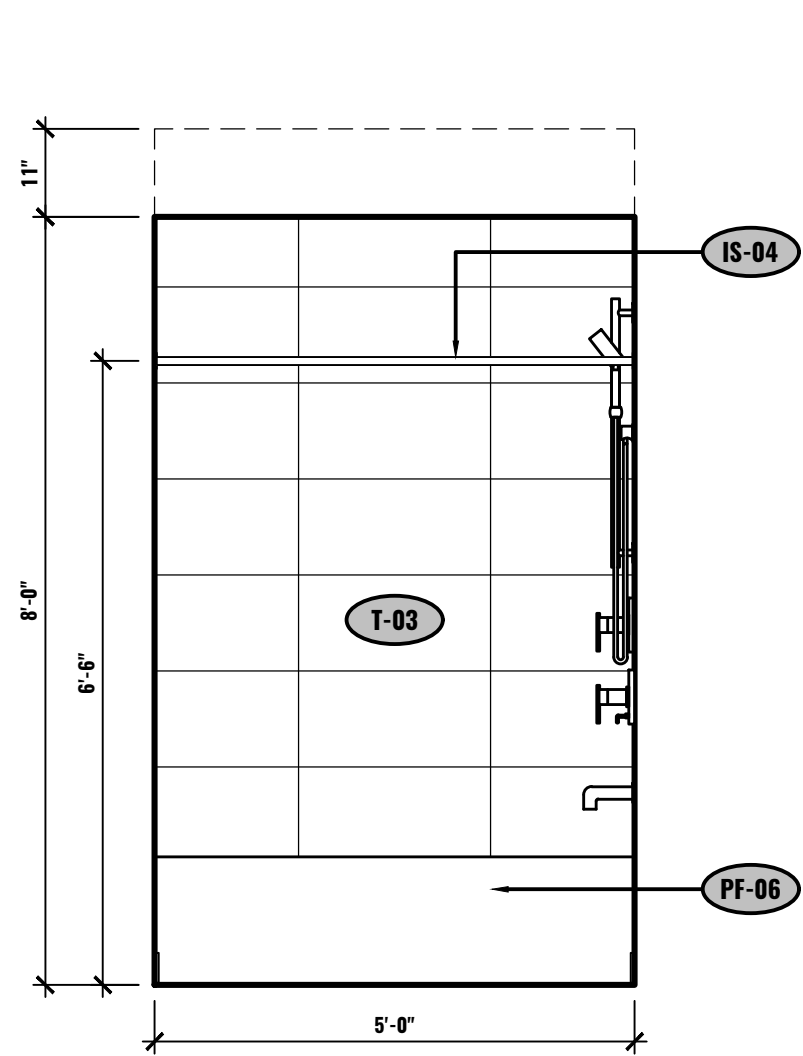


I ELEVATION - BATHROOM
UNIT #2-502
1/2"=1'-0"

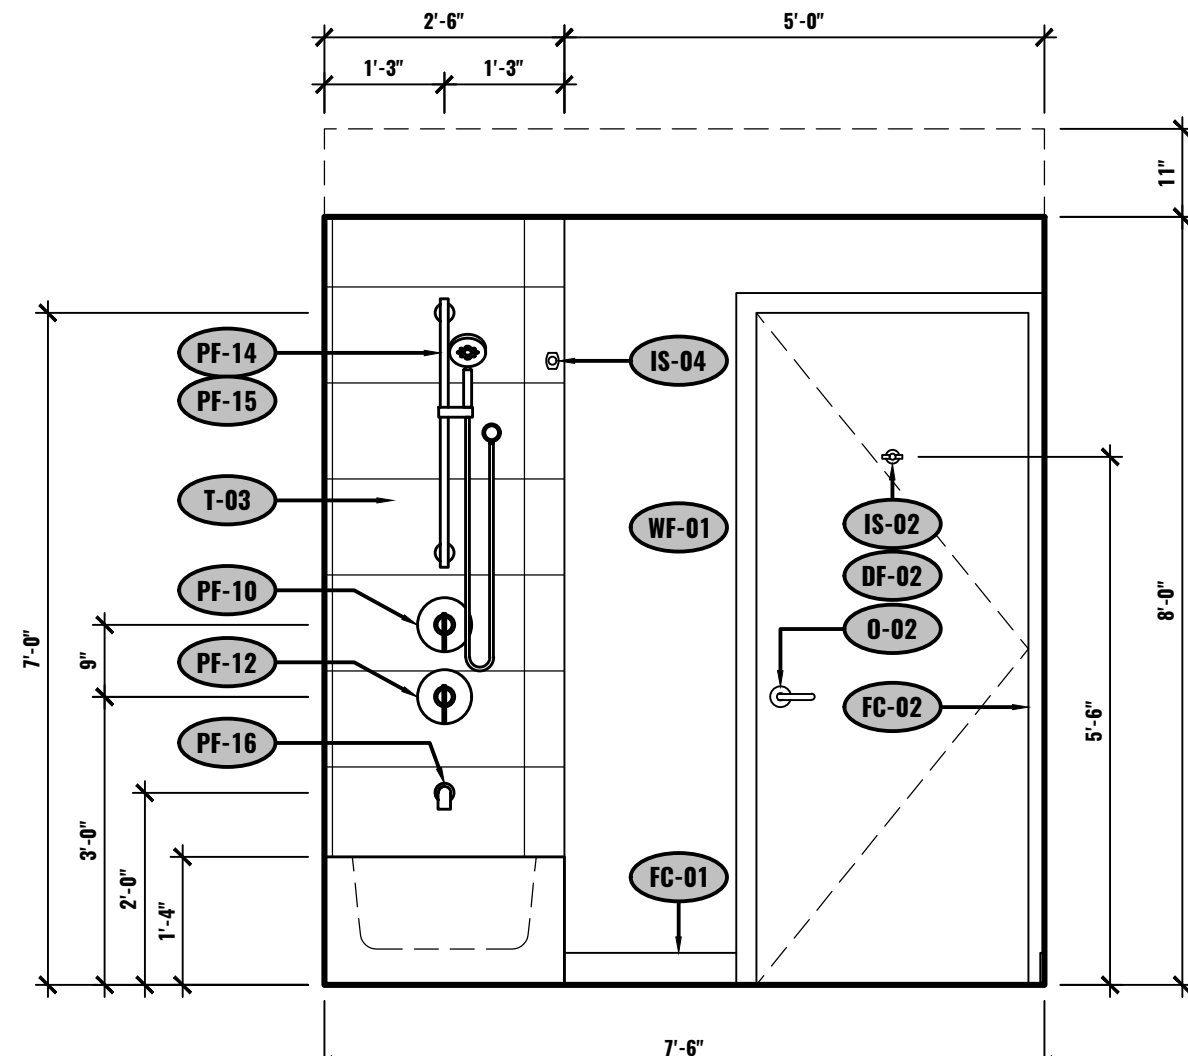


J ELEVATION - BATHROOM
UNIT #2-502
1/2"=1'-0"

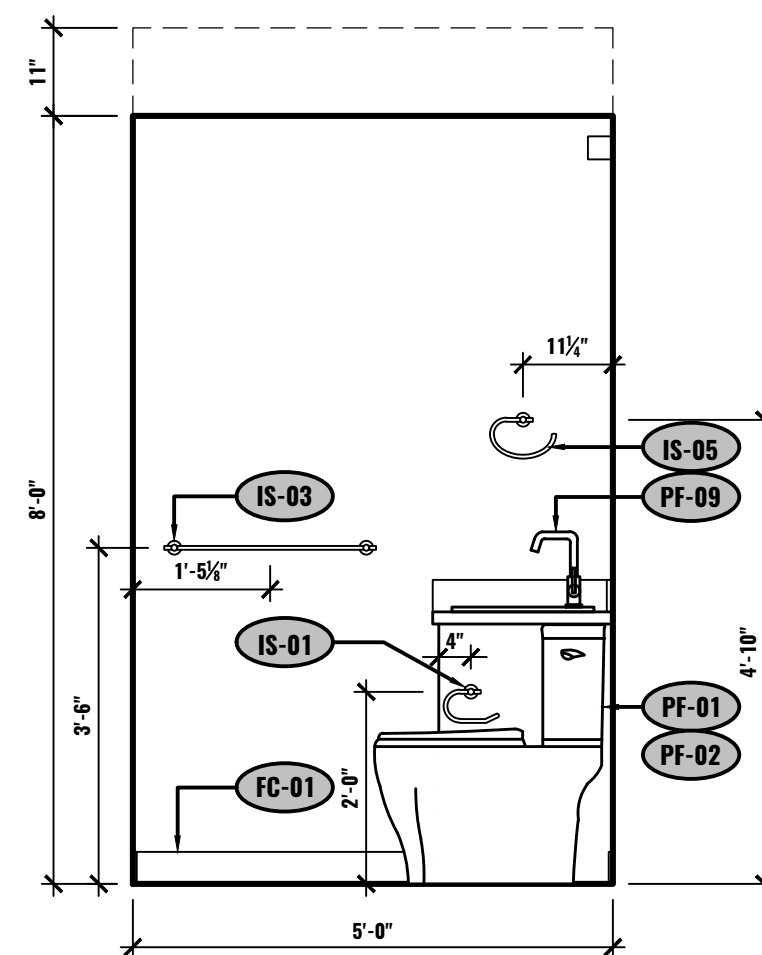


K ELEVATION - BATHROOM
UNIT #2-502
1/2"=1'-0"

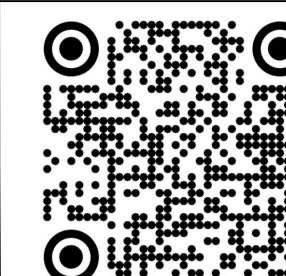


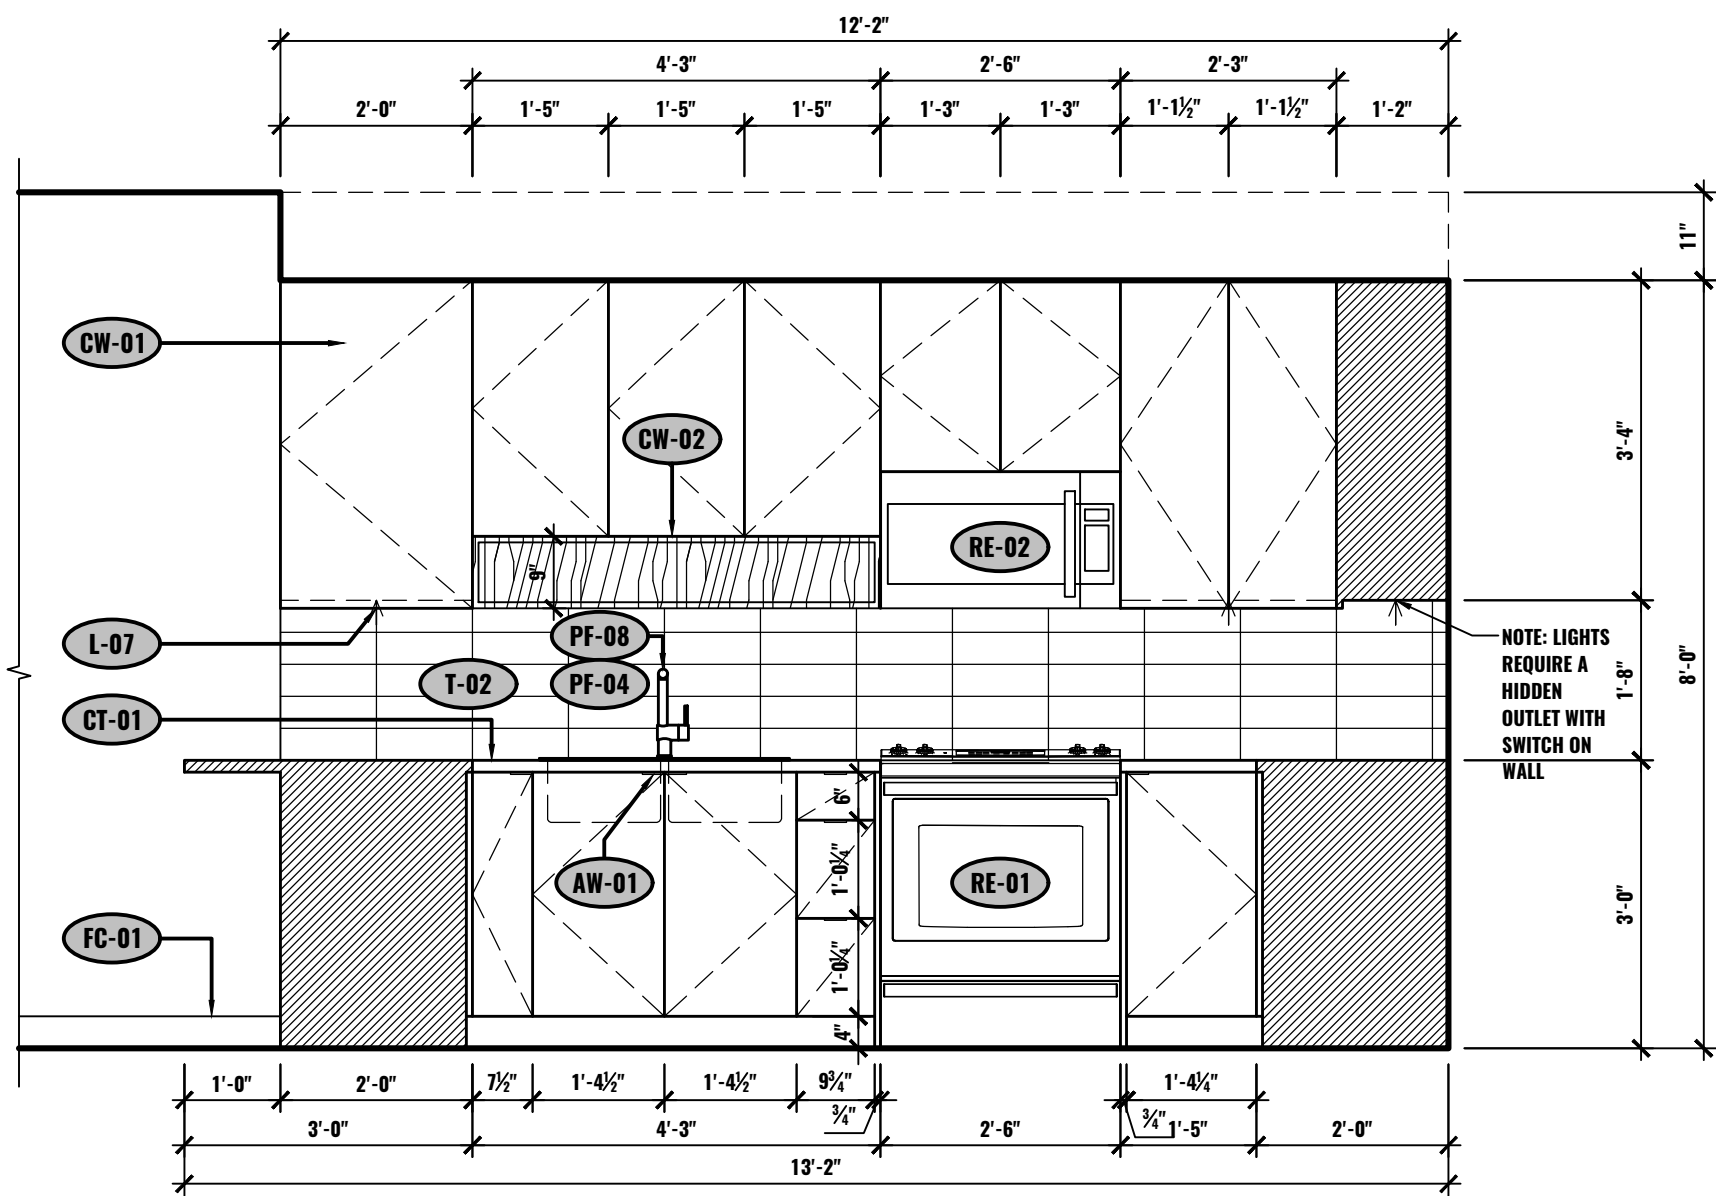


A ELEVATION - KITCHEN
UNIT #2-503
1/2"=1'-0"

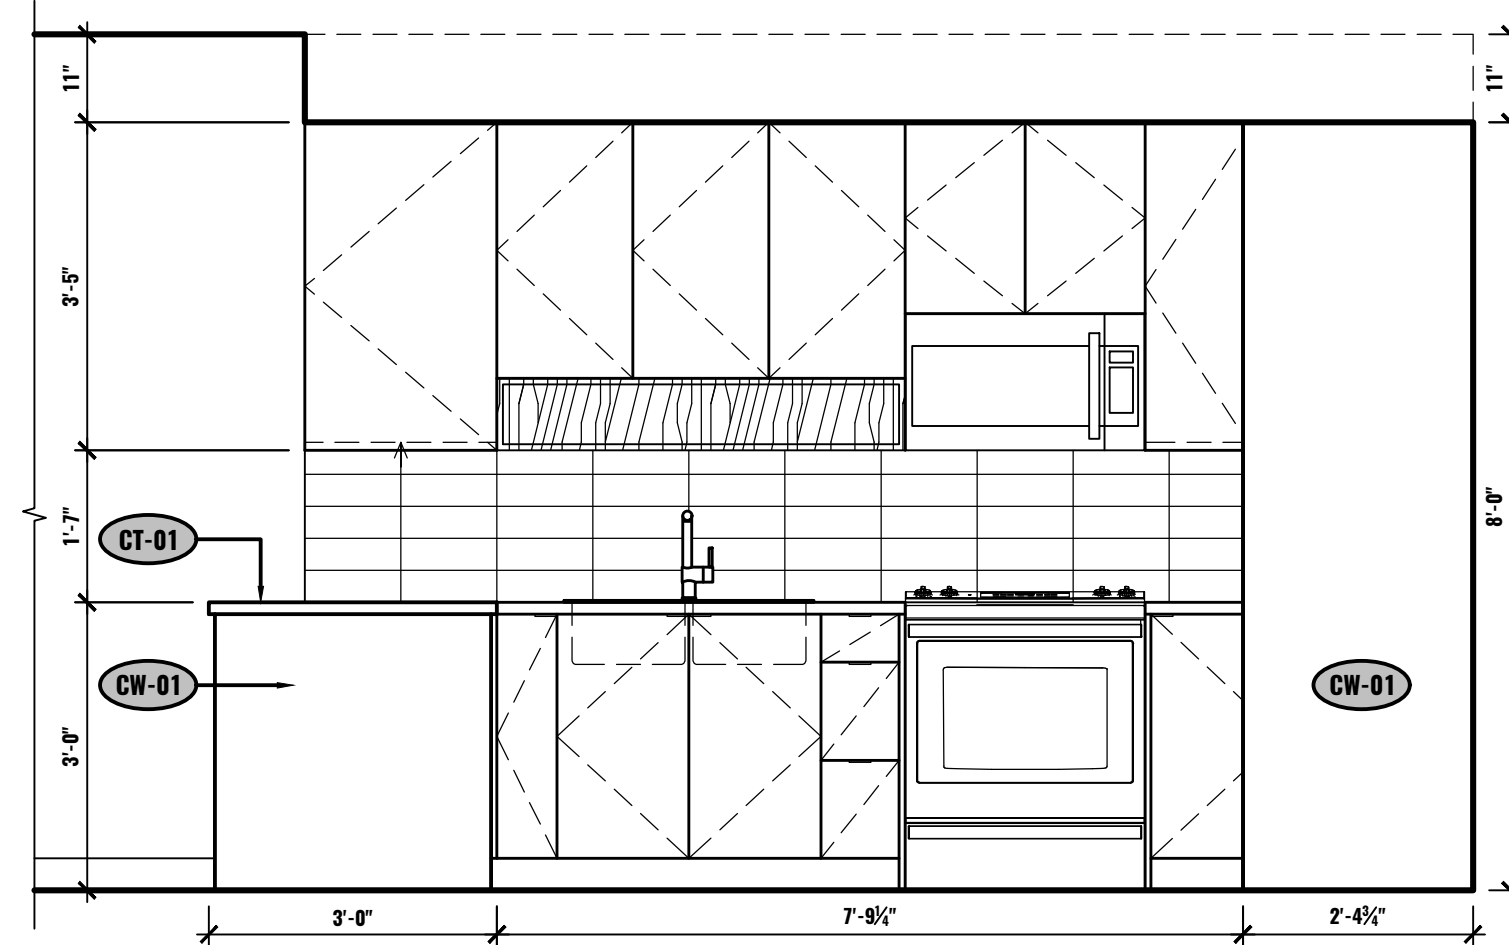


B ELEVATION - KITCHEN
UNIT #2-503
1/2"=1'-0"

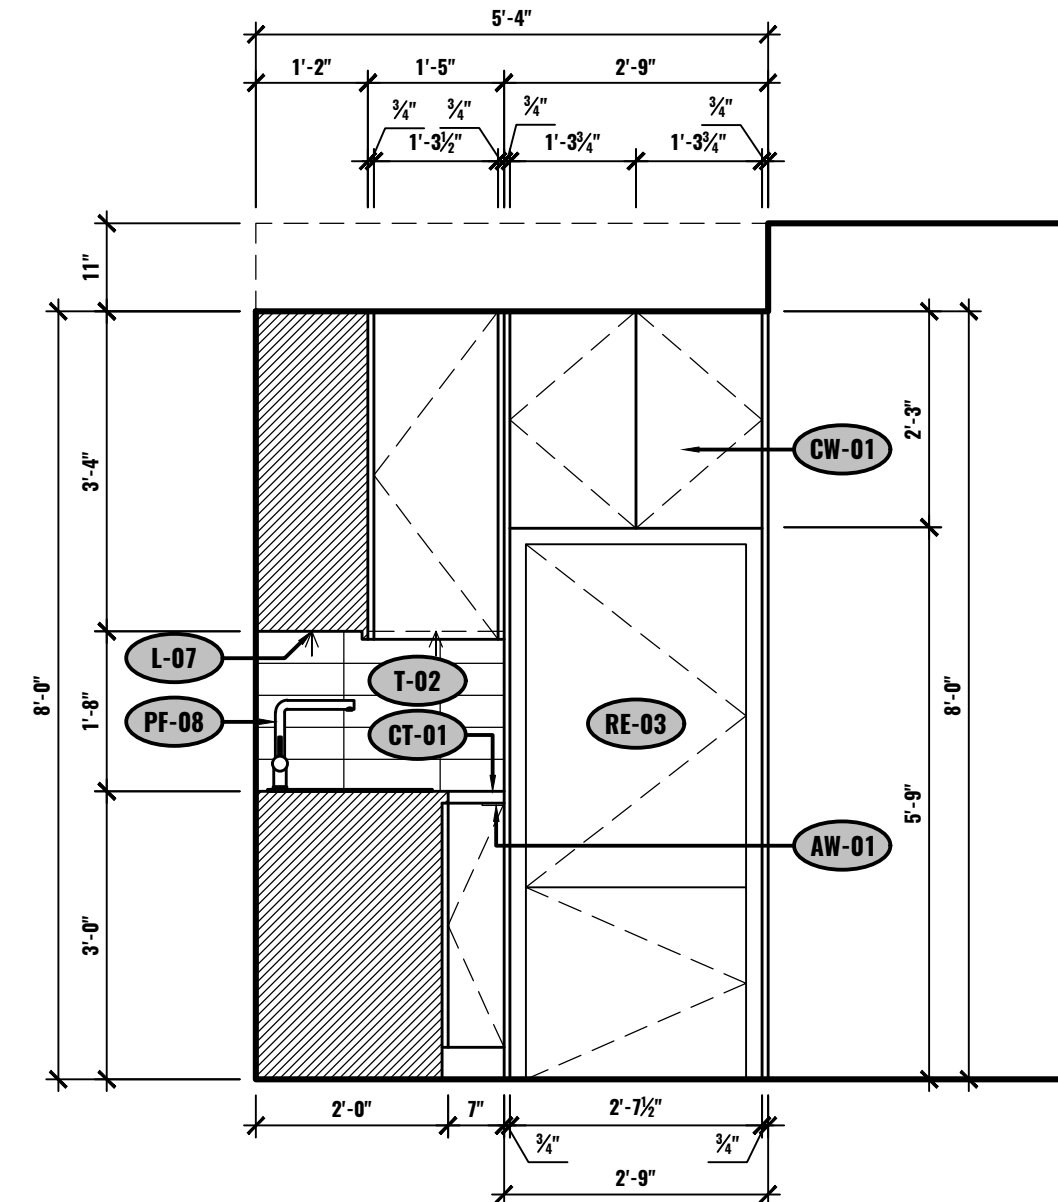


C ELEVATION - KITCHEN
UNIT #2-503
1/2"=1'-0"

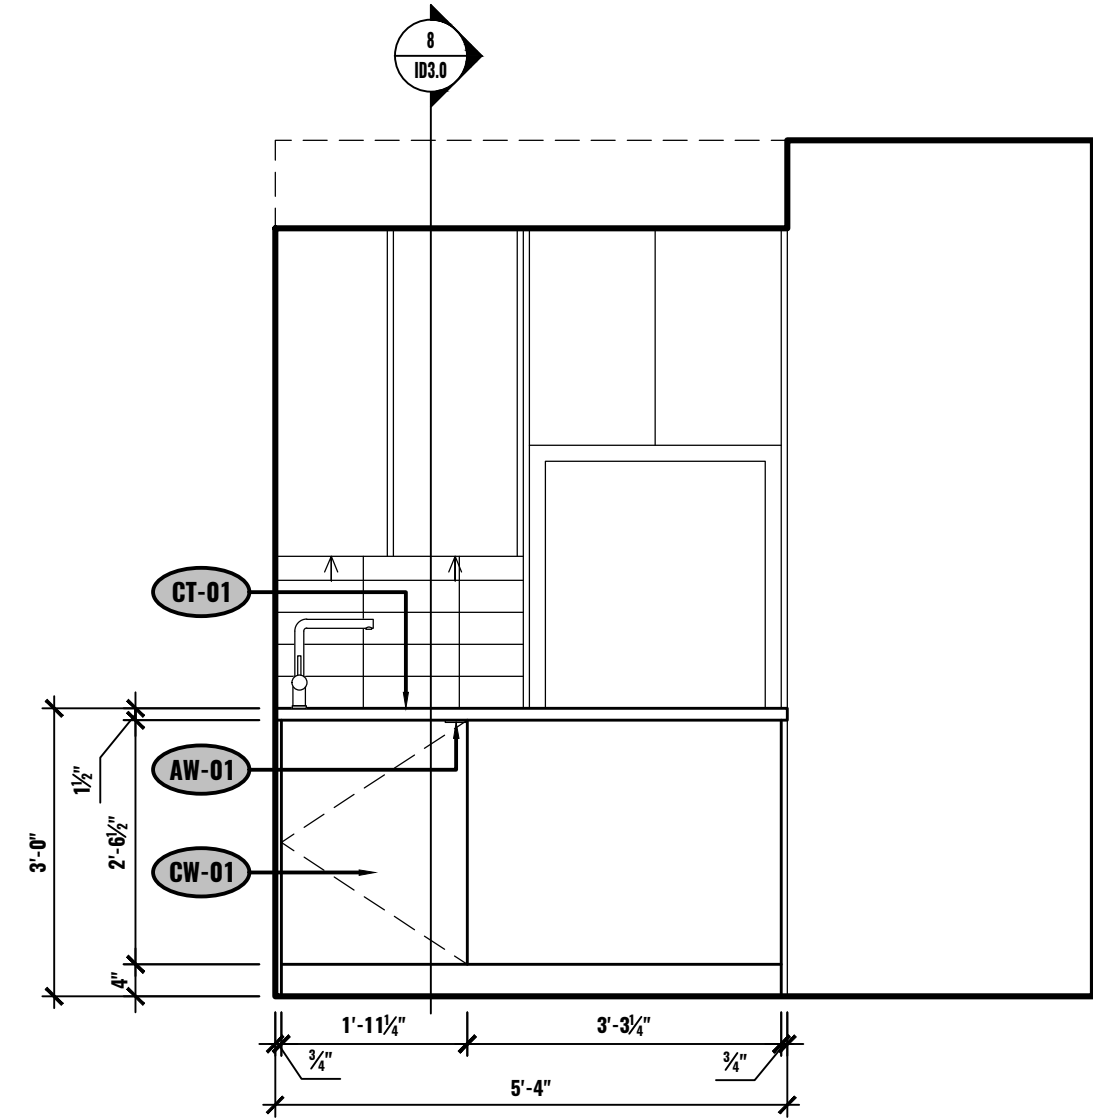


D ELEVATION - KITCHEN
UNIT #2-503
1/2"=1'-0"

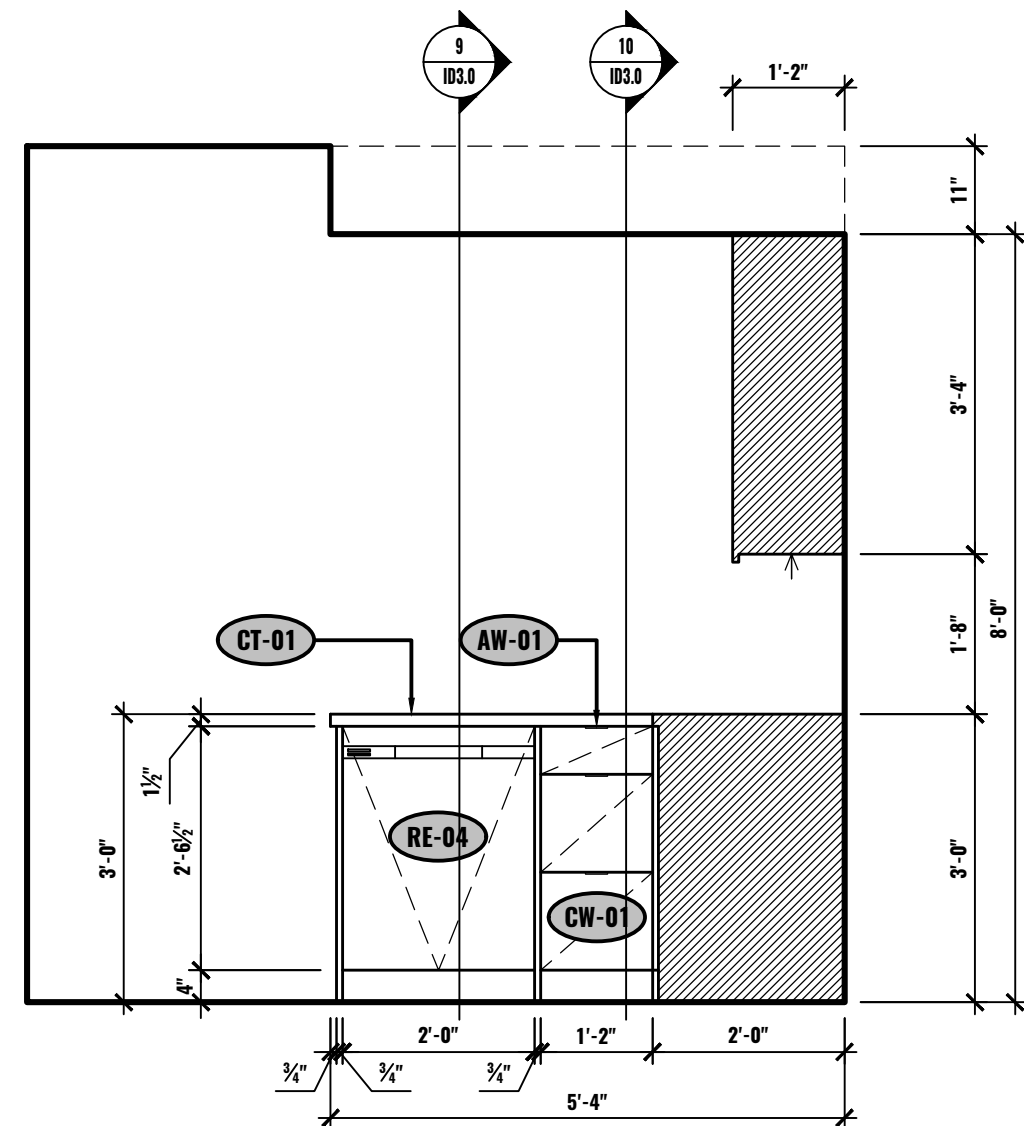


E ELEVATION - KITCHEN
UNIT #2-503
1/2"=1'-0"

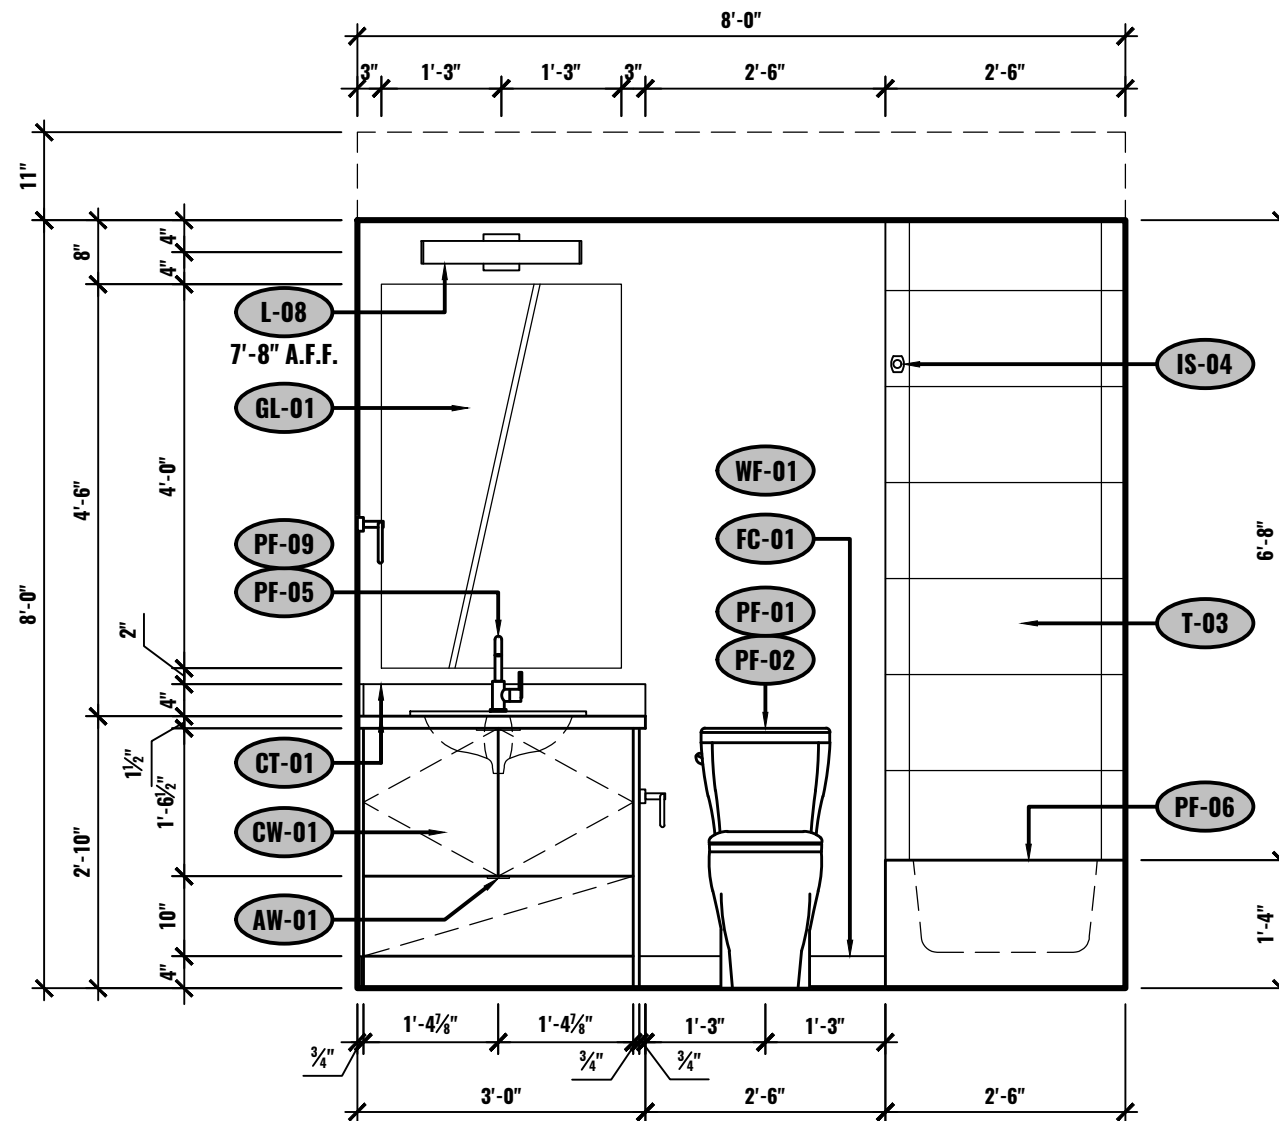


F ELEVATION - BATHROOM
UNIT #2-503
1/2"=1'-0"

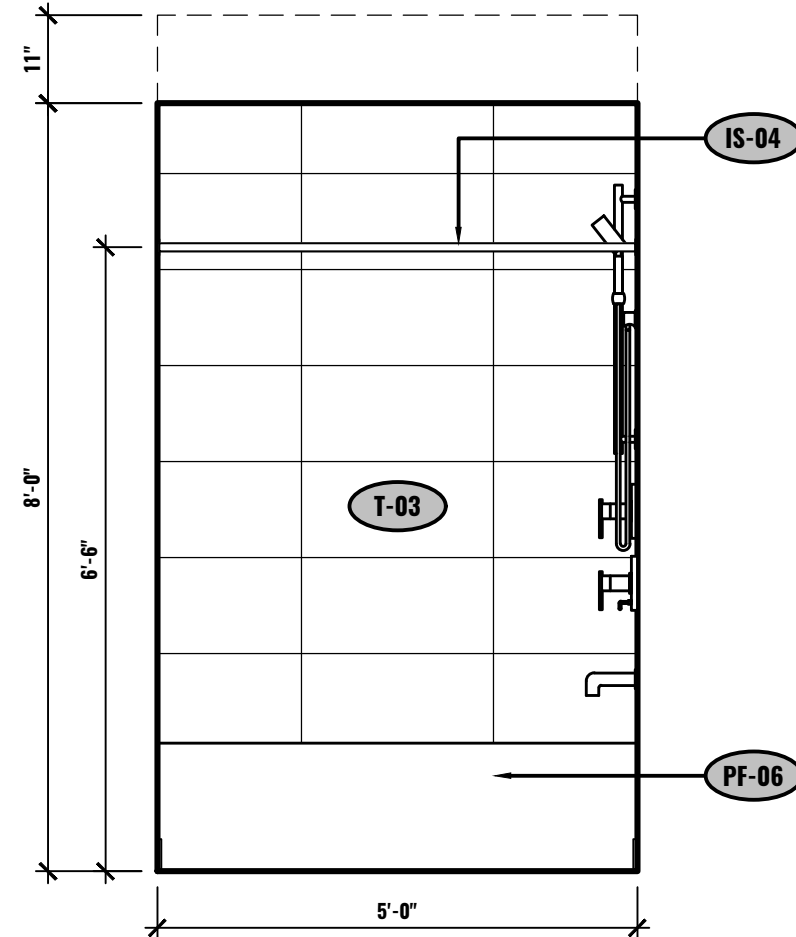


G ELEVATION - BATHROOM
UNIT #2-503
1/2"=1'-0"

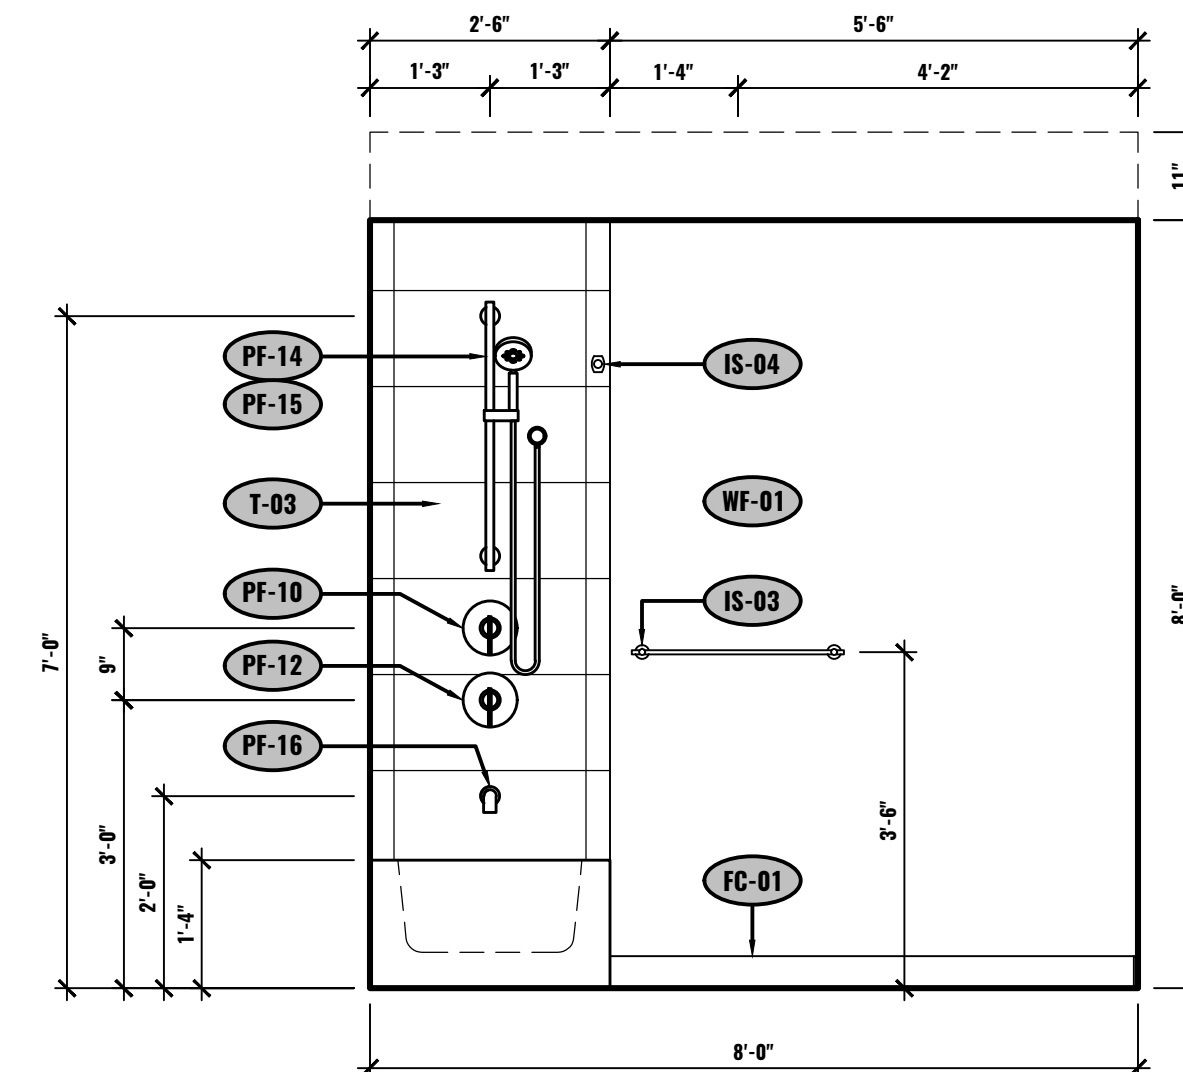


H ELEVATION - BATHROOM
UNIT #2-503
1/2"=1'-0"

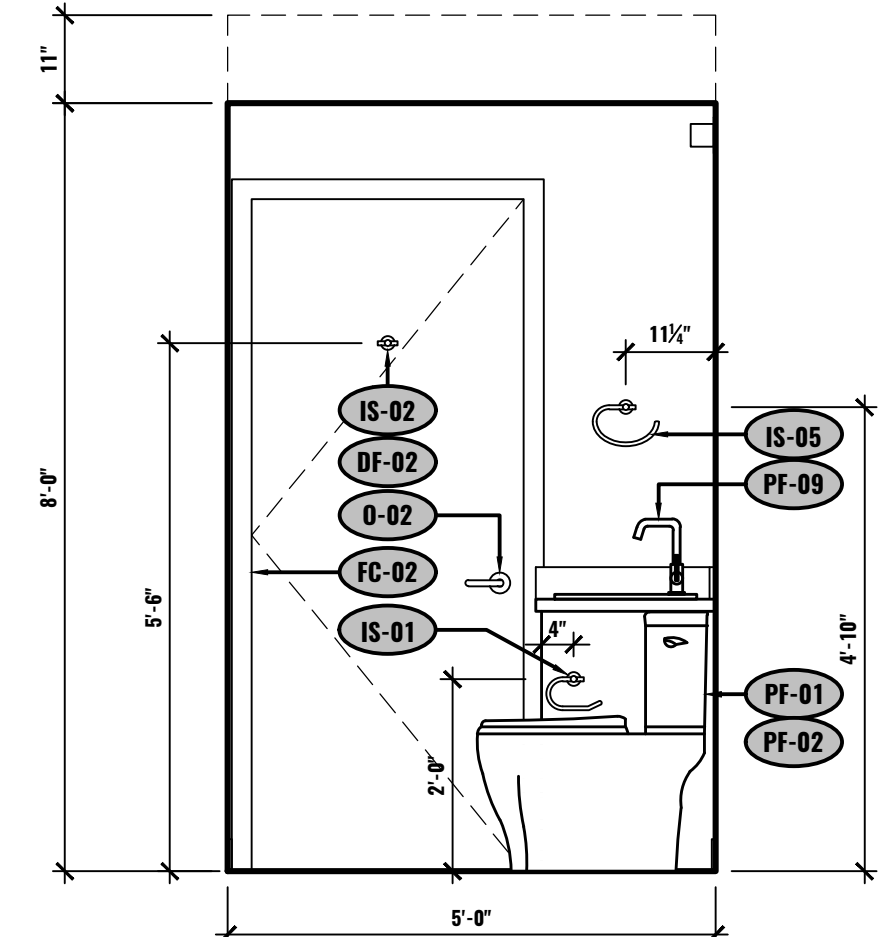


I ELEVATION - BATHROOM
UNIT #2-503
1/2"=1'-0"

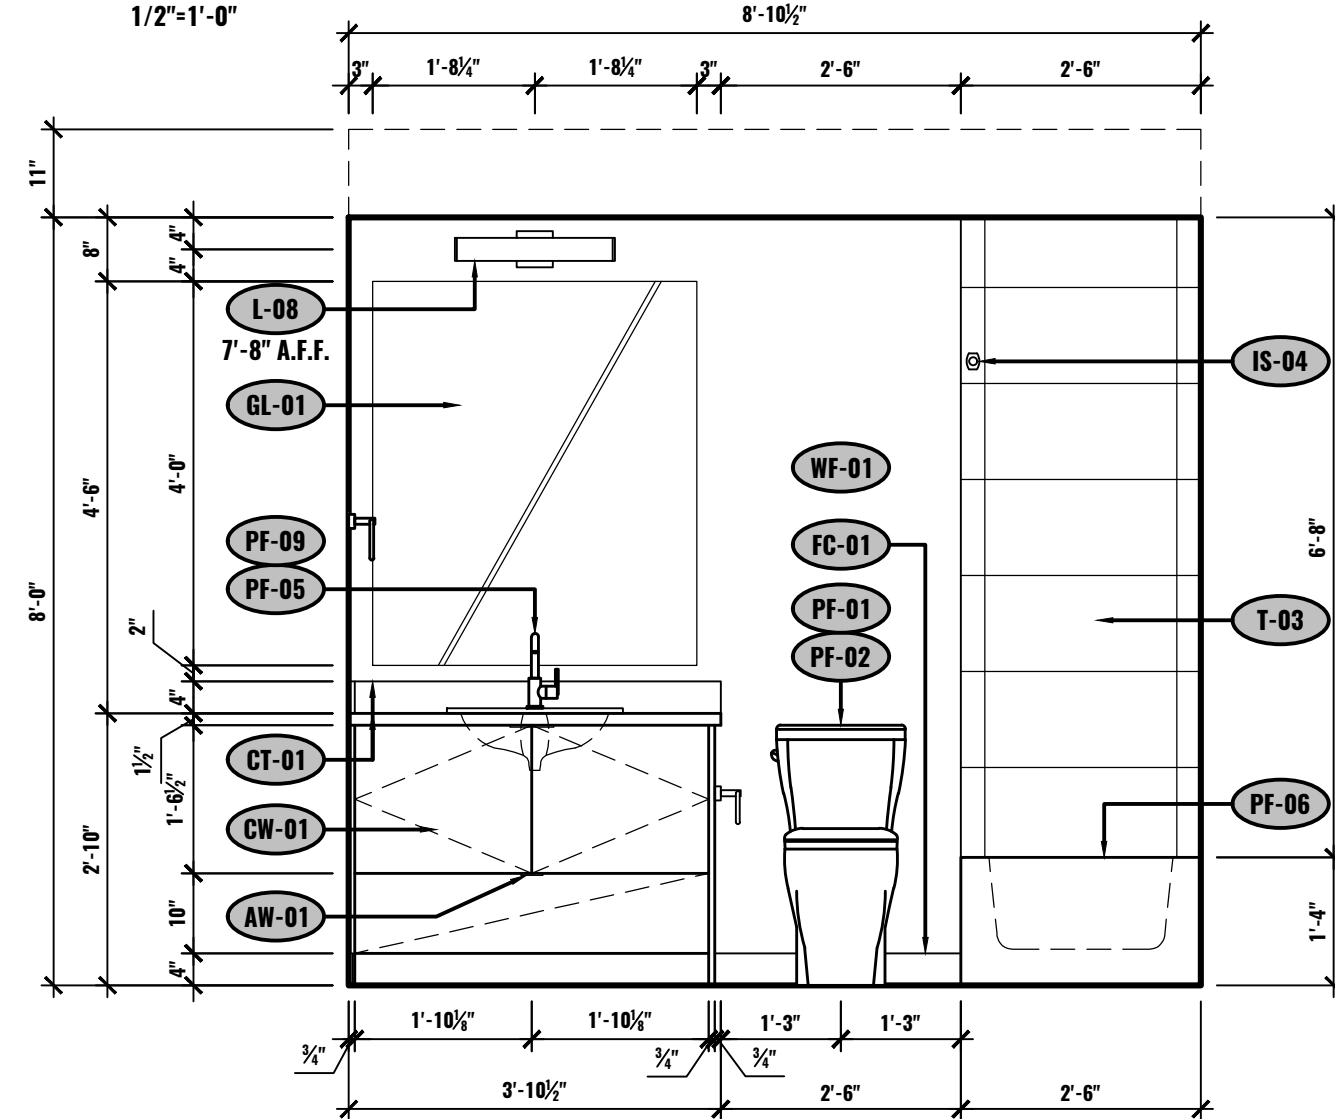


K ELEVATION - BATHROOM
UNIT #2-504
1/2"=1'-0"

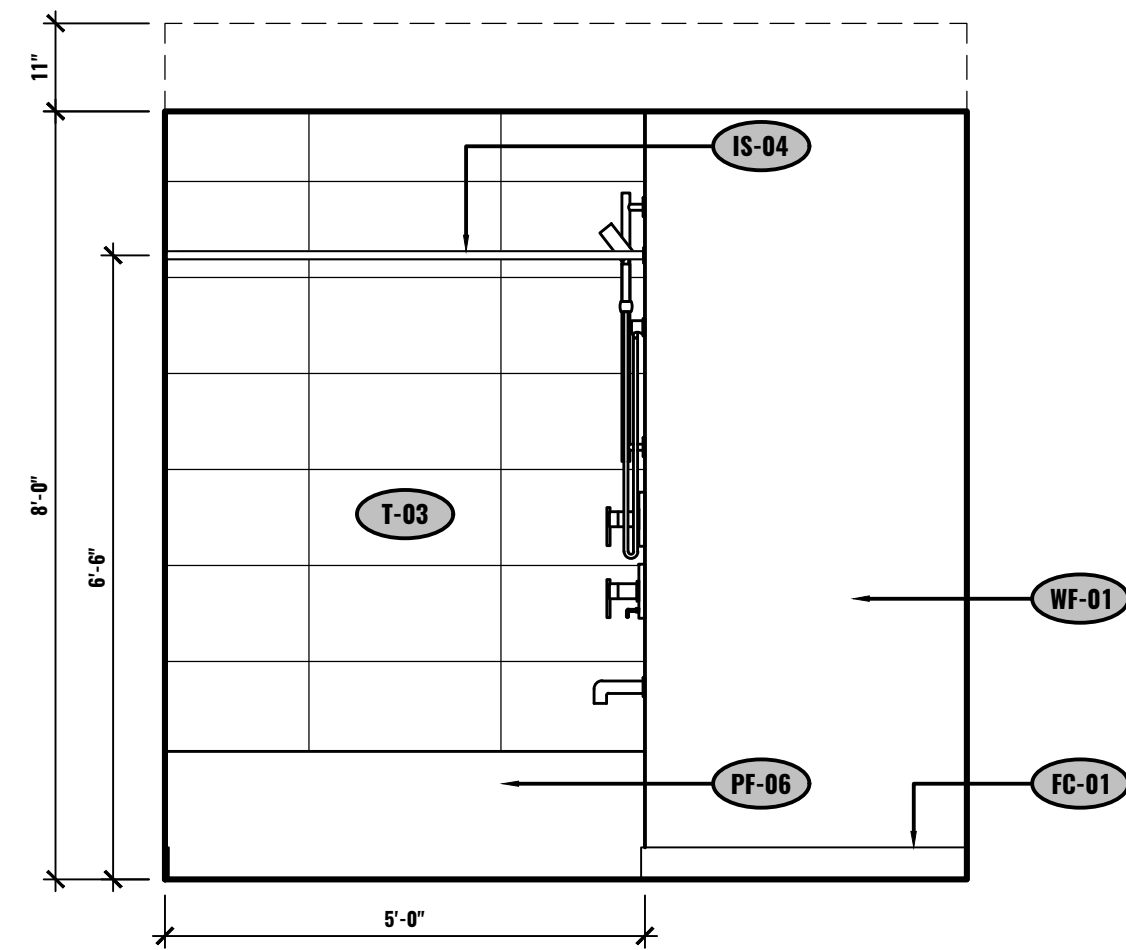


L ELEVATION - BATHROOM
UNIT #2-504
1/2"=1'-0"

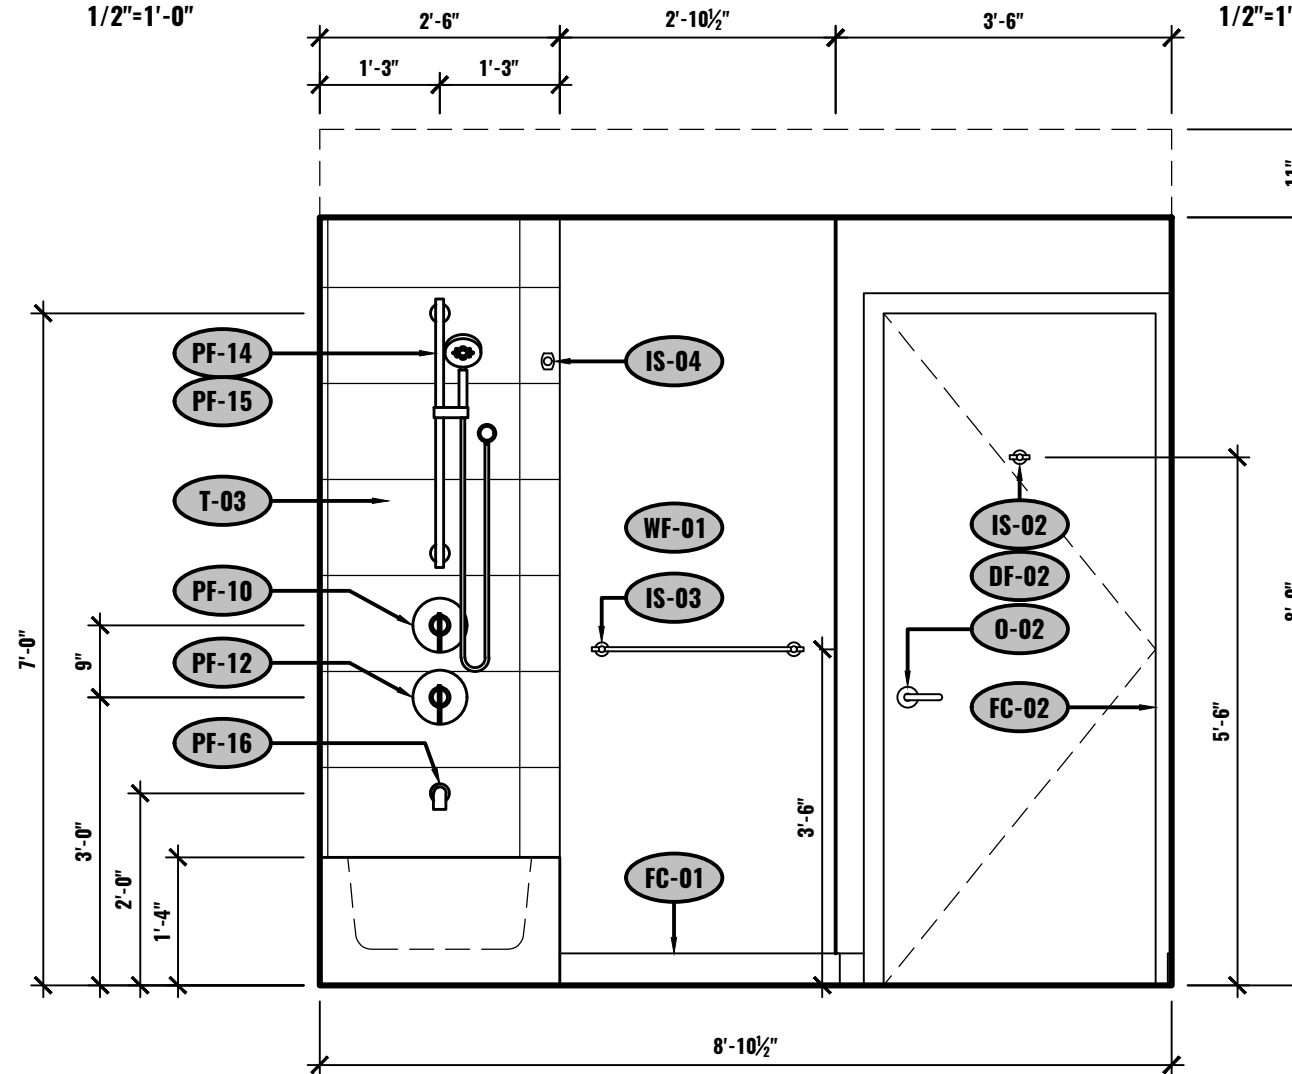


M ELEVATION - BATHROOM
UNIT #2-504
1/2"=1'-0"

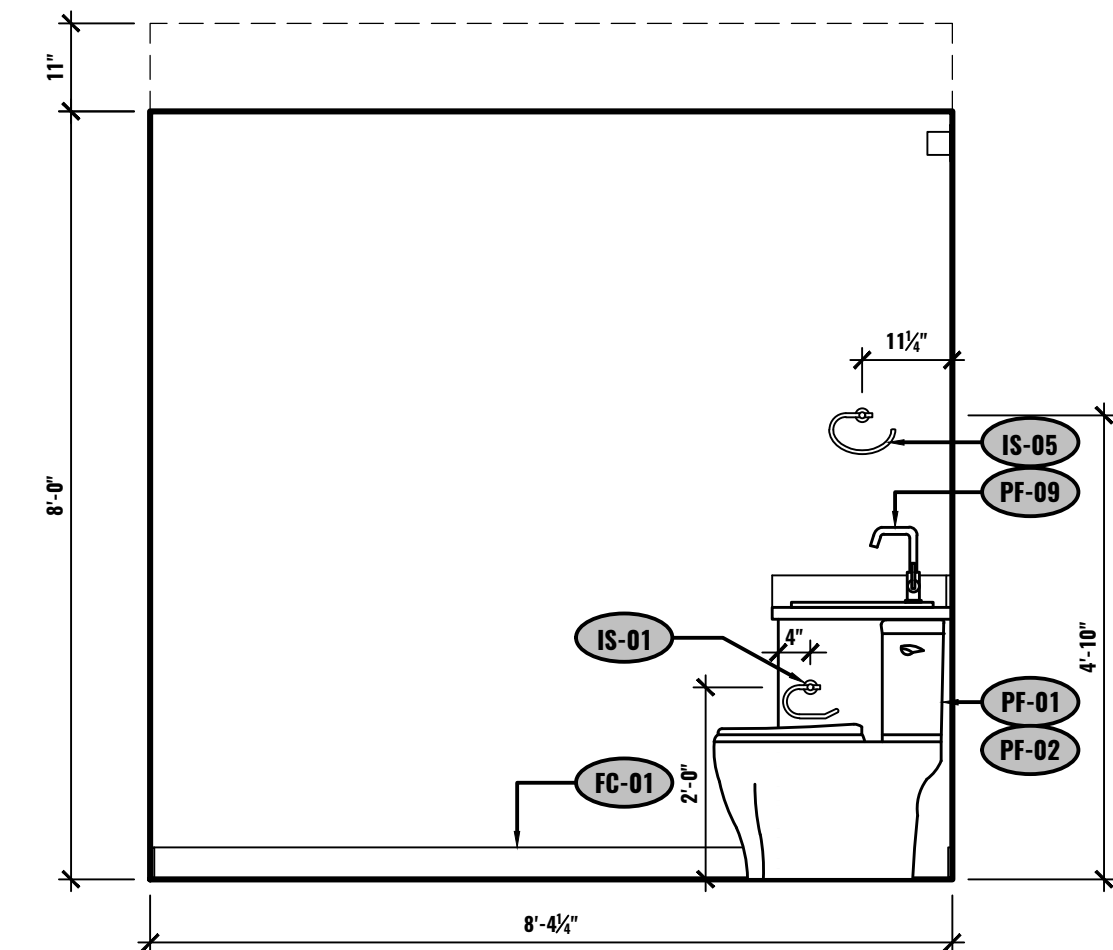


N ELEVATION - BATHROOM
UNIT #2-504
1/2"=1'-0"

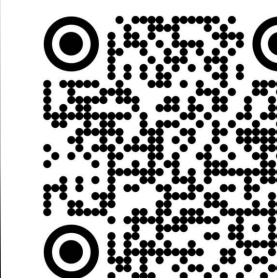


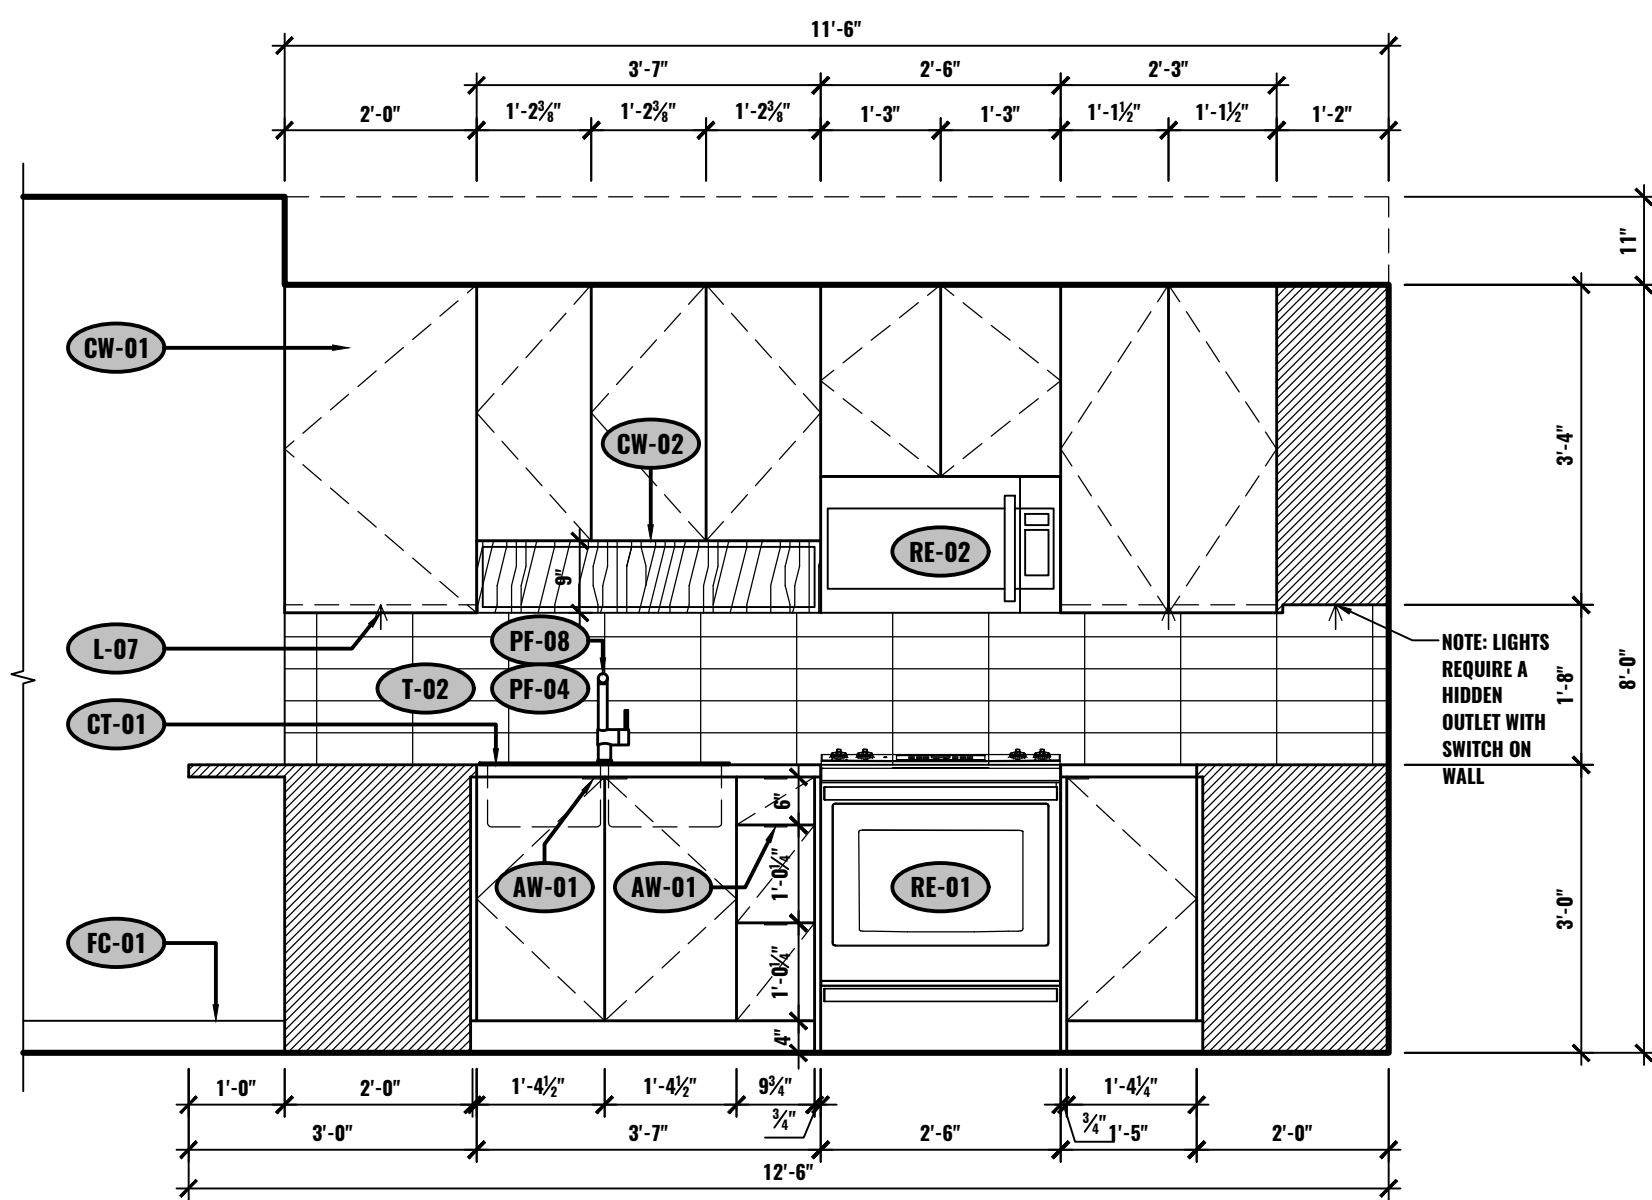


A ELEVATION - KITCHEN
UNIT #2-504
1/2"=1'-0"

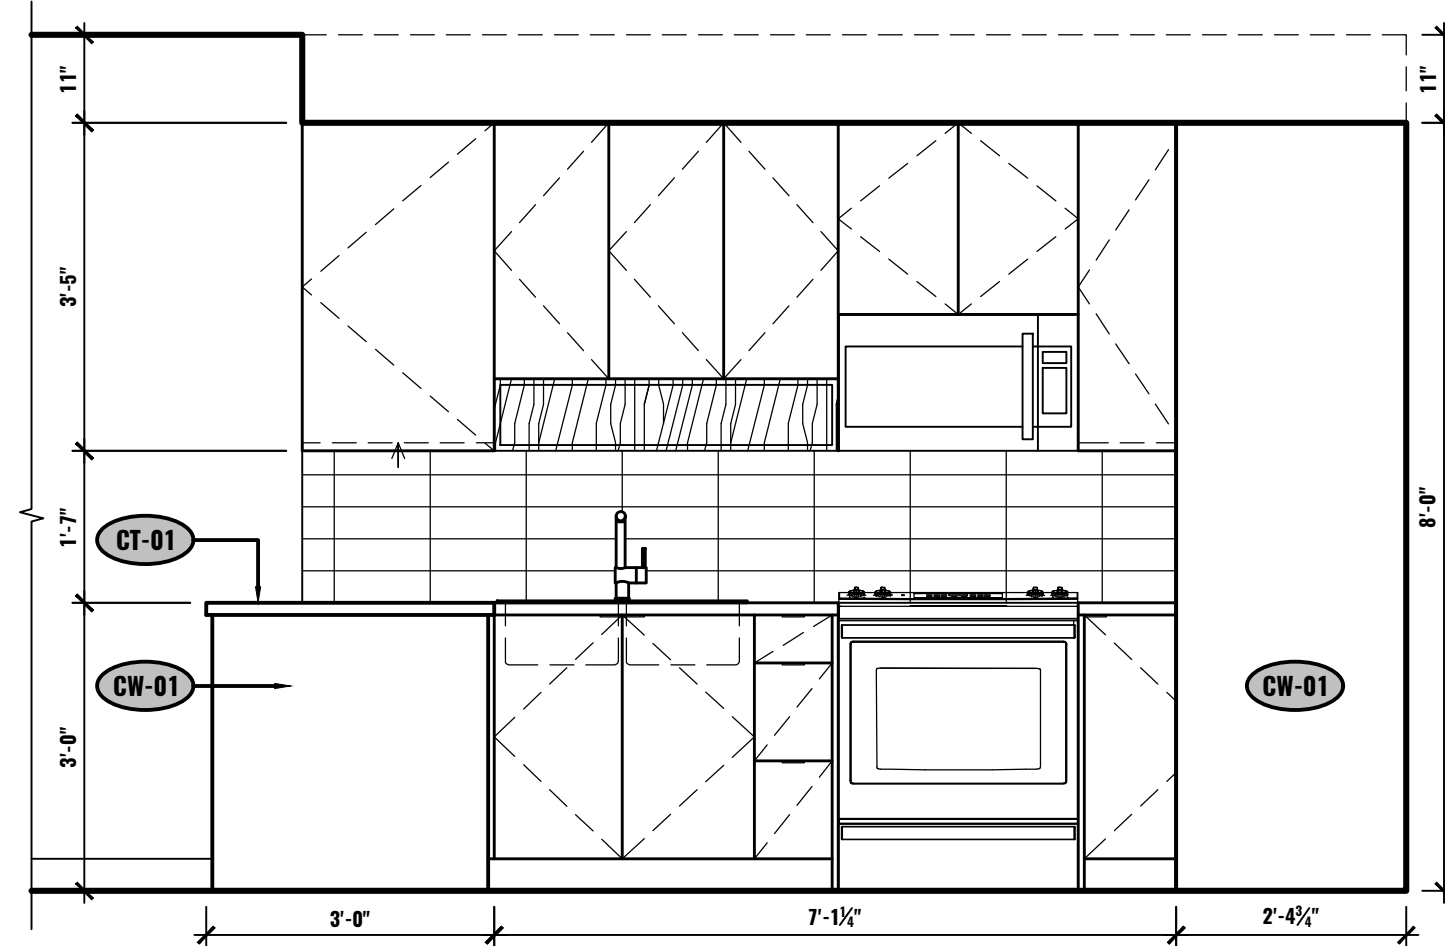


B ELEVATION - KITCHEN
UNIT #2-504
1/2"=1'-0"

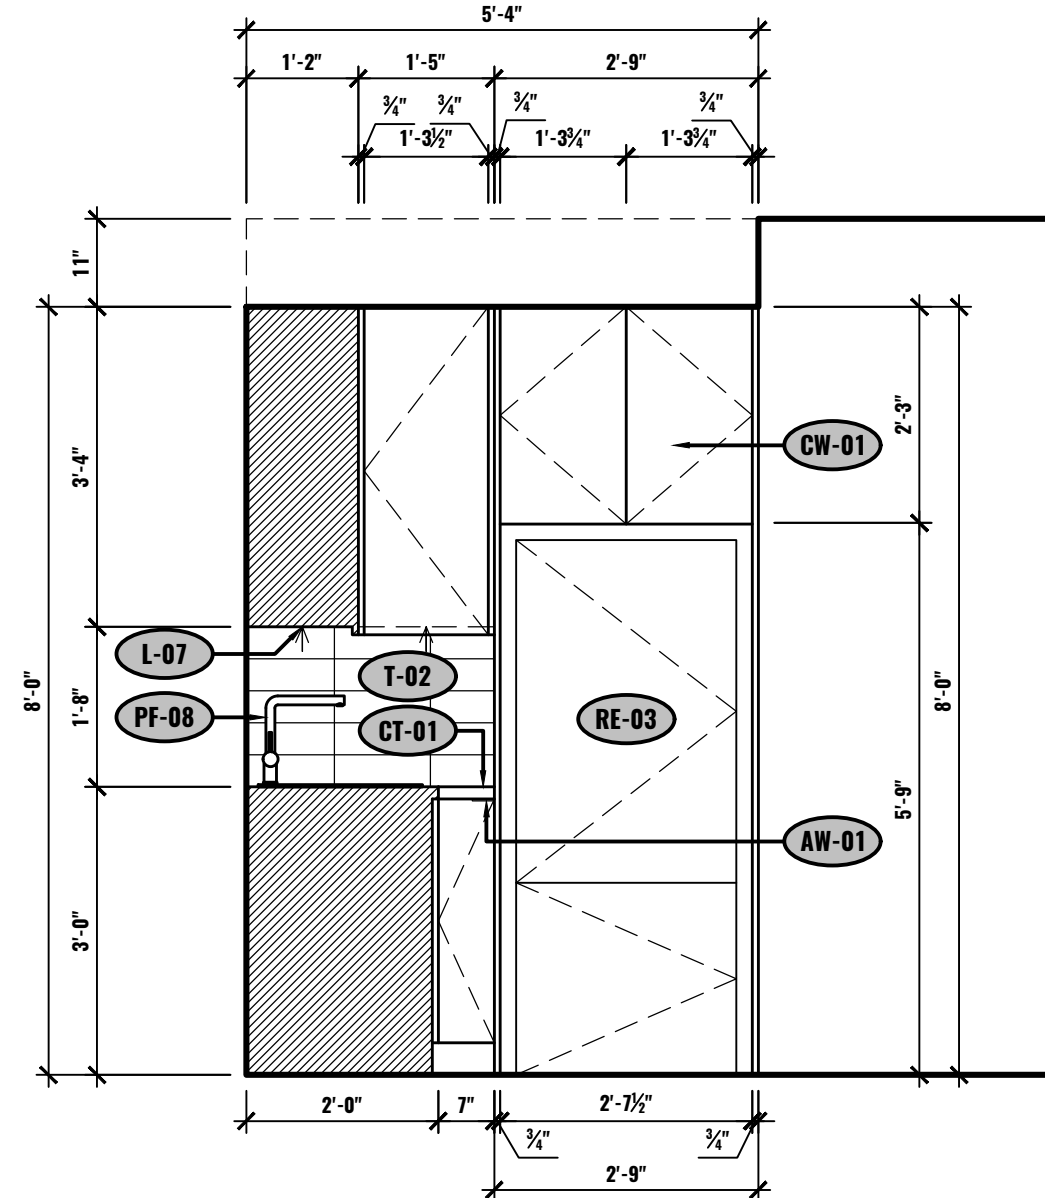


C ELEVATION - KITCHEN
UNIT #2-504
1/2"=1'-0"

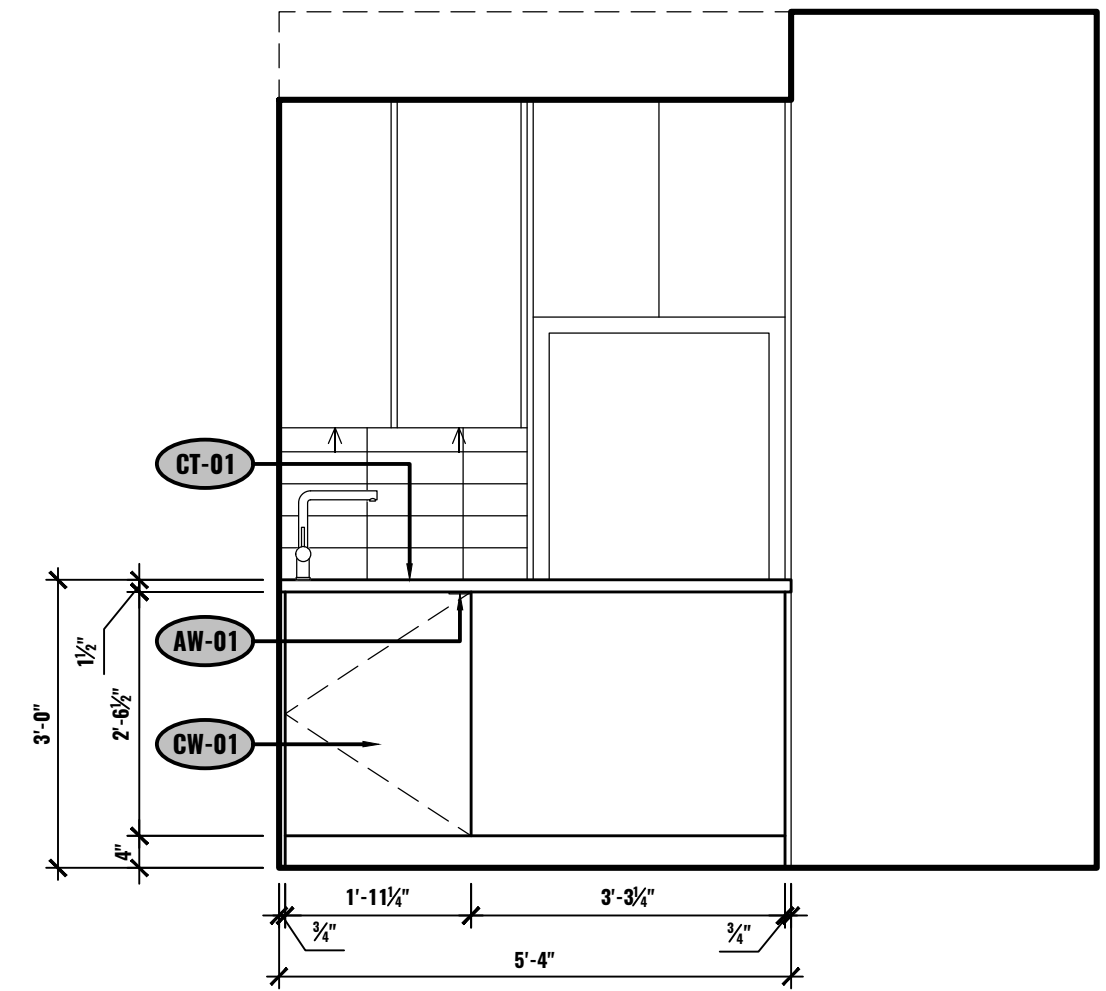


D ELEVATION - KITCHEN
UNIT #2-504
1/2"=1'-0"

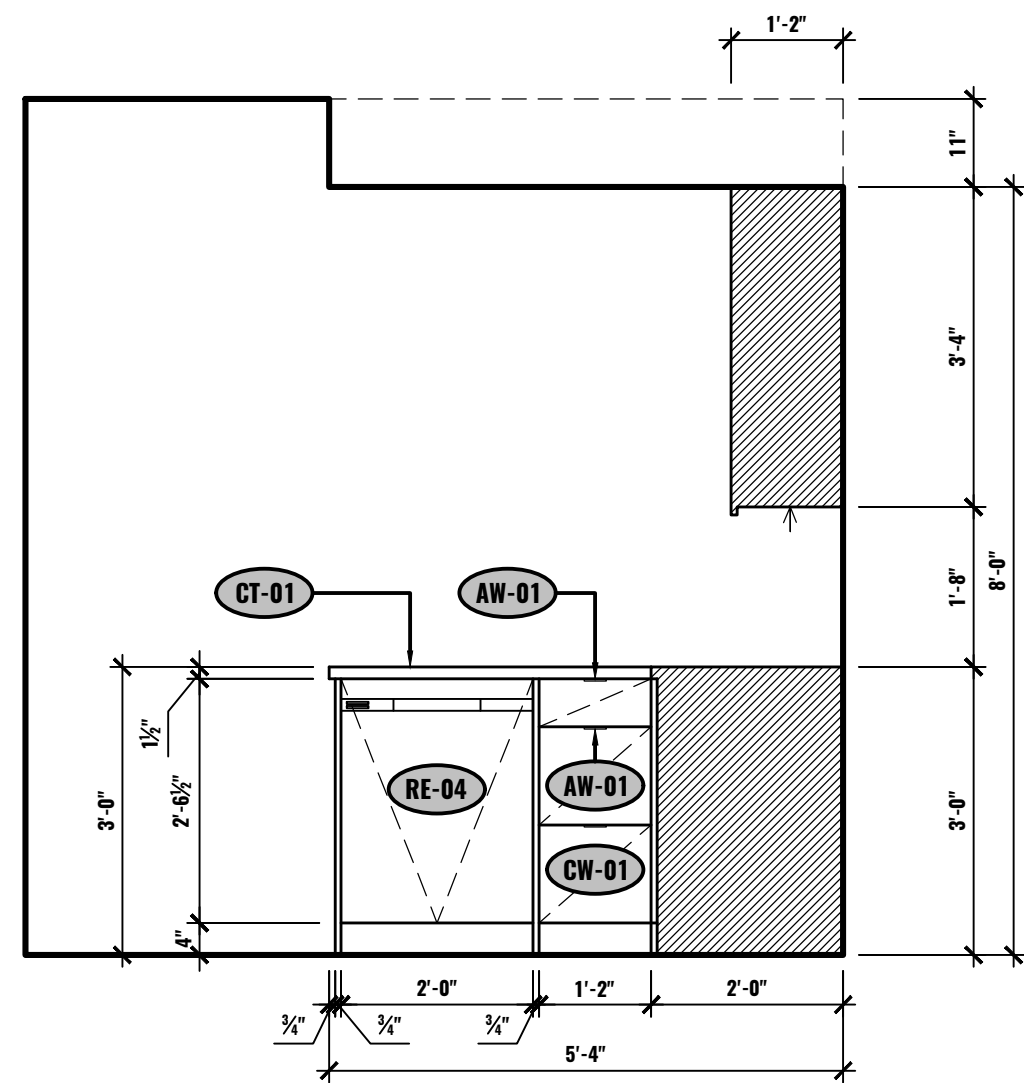


E ELEVATION - KITCHEN
UNIT #2-504
1/2"=1'-0"

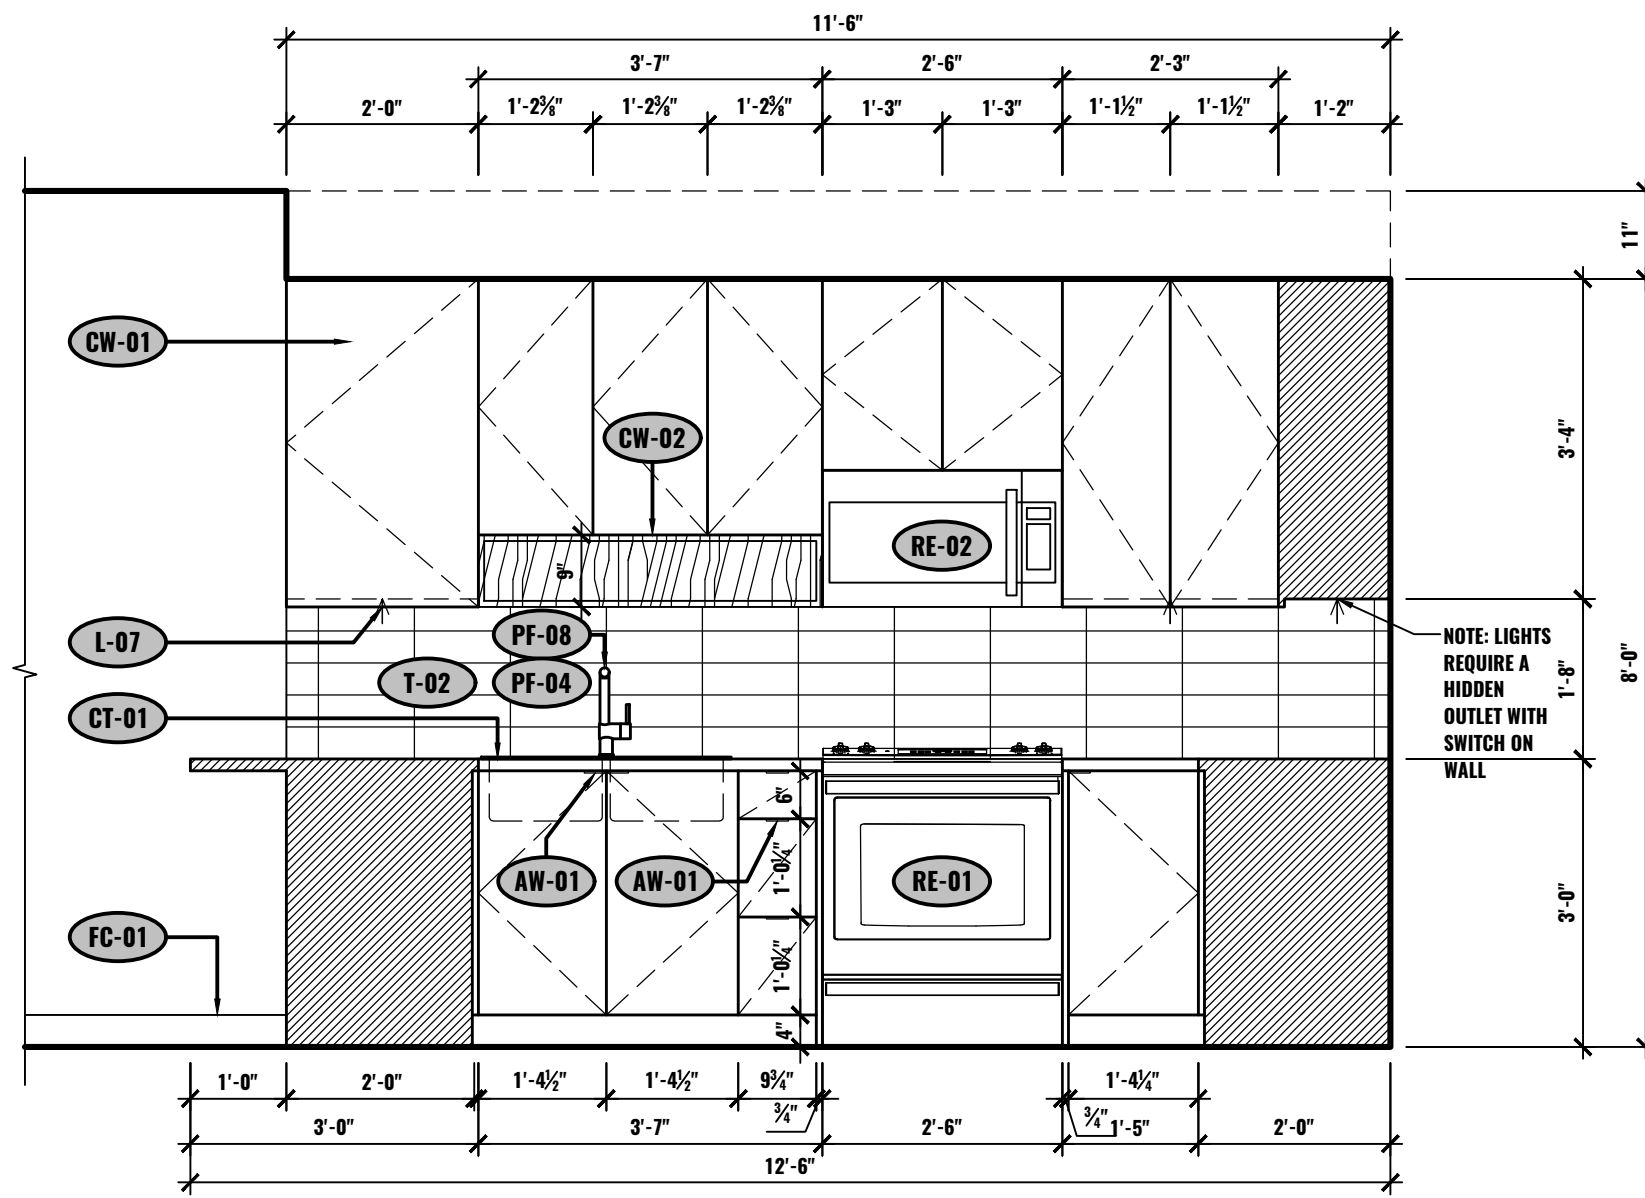


F ELEVATION - KITCHEN
UNIT #2-505
1/2"=1'-0"

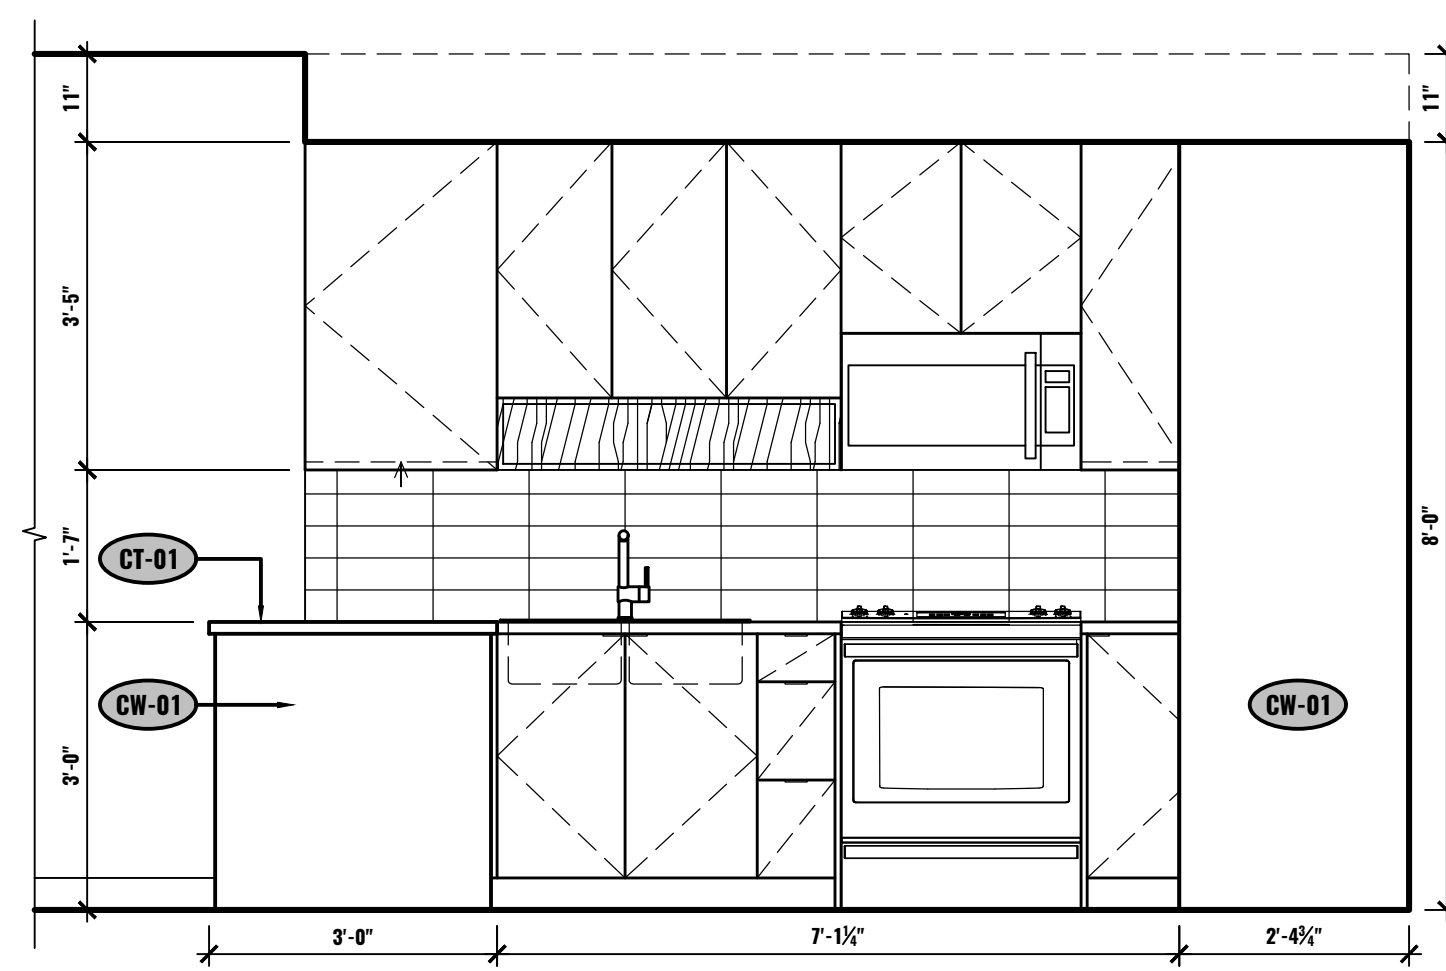


G ELEVATION - KITCHEN
UNIT #2-505
1/2"=1'-0"

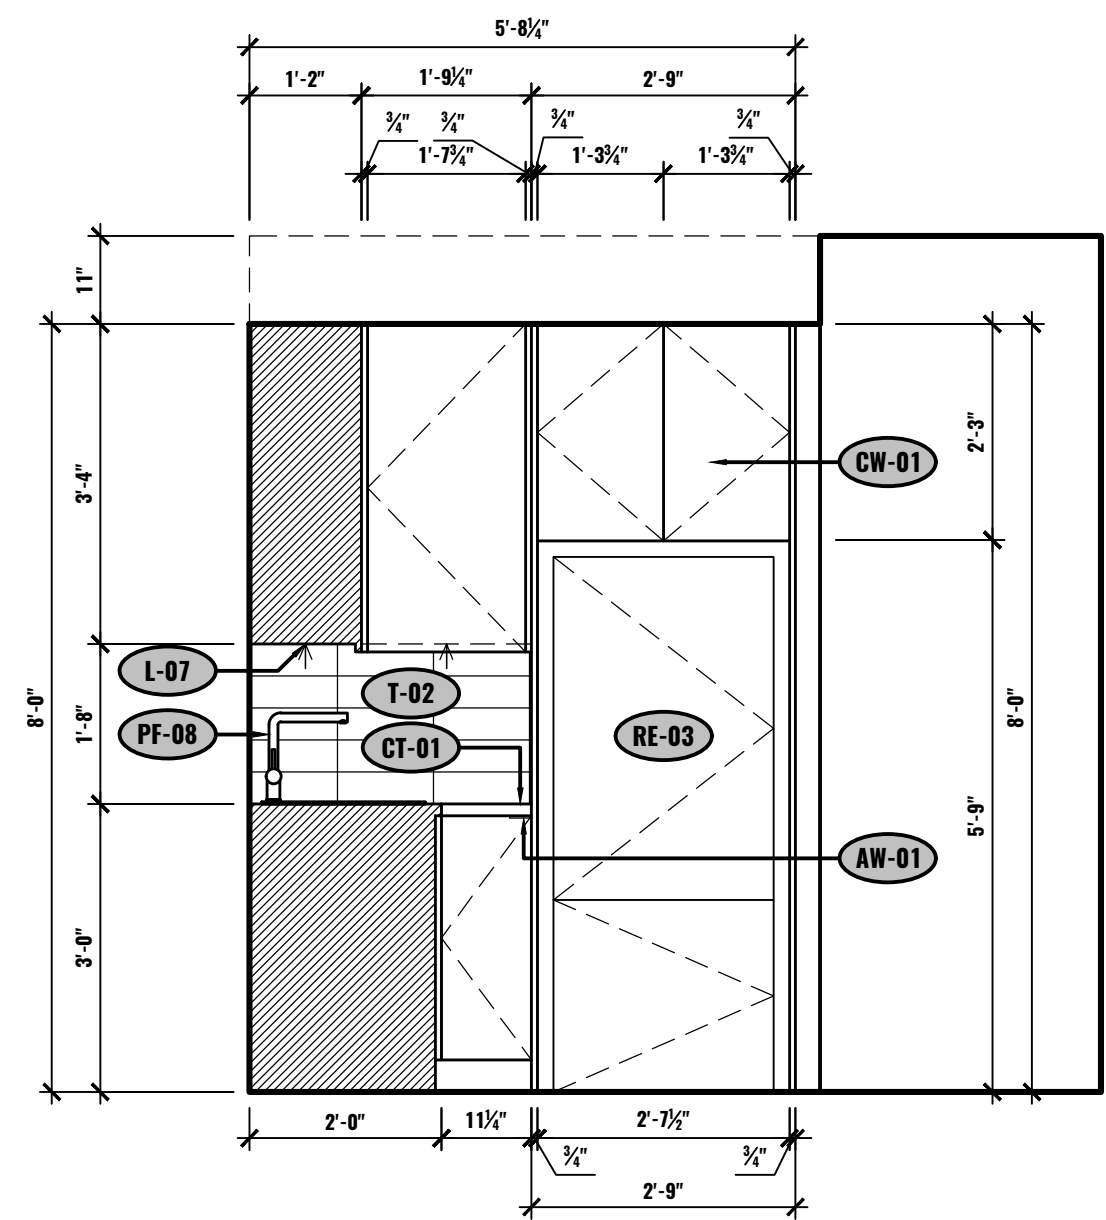


H ELEVATION - KITCHEN
UNIT #2-505
1/2"=1'-0"

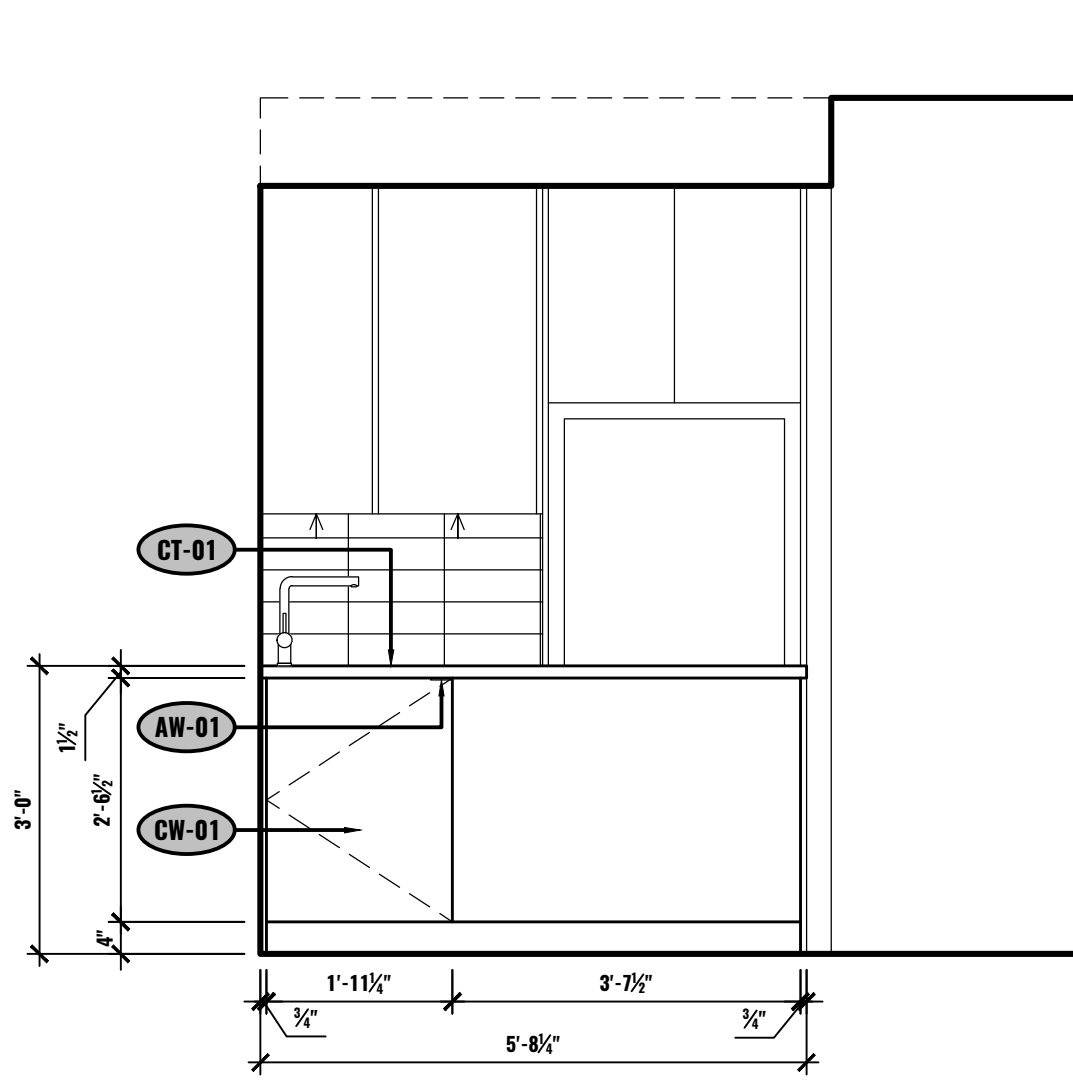


J ELEVATION - KITCHEN
UNIT #2-505
1/2"=1'-0"

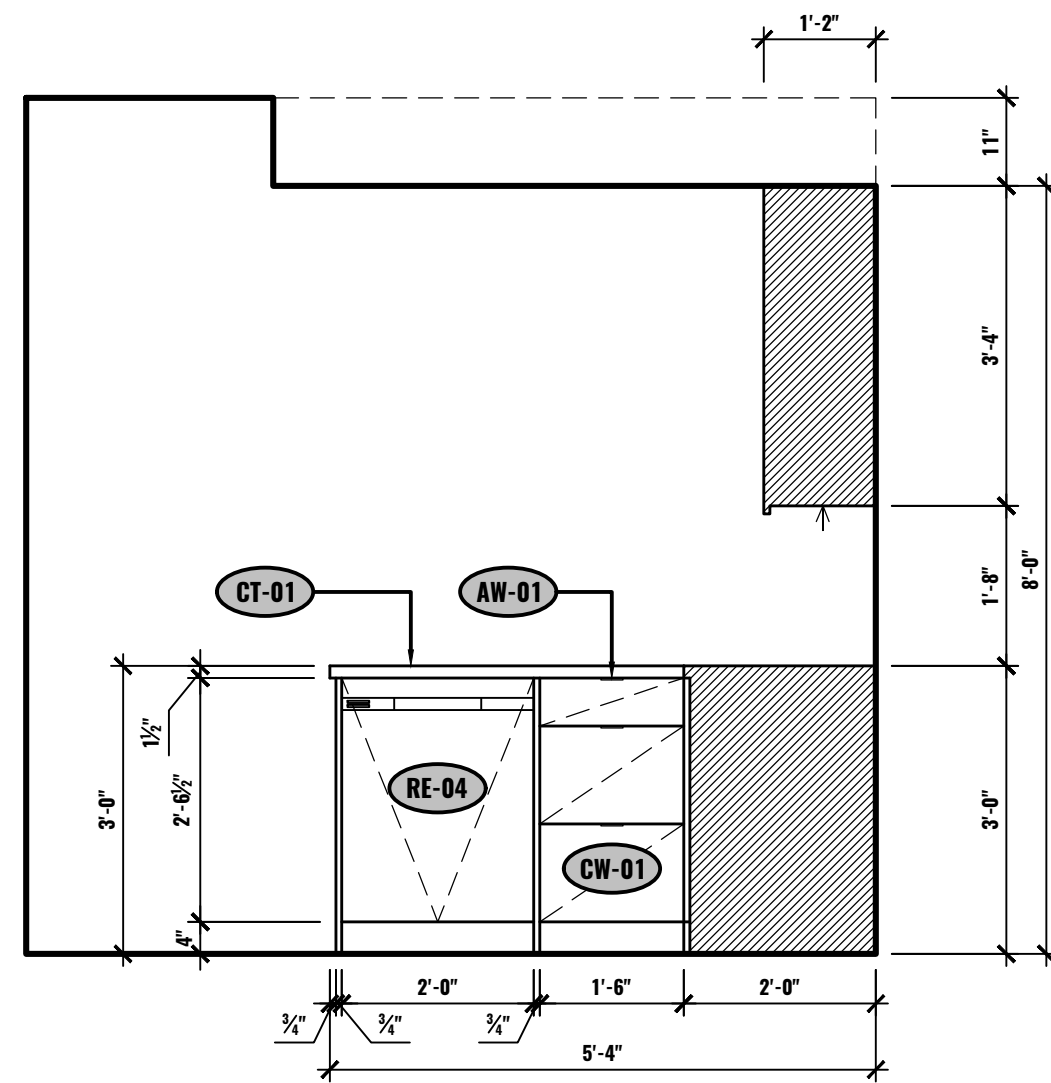


K ELEVATION - KITCHEN
UNIT #2-505
1/2"=1'-0"

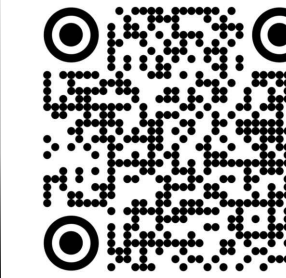


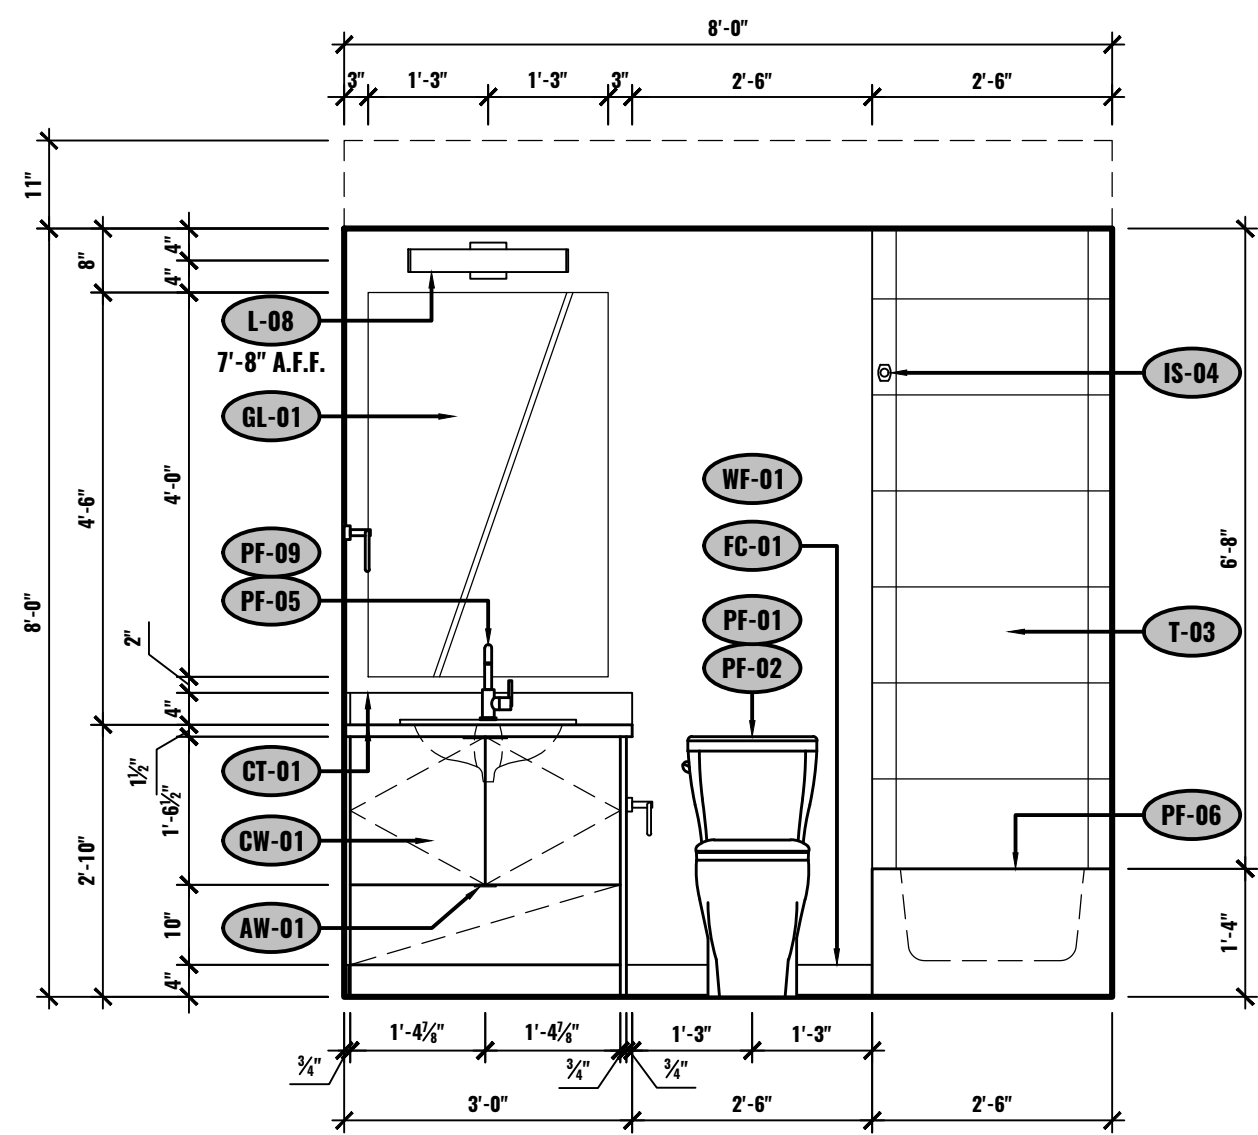


A ELEVATION - BATHROOM
UNIT #2-505
1/2"=1'-0"

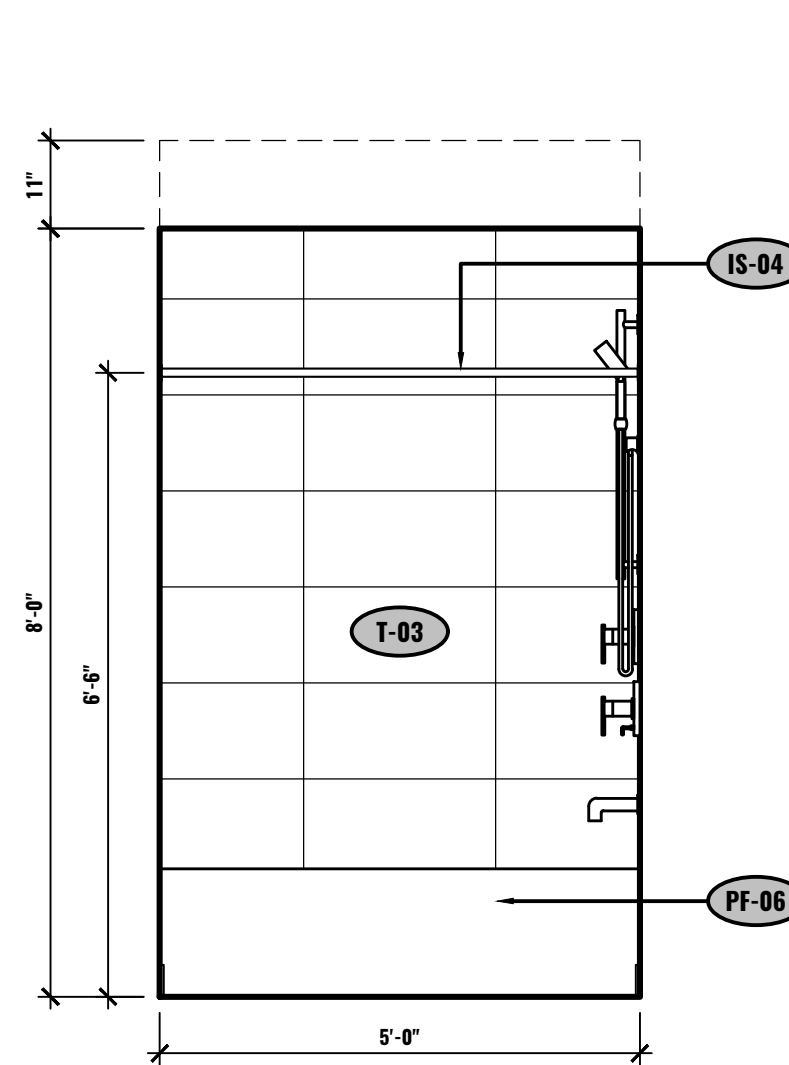


B ELEVATION - BATHROOM
UNIT #2-505
1/2"=1'-0"

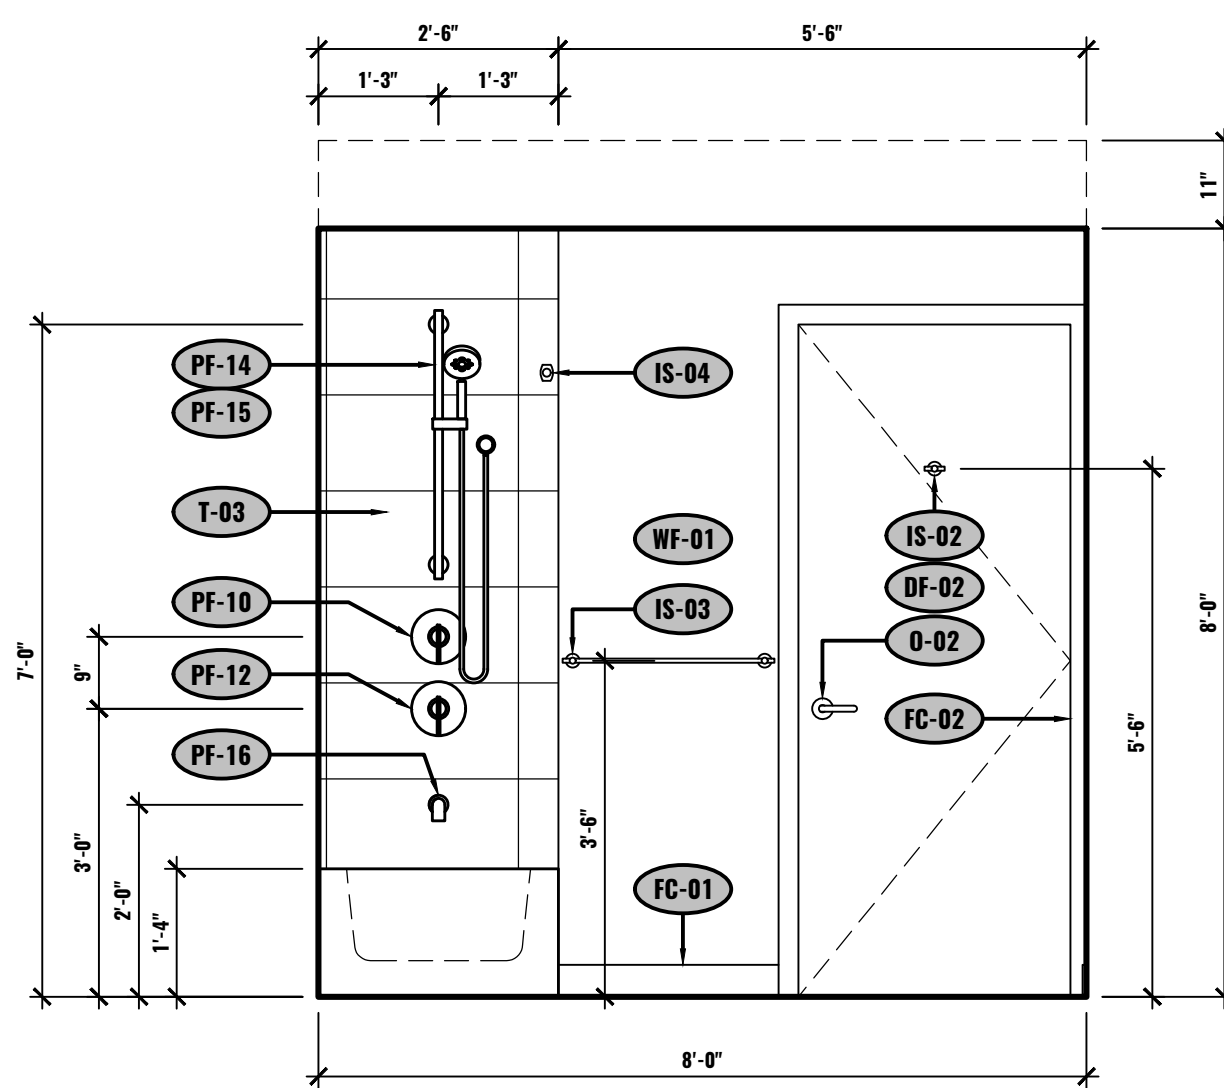


C ELEVATION - BATHROOM
UNIT #2-505
1/2"=1'-0"

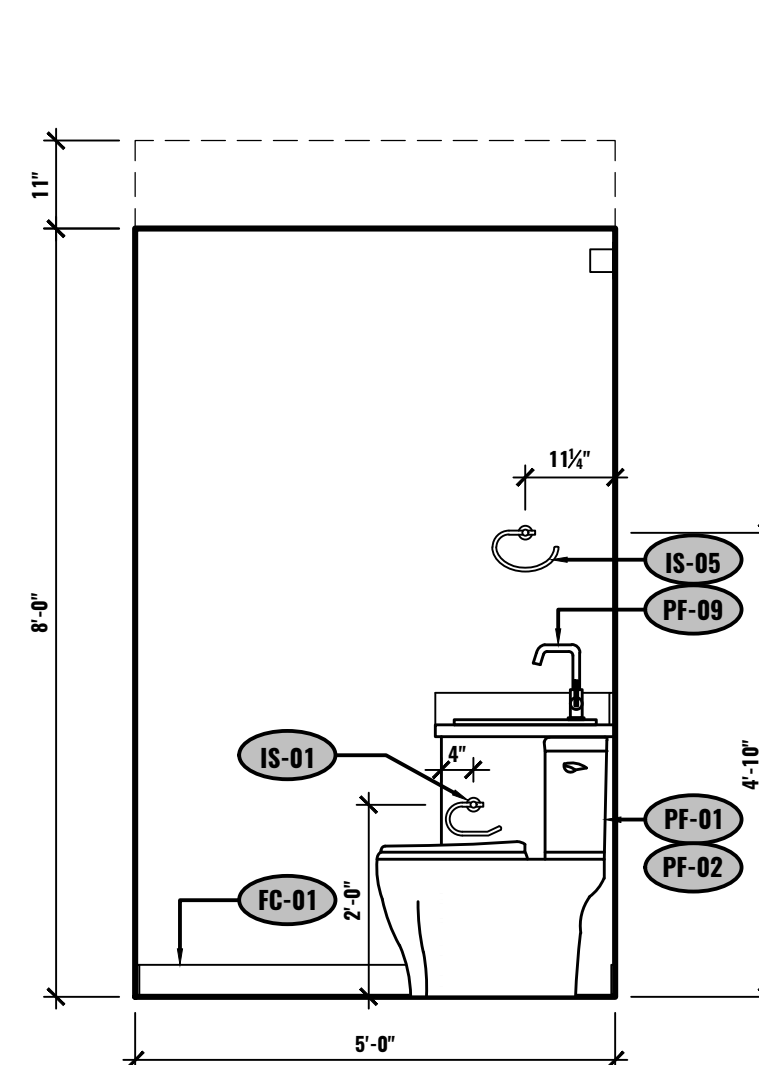


D ELEVATION - BATHROOM
UNIT #2-505
1/2"=1'-0"

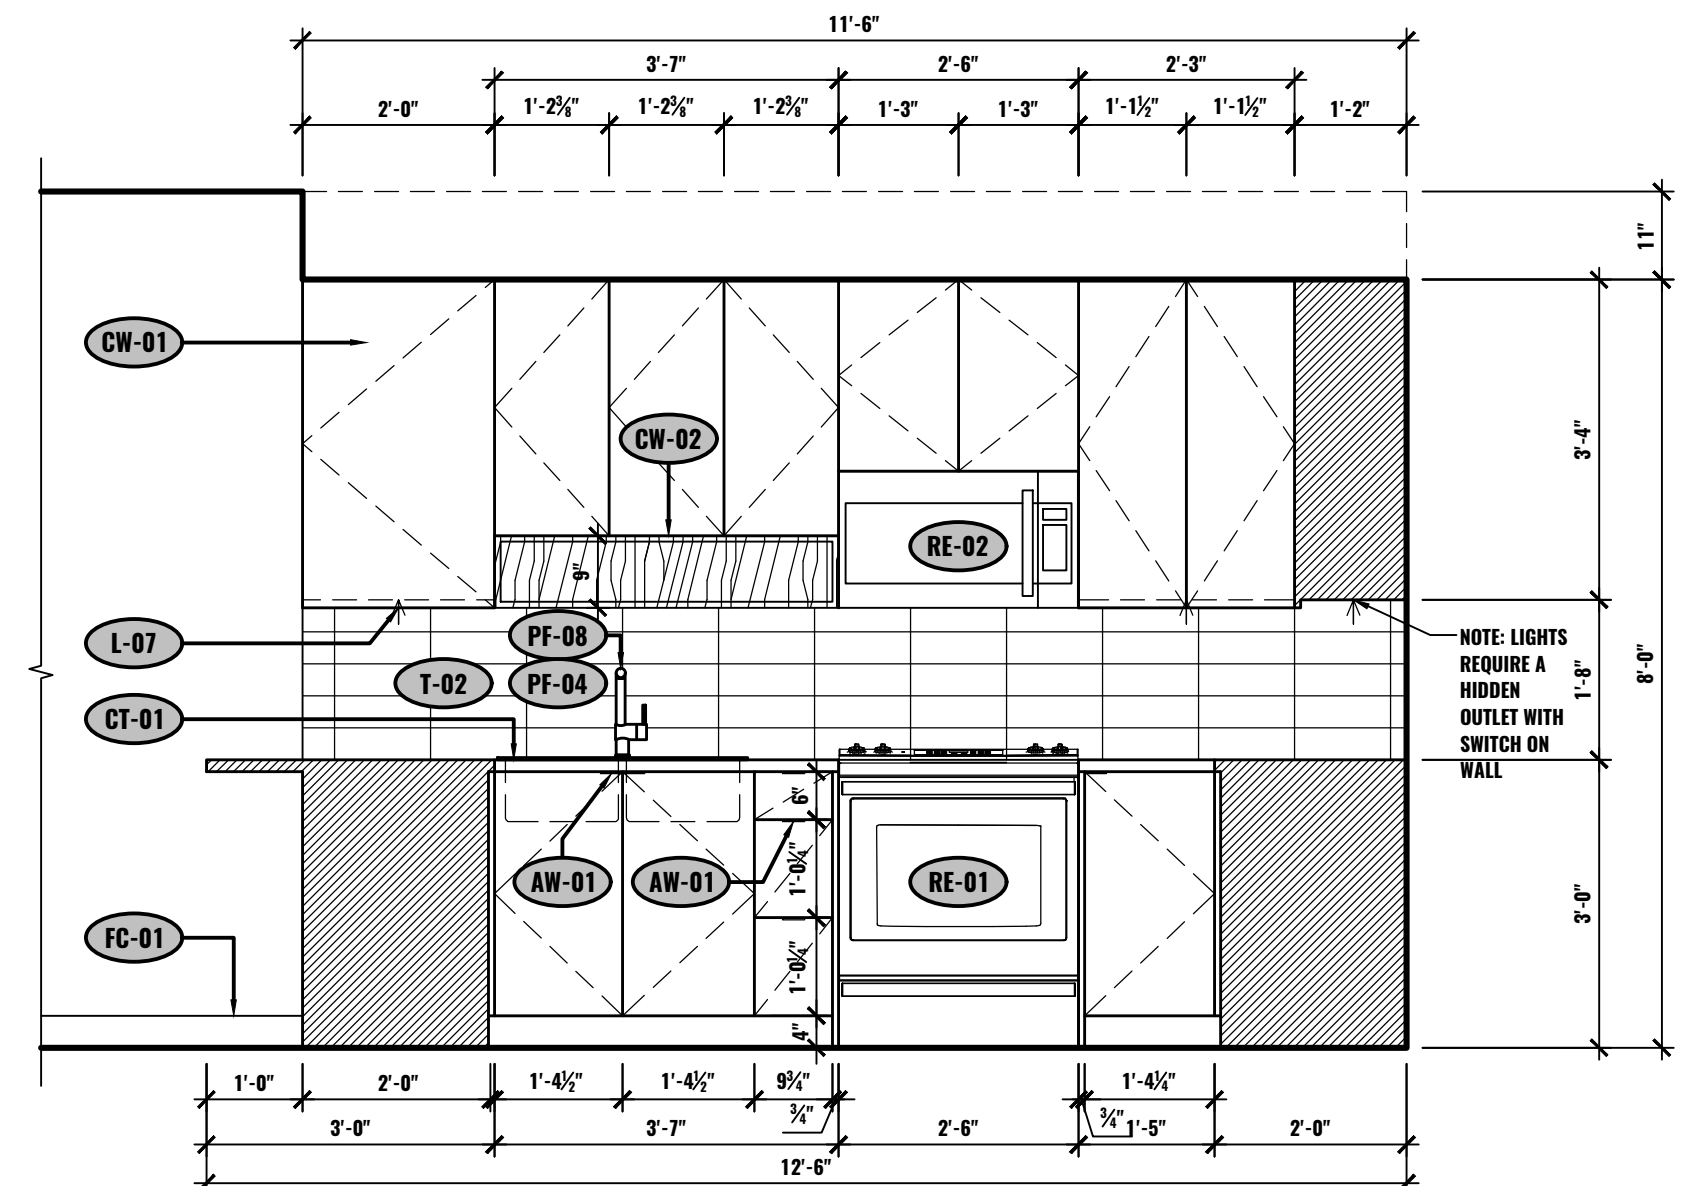


E ELEVATION - KITCHEN
UNIT #2-506
1/2"=1'-0"

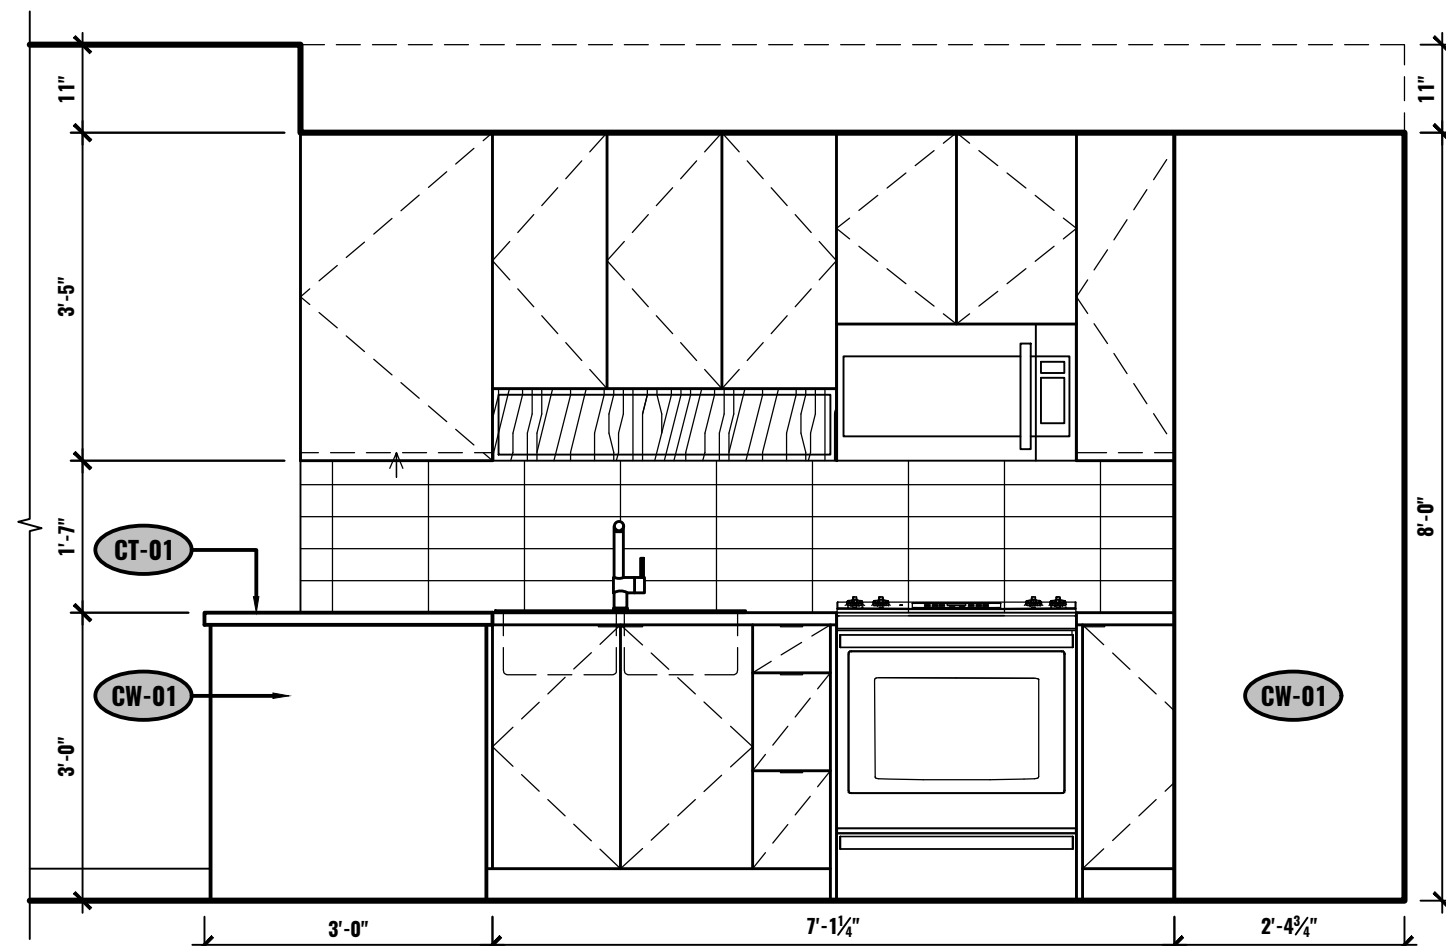


F ELEVATION - KITCHEN
UNIT #2-506
1/2"=1'-0"

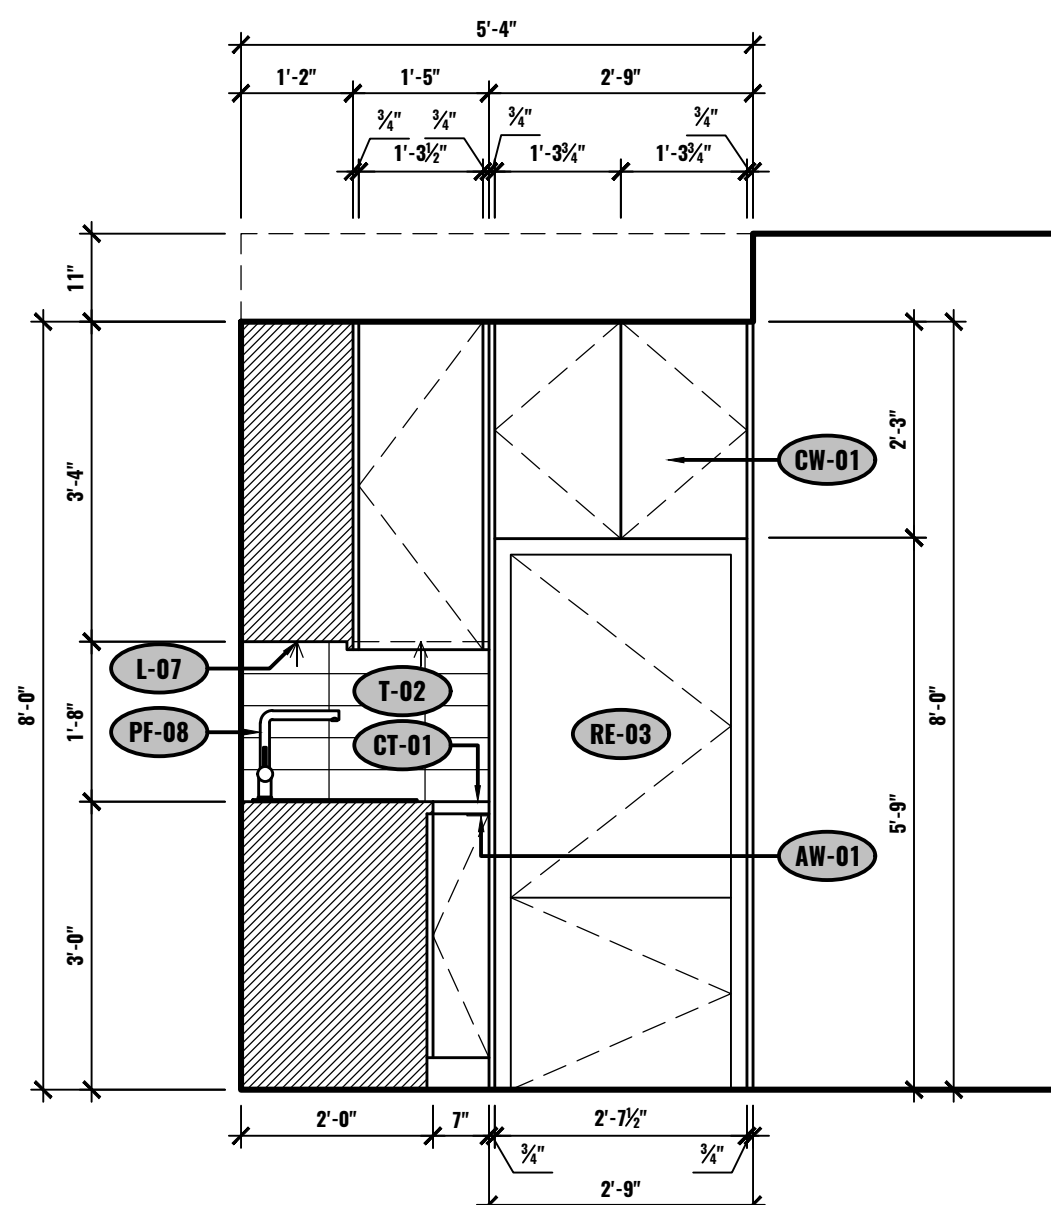


G ELEVATION - KITCHEN
UNIT #2-506
1/2"=1'-0"

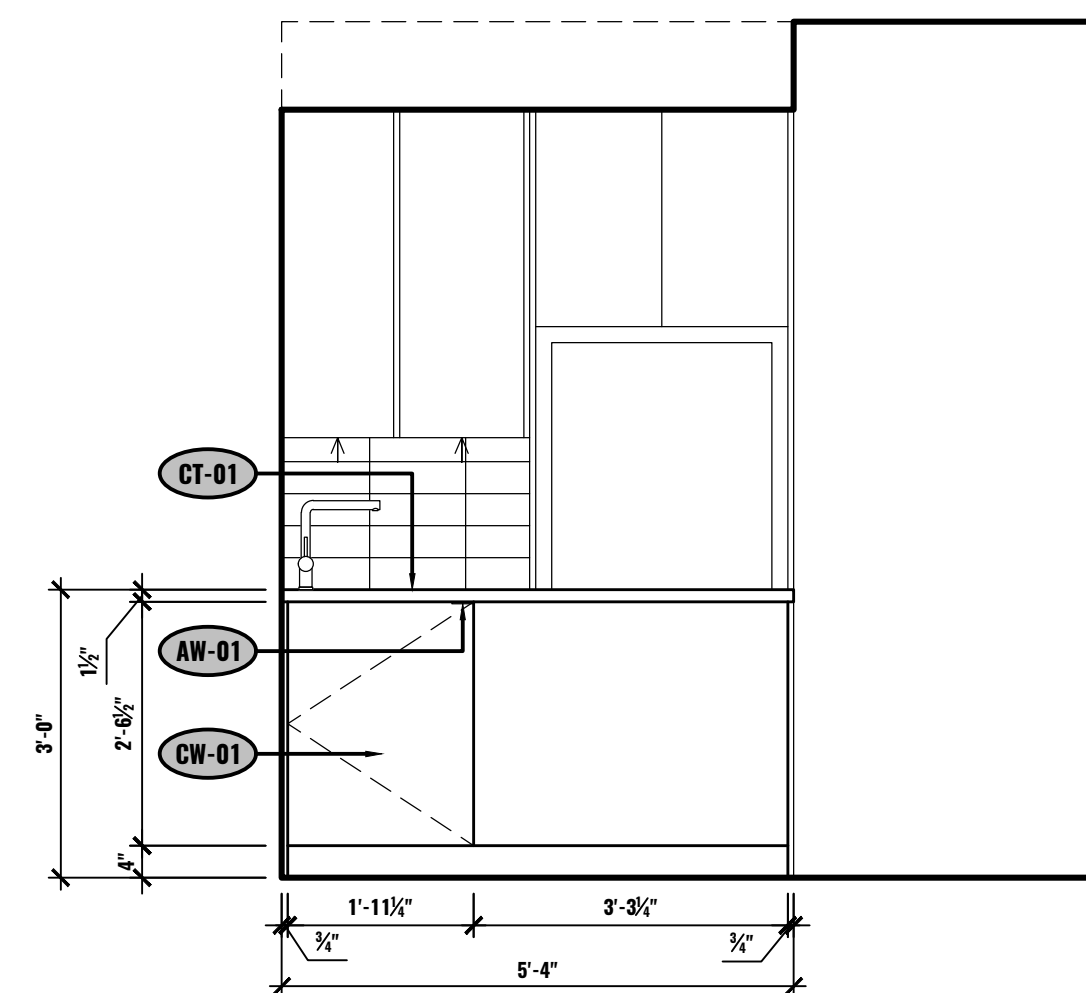


H ELEVATION - KITCHEN
UNIT #2-506
1/2"=1'-0"

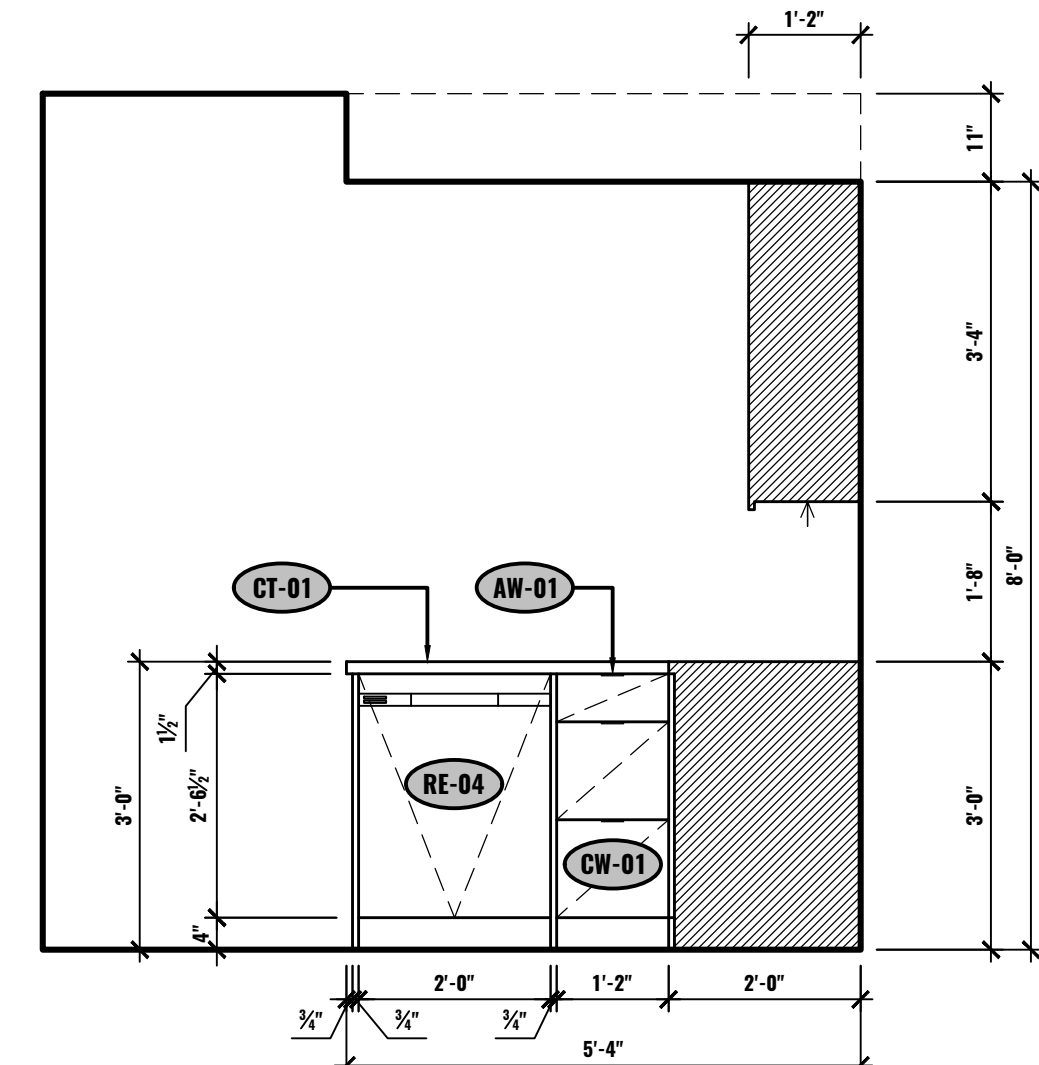


J ELEVATION - KITCHEN
UNIT #2-506
1/2"=1'-0"

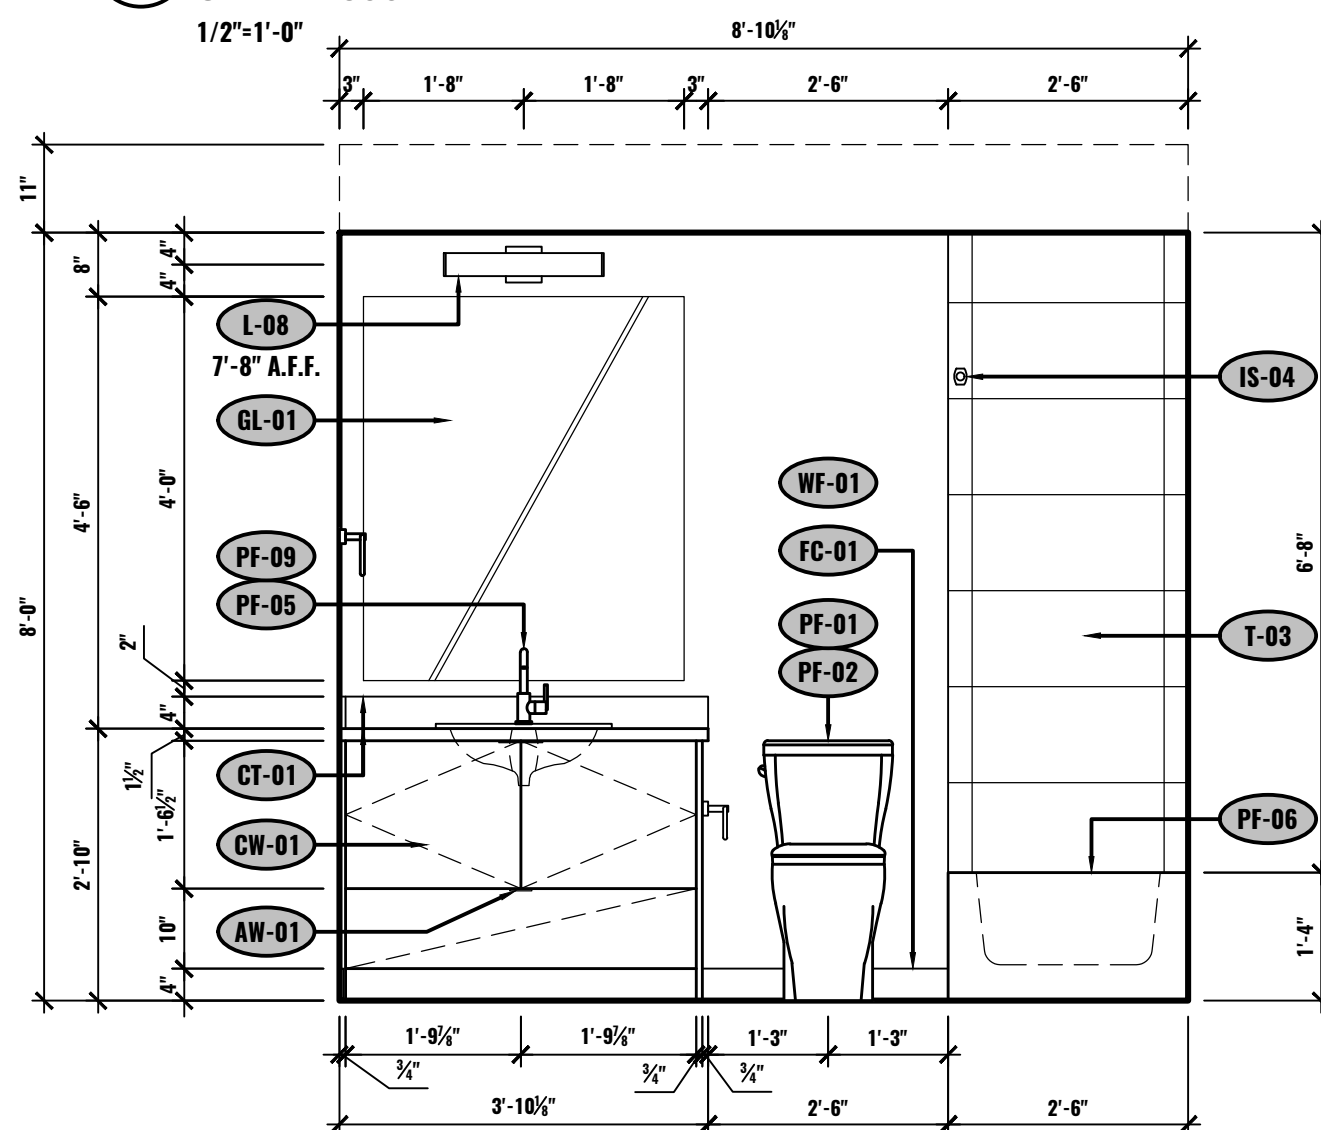


K ELEVATION - BATHROOM
UNIT #2-506
1/2"=1'-0"

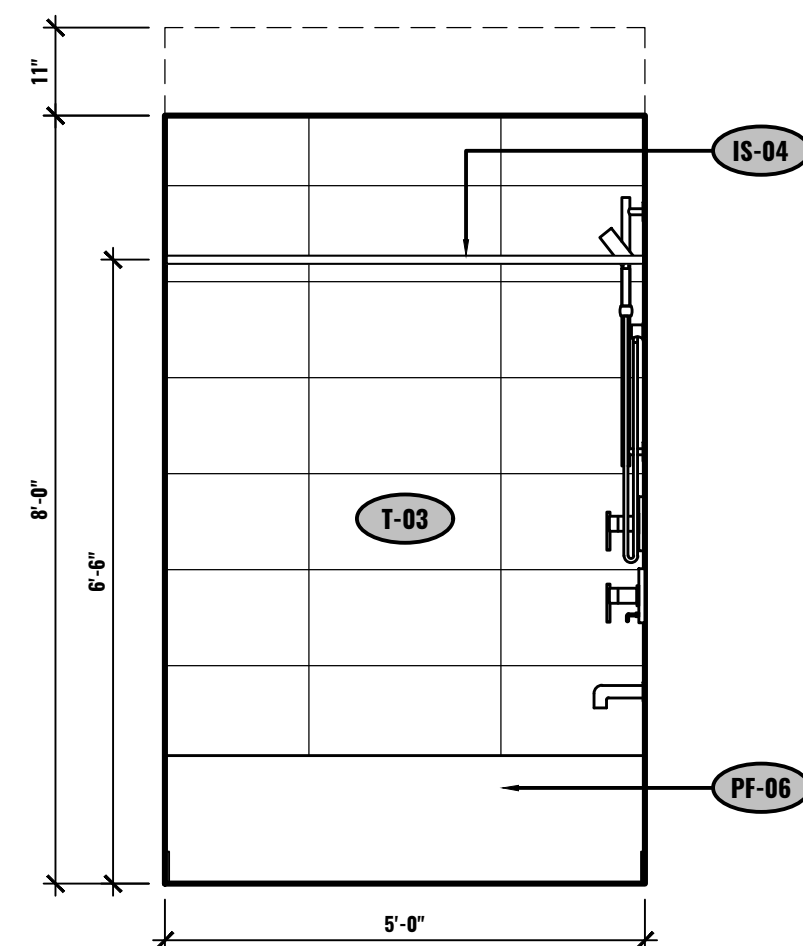


L ELEVATION - BATHROOM
UNIT #2-506
1/2"=1'-0"

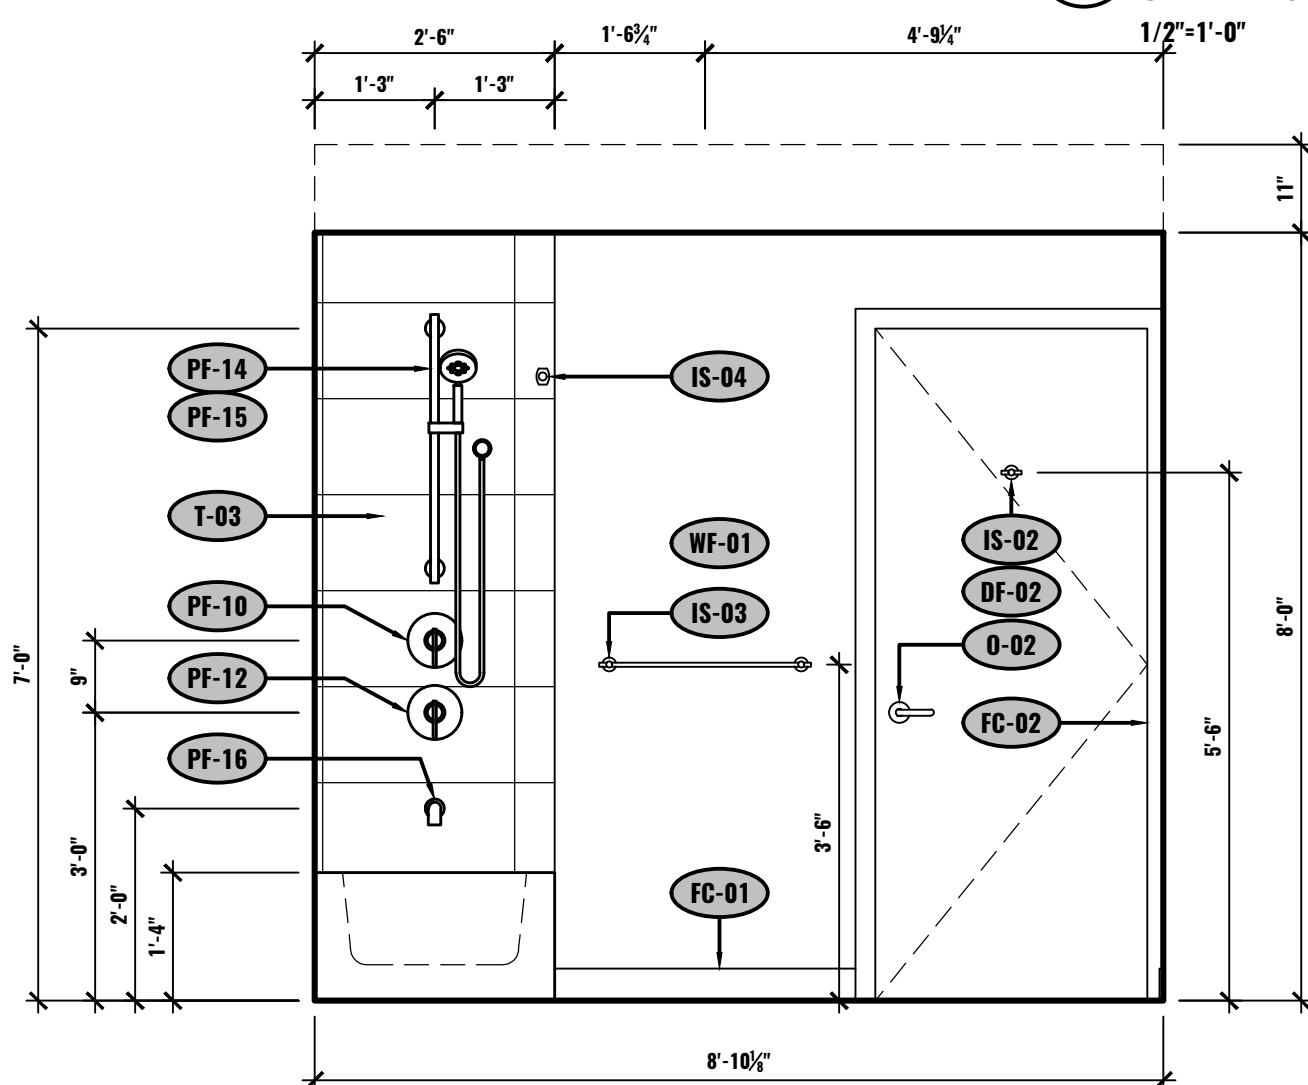


M ELEVATION - BATHROOM
UNIT #2-506
1/2"=1'-0"

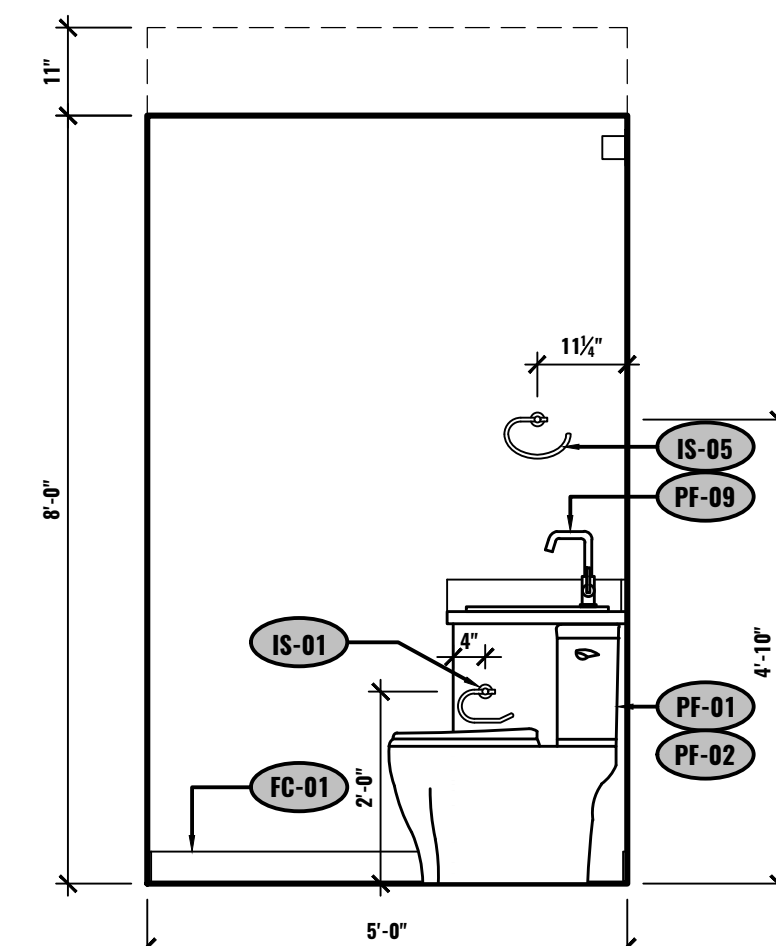


N ELEVATION - BATHROOM
UNIT #2-506
1/2"=1'-0"

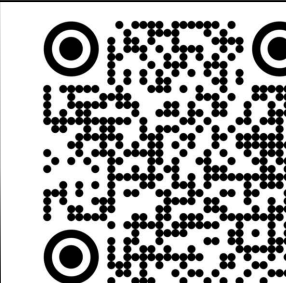


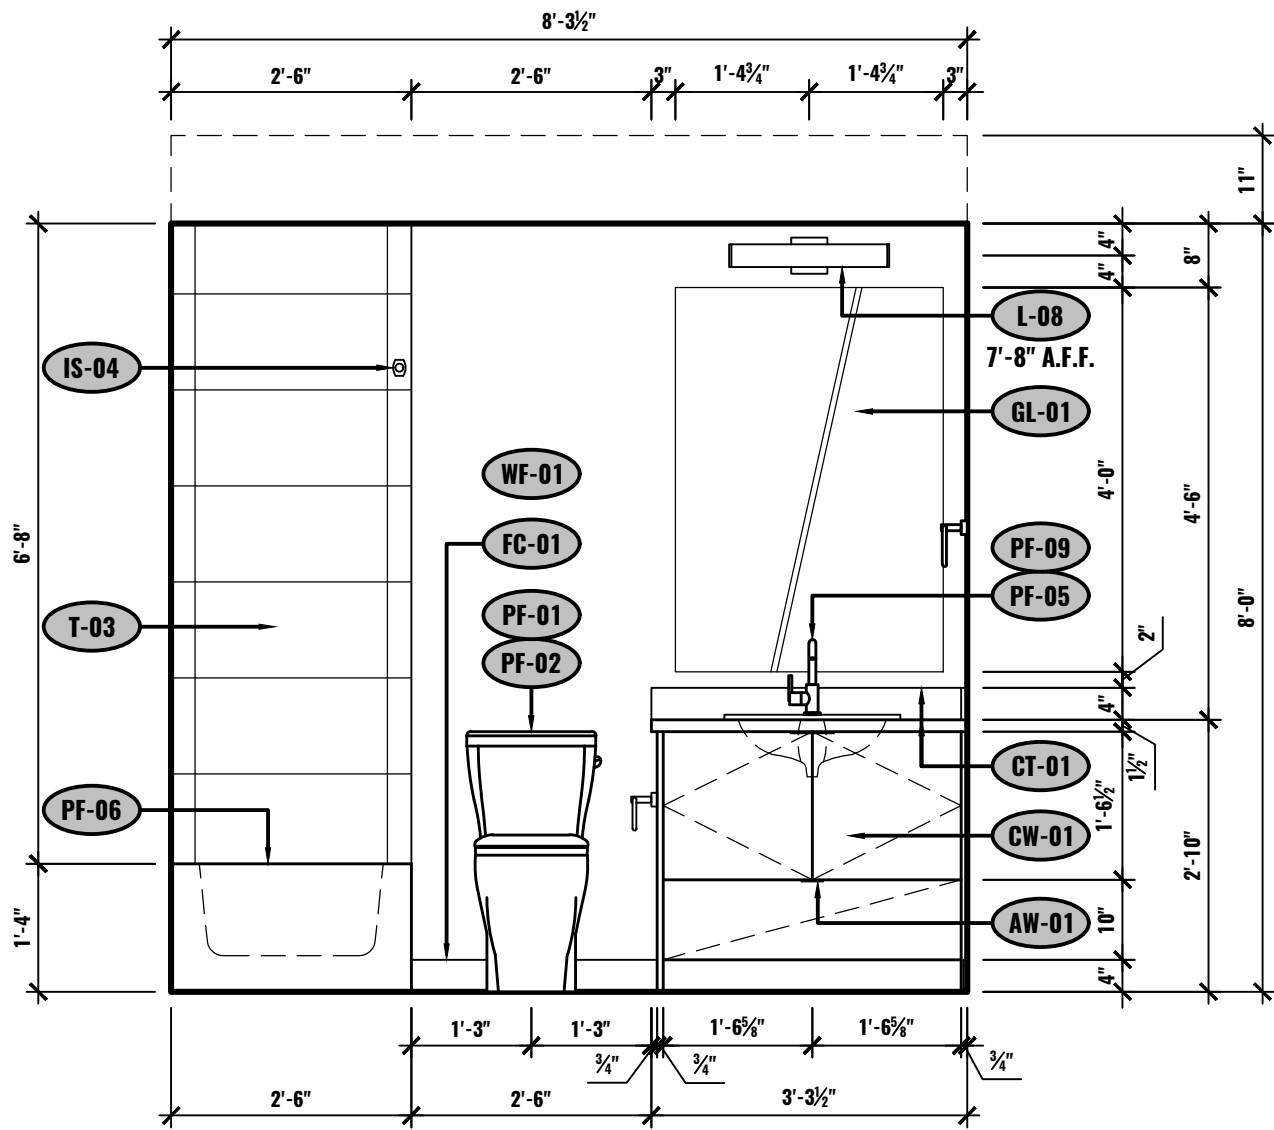


A ELEVATION - BATHROOM
UNIT #2-506
1/2"=1'-0"

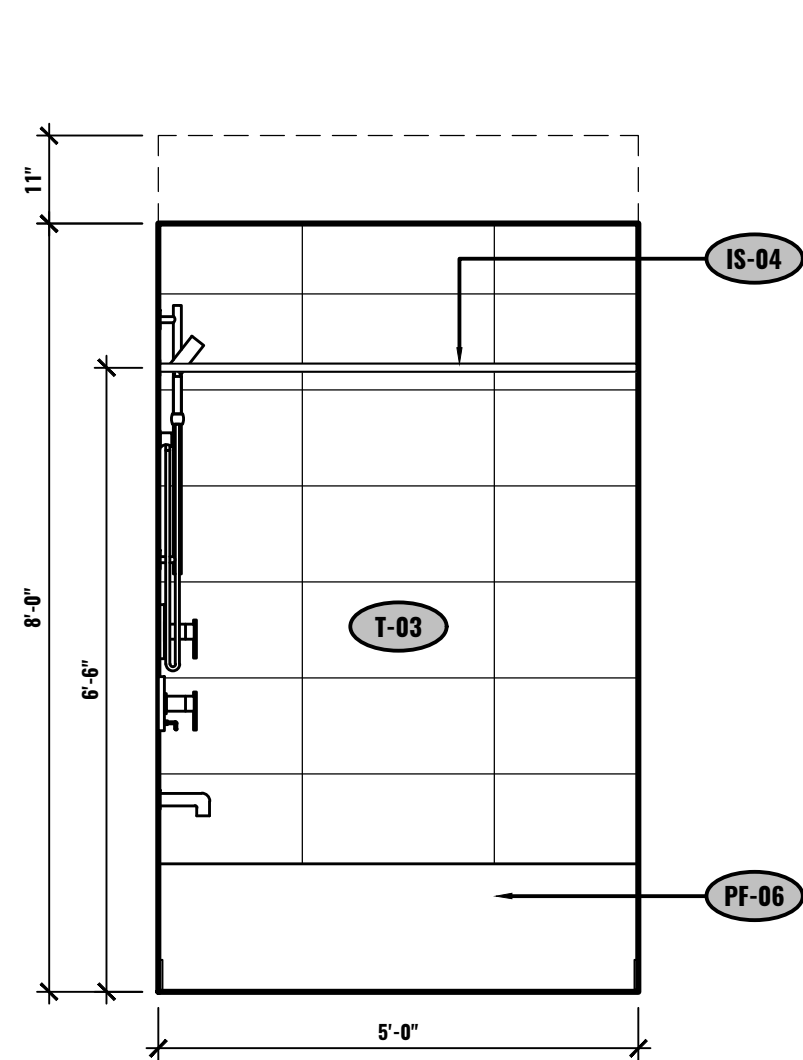


B ELEVATION - BATHROOM
UNIT #2-506
1/2"=1'-0"

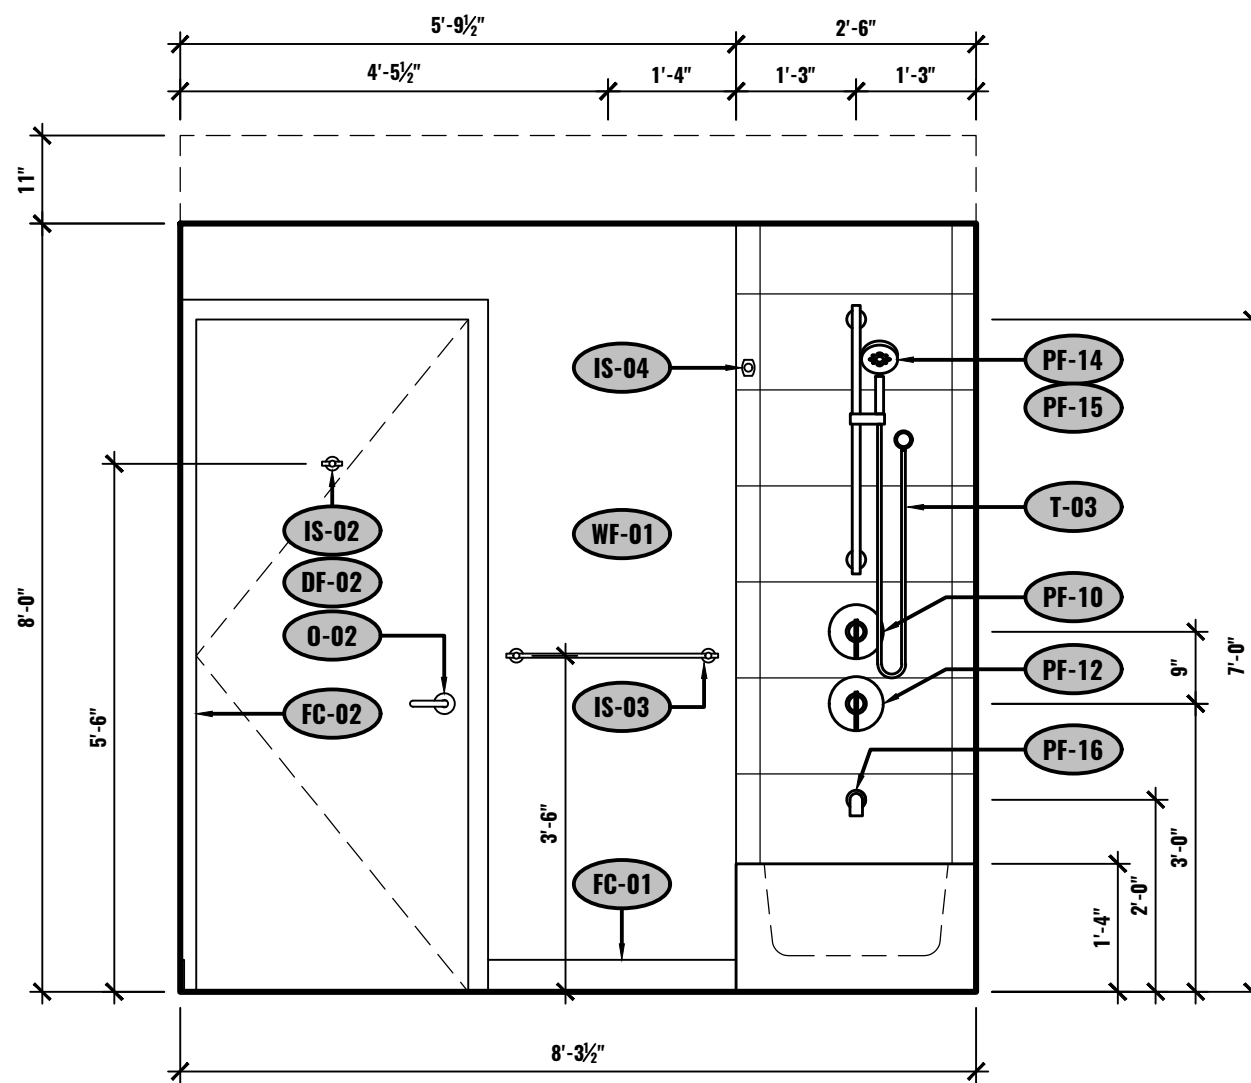


C ELEVATION - BATHROOM
UNIT #2-506
1/2"=1'-0"

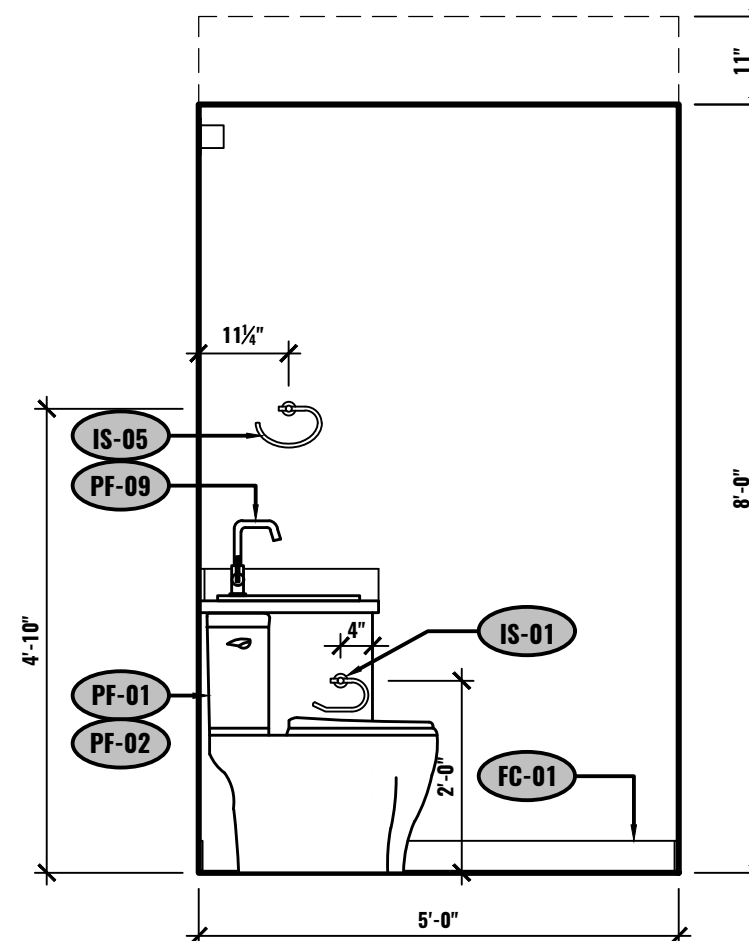


D ELEVATION - BATHROOM
UNIT #2-506
1/2"=1'-0"

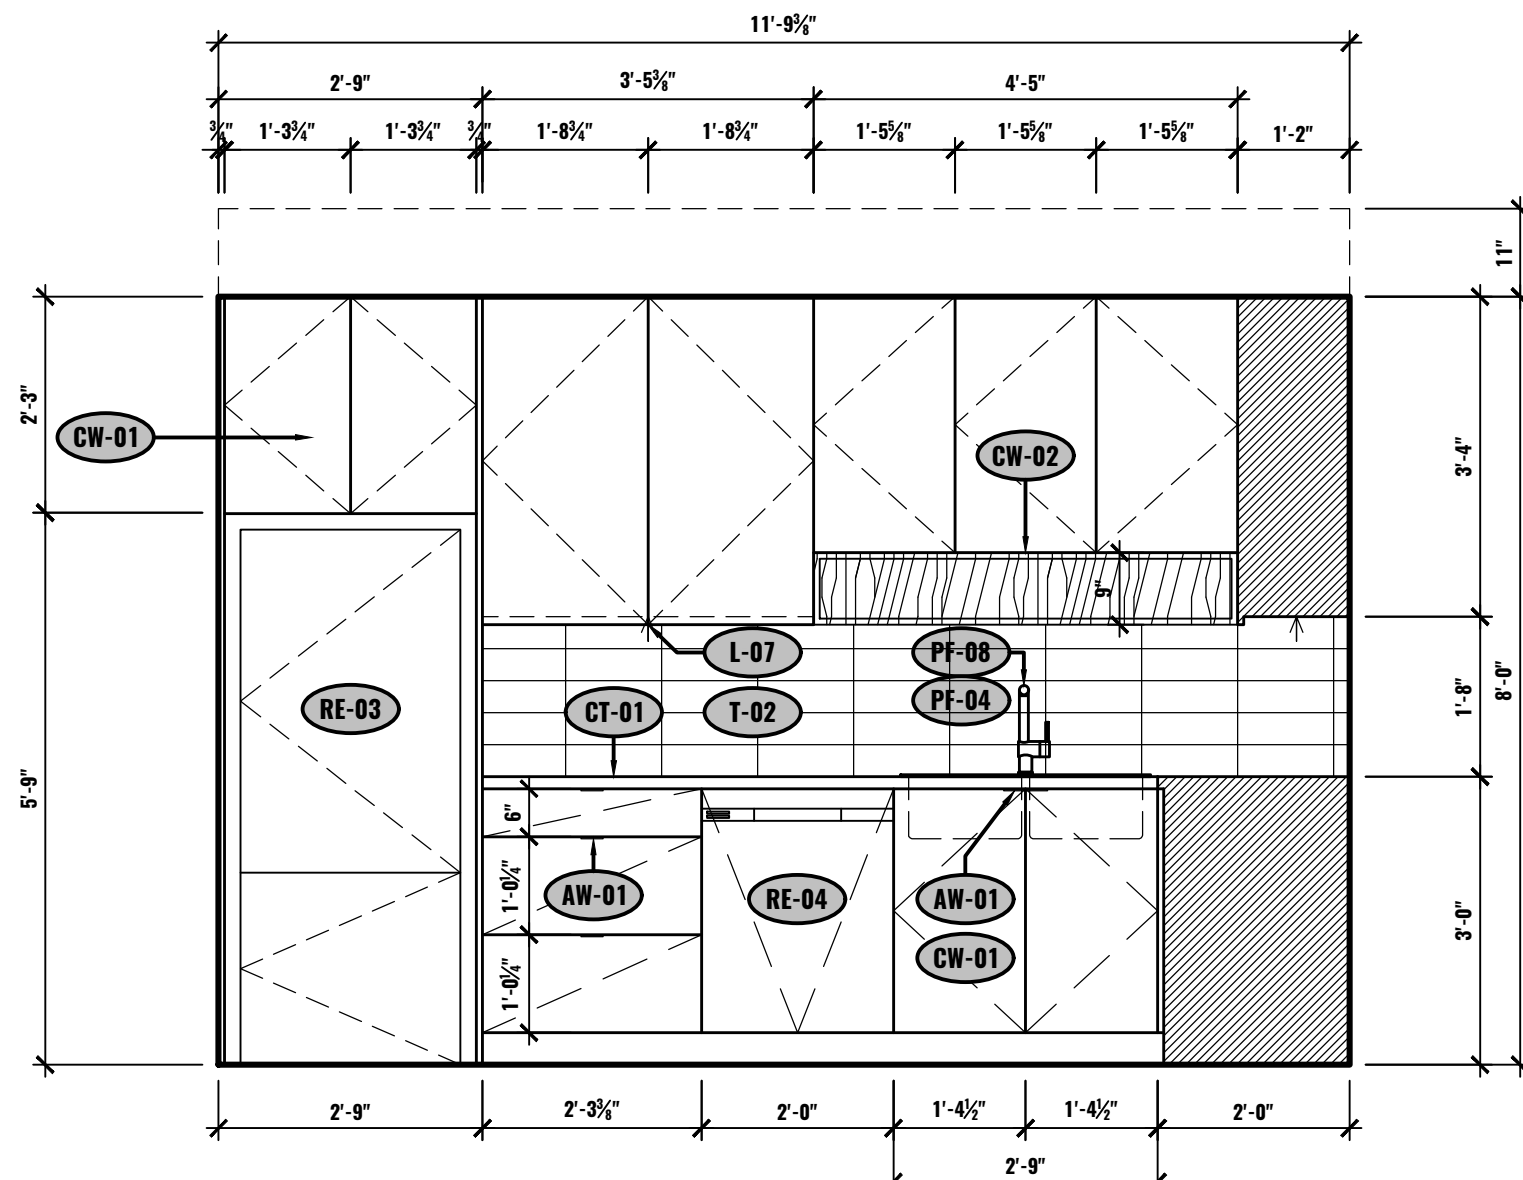


E ELEVATION - KITCHEN
UNIT #2-507
1/2"=1'-0"

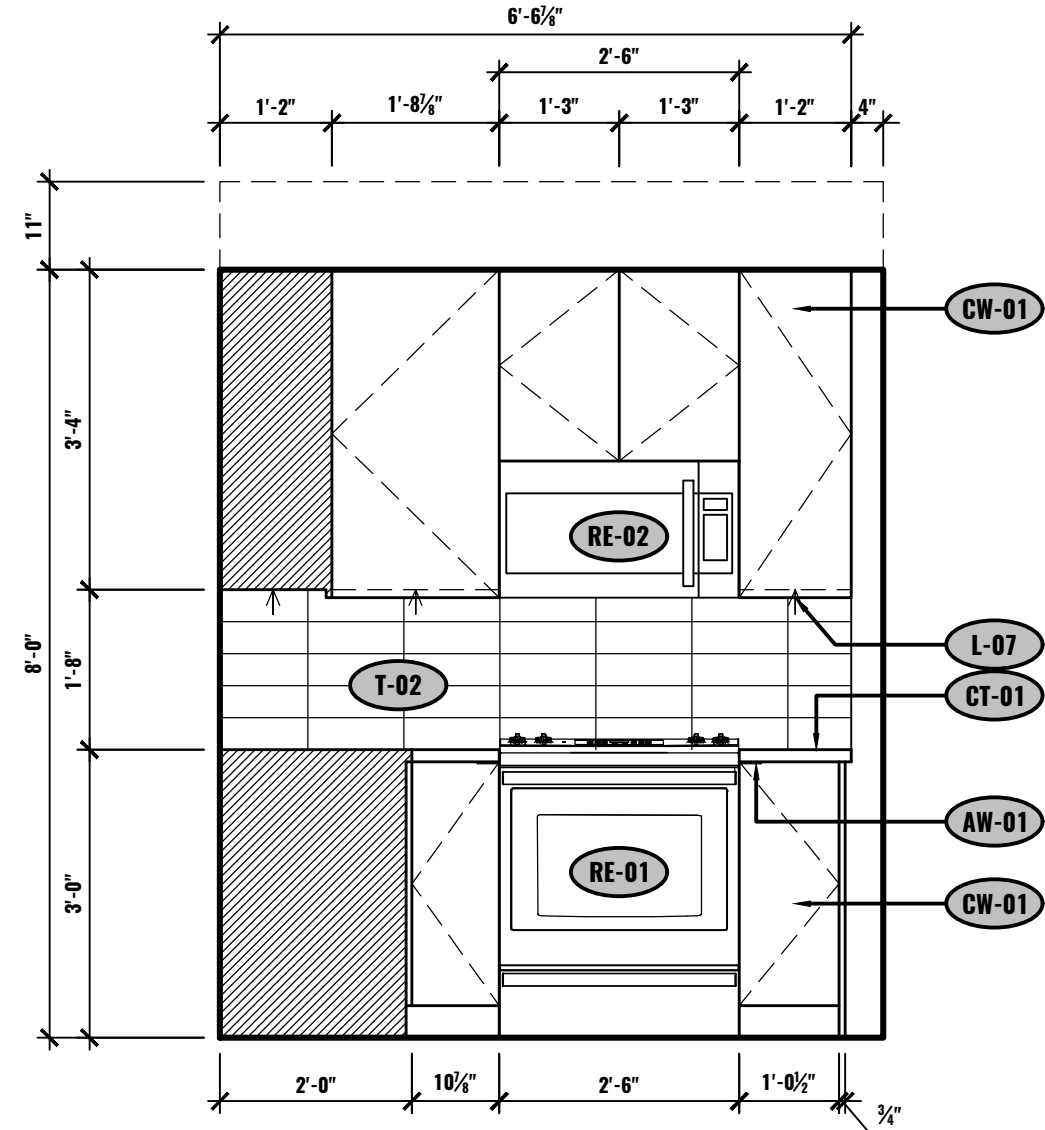


F ELEVATION - KITCHEN
UNIT #2-507
1/2"=1'-0"

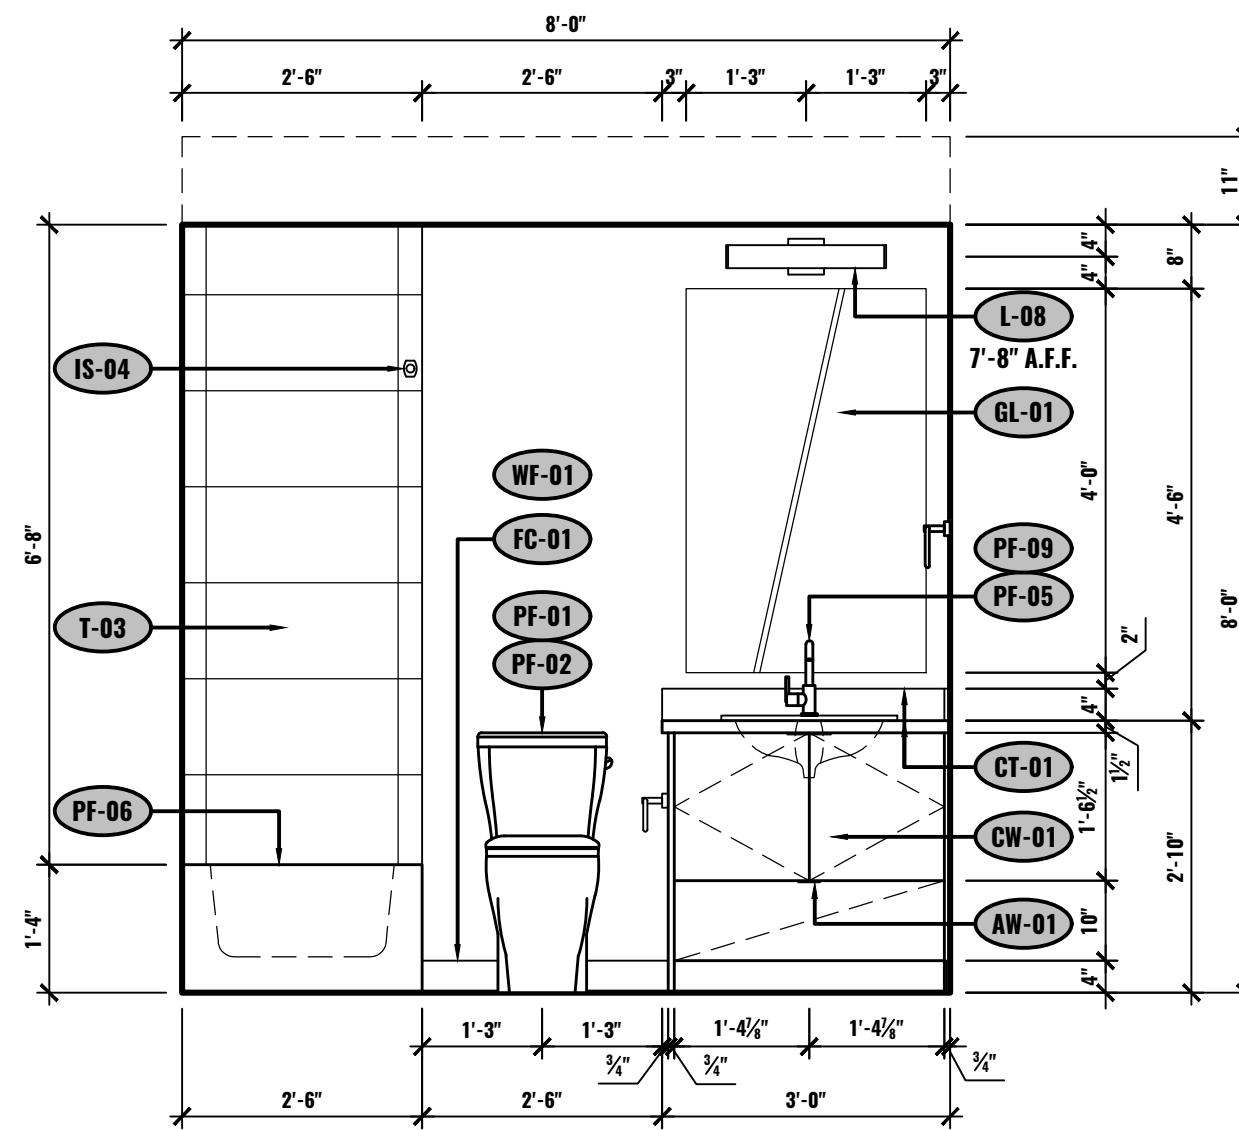


G ELEVATION - BATHROOM
UNIT #2-507
1/2"=1'-0"

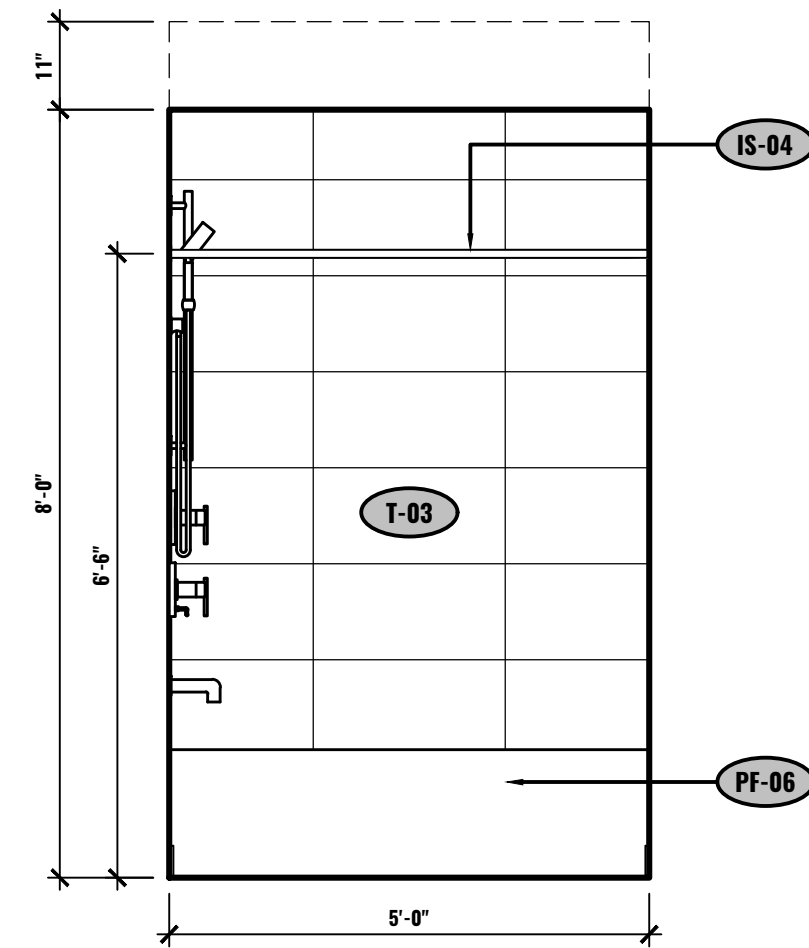


H ELEVATION - BATHROOM
UNIT #2-507
1/2"=1'-0"

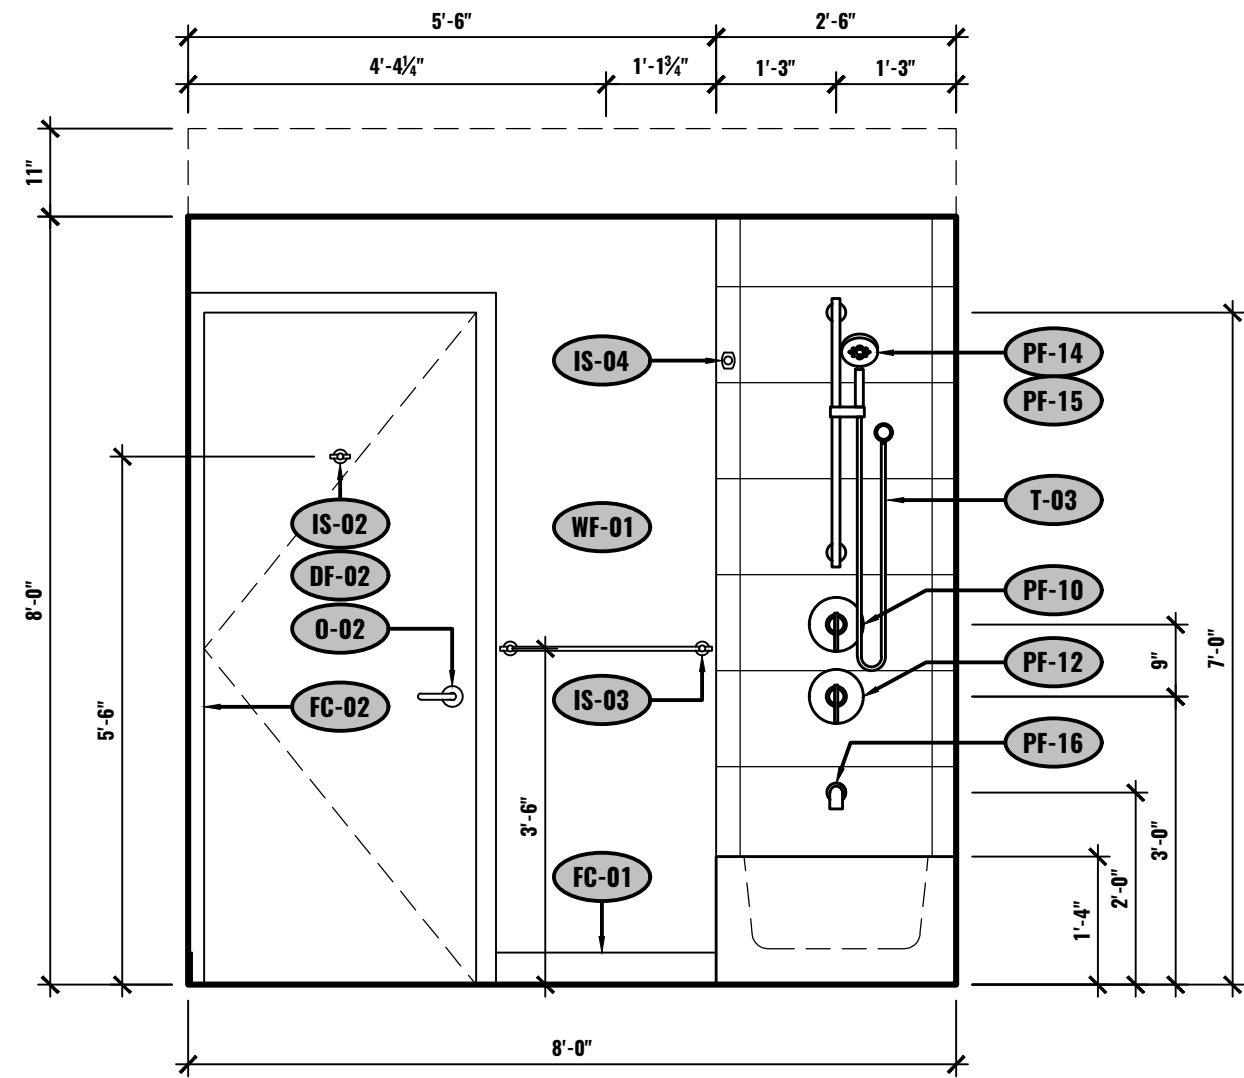


I ELEVATION - BATHROOM
UNIT #2-507
1/2"=1'-0"

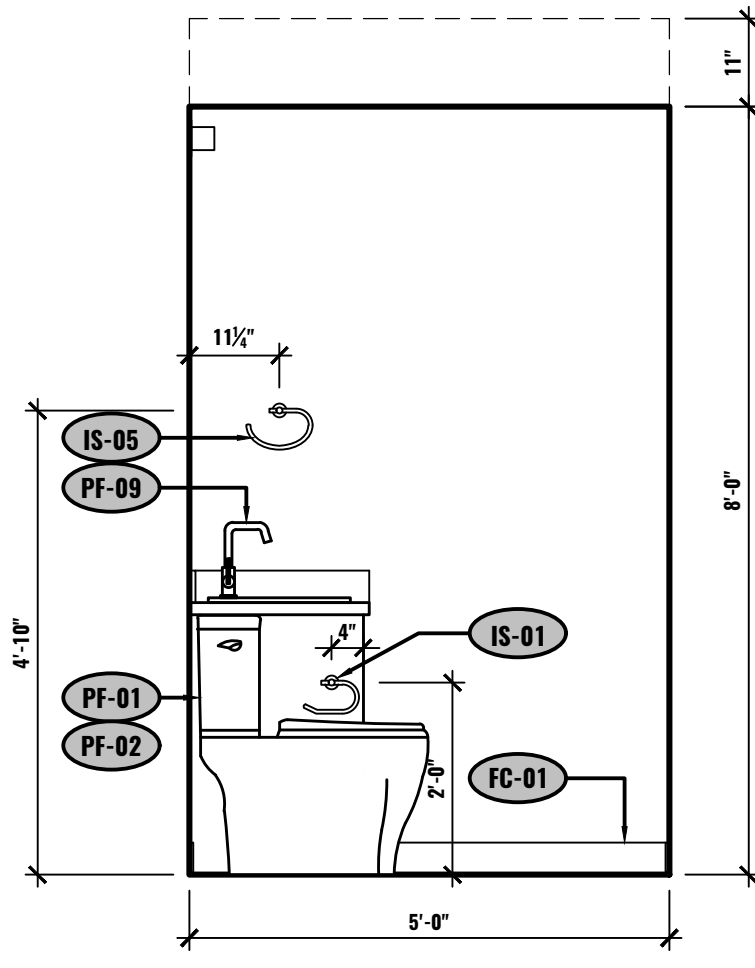


K ELEVATION - BATHROOM
UNIT #2-507
1/2"=1'-0"

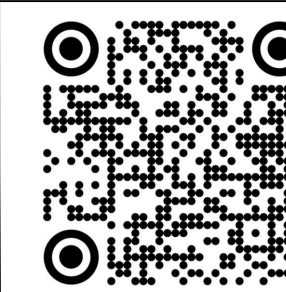


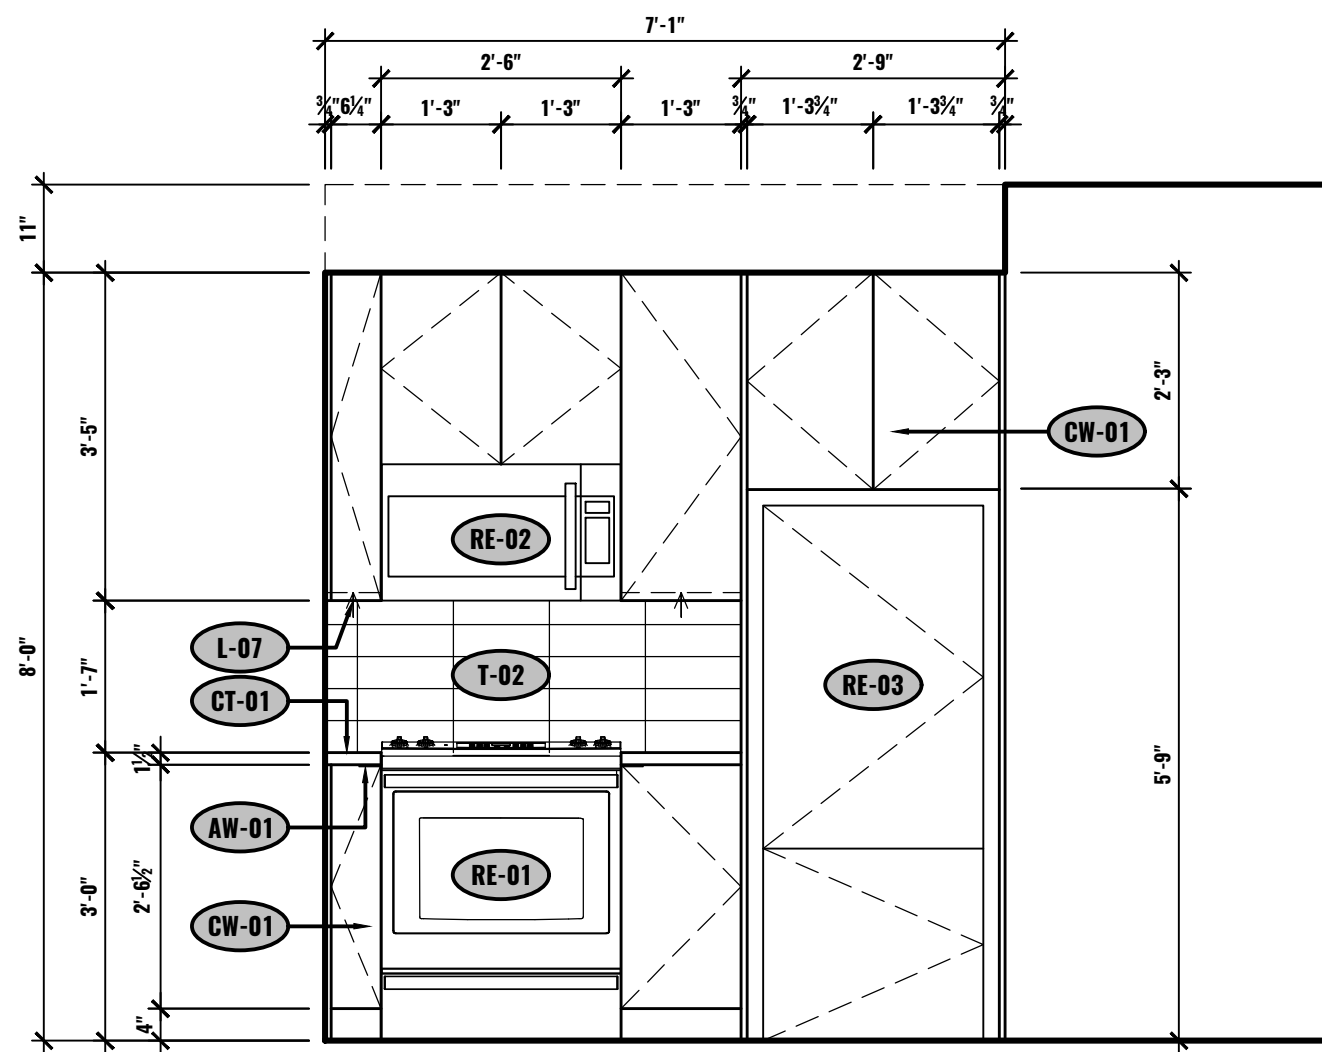


A ELEVATION - KITCHEN
UNIT #601
1/2"=1'-0"

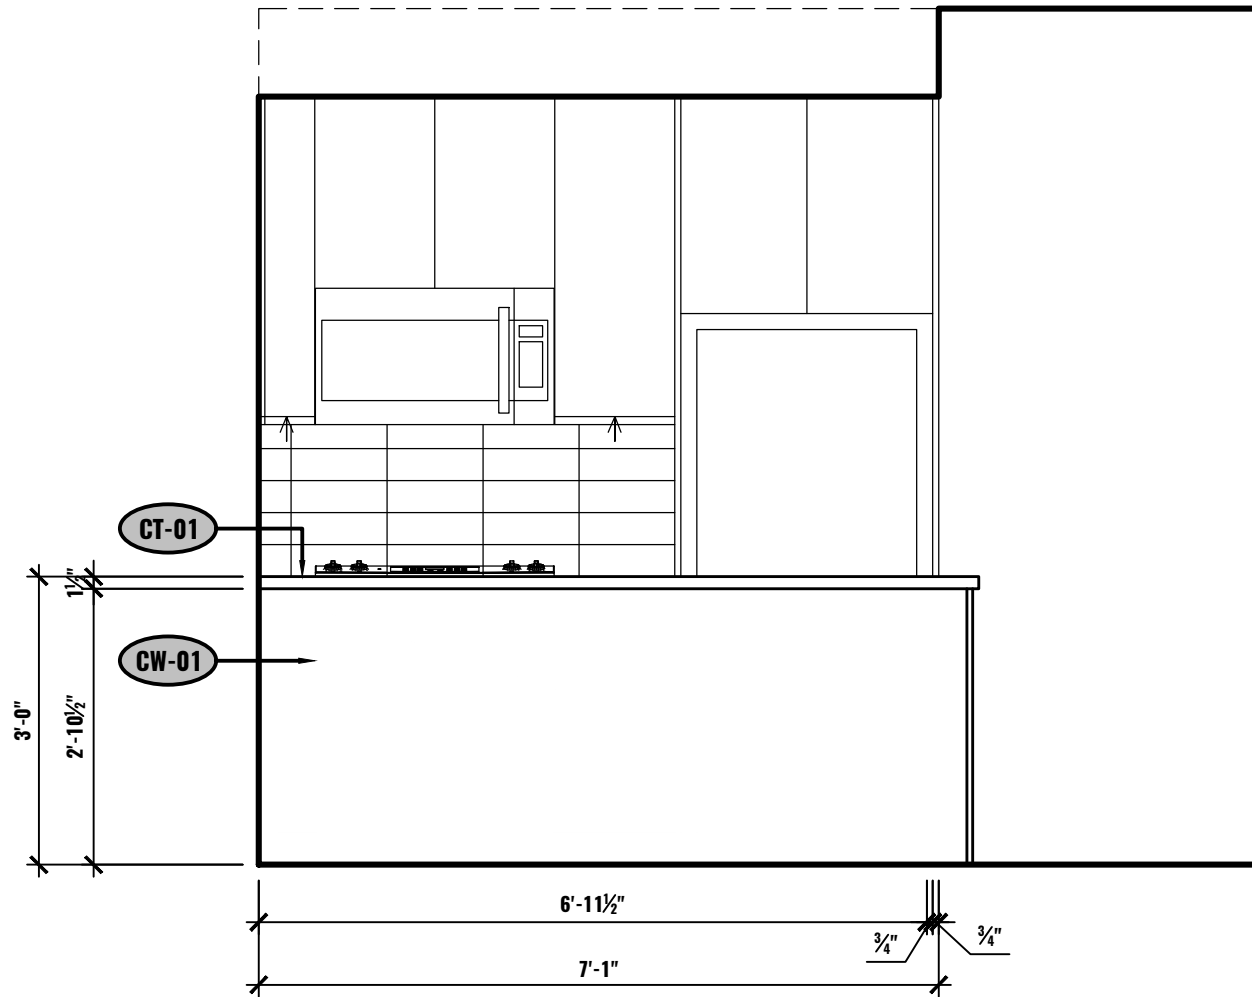


B ELEVATION - KITCHEN
UNIT #601
1/2"=1'-0"

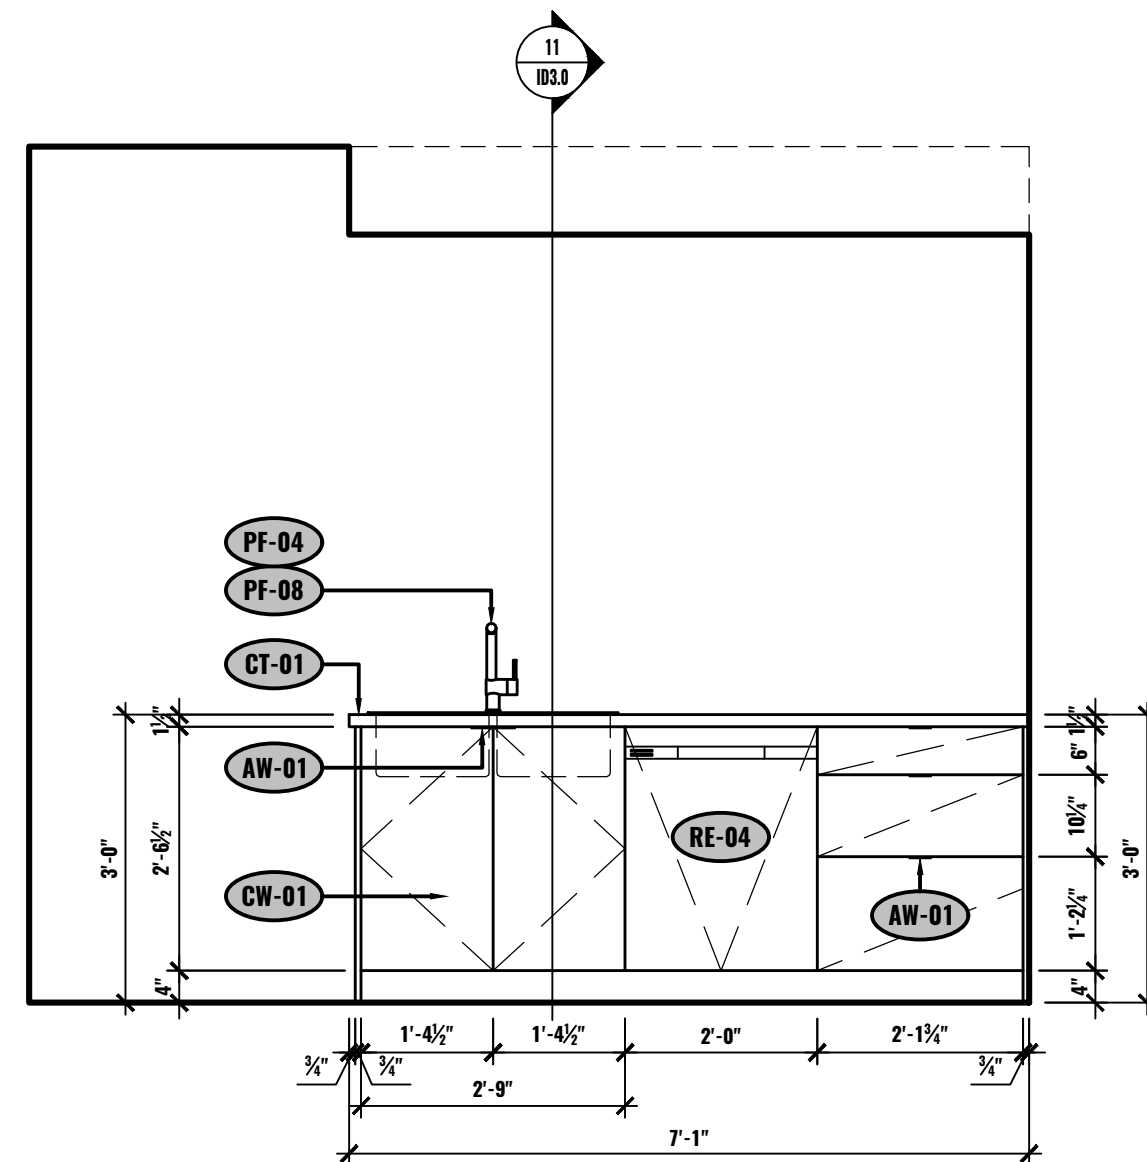


C ELEVATION - KITCHEN
UNIT #601
1/2"=1'-0"

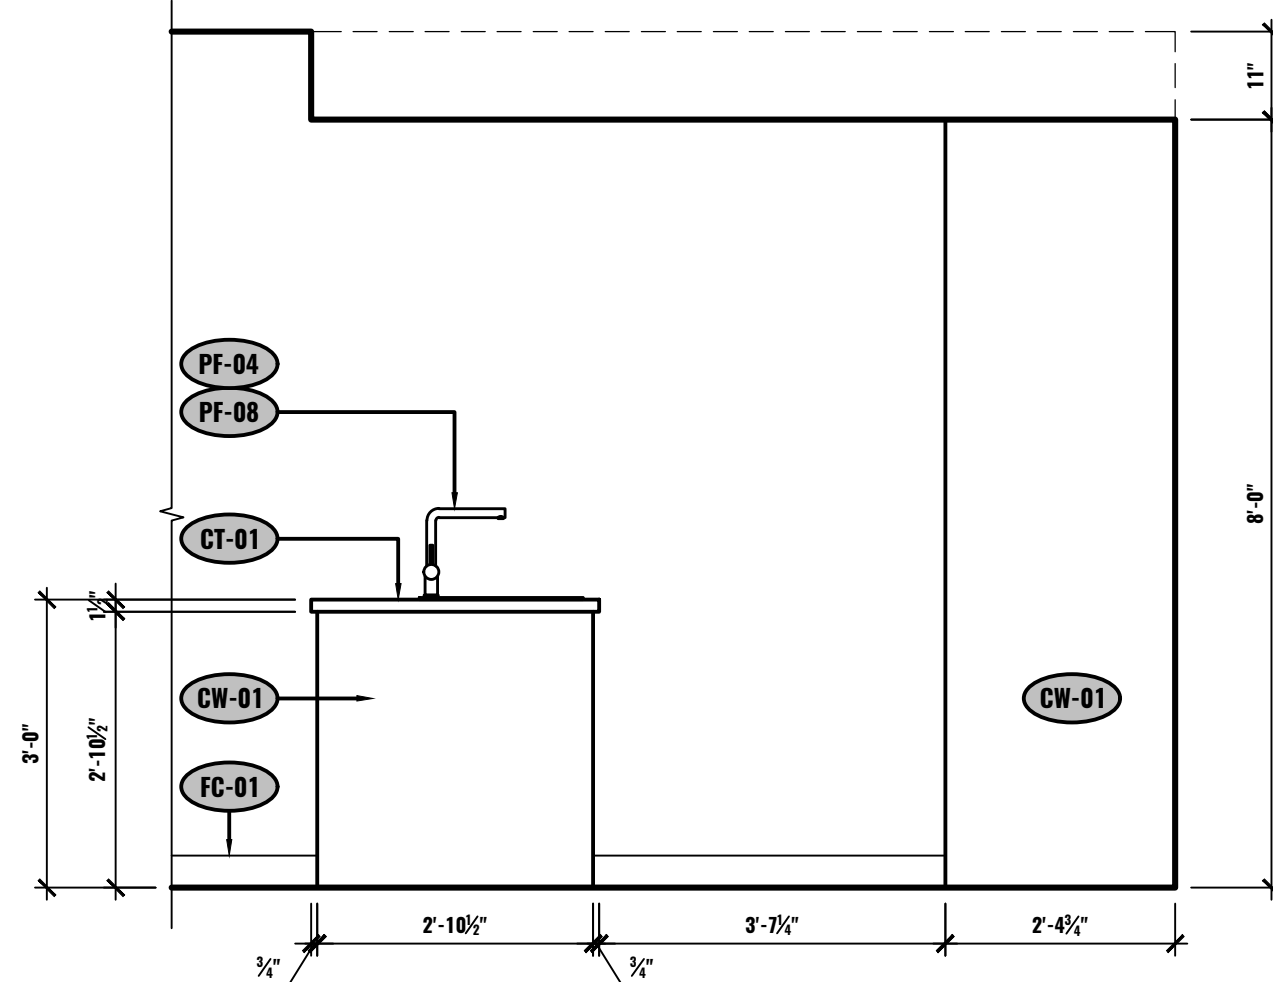


D ELEVATION - KITCHEN
UNIT #601
1/2"=1'-0"

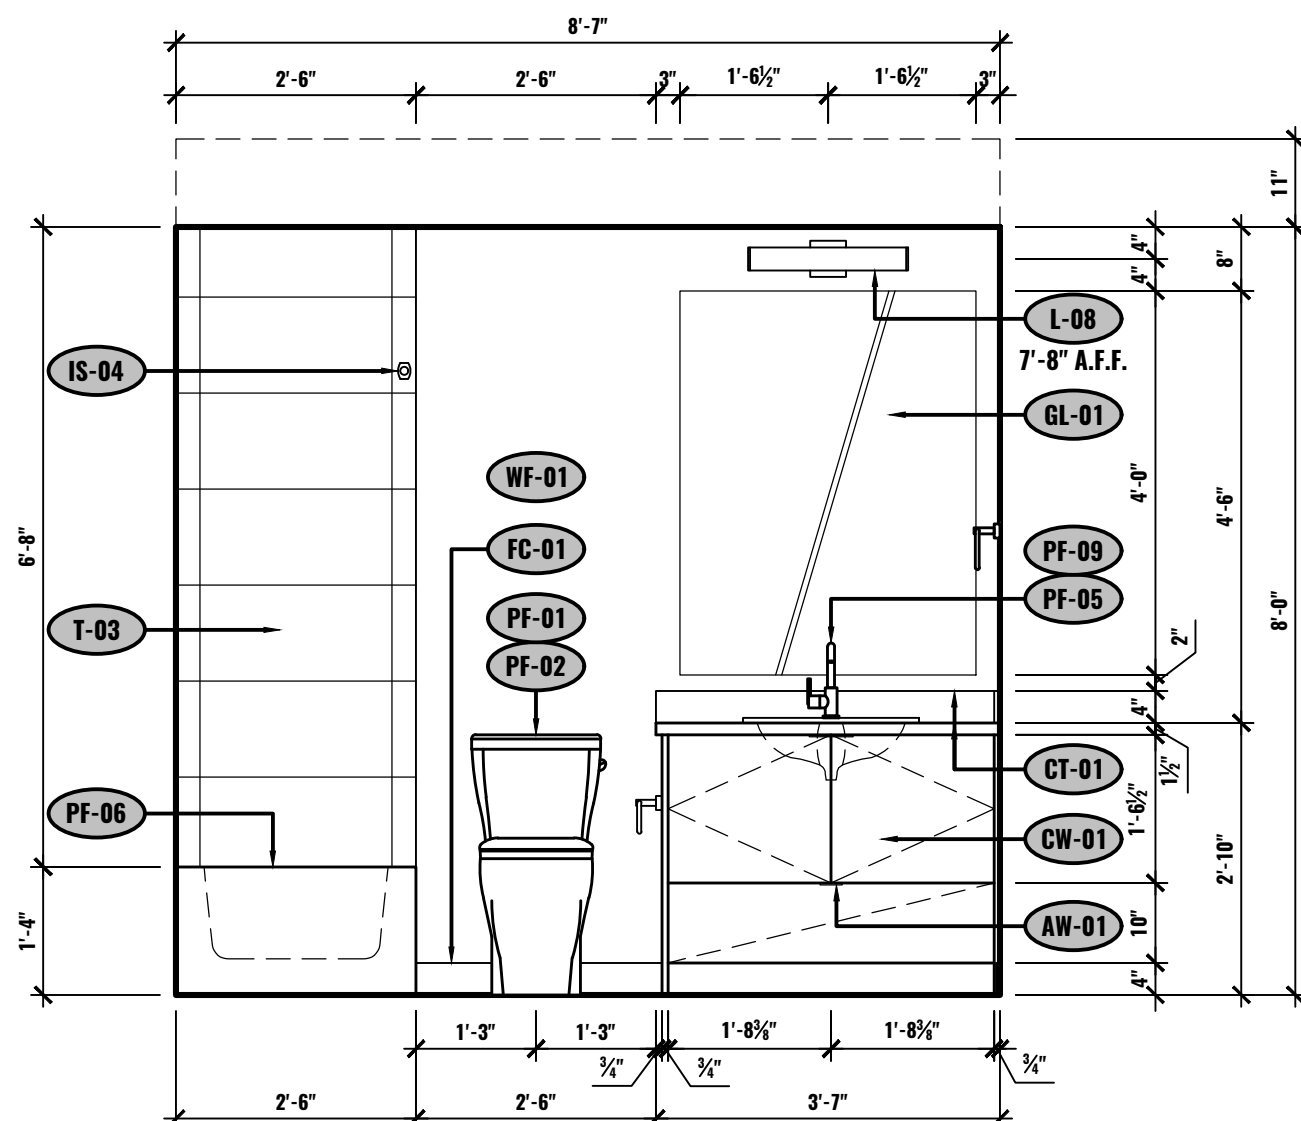


E ELEVATION - BATHROOM
UNIT #601
1/2"=1'-0"

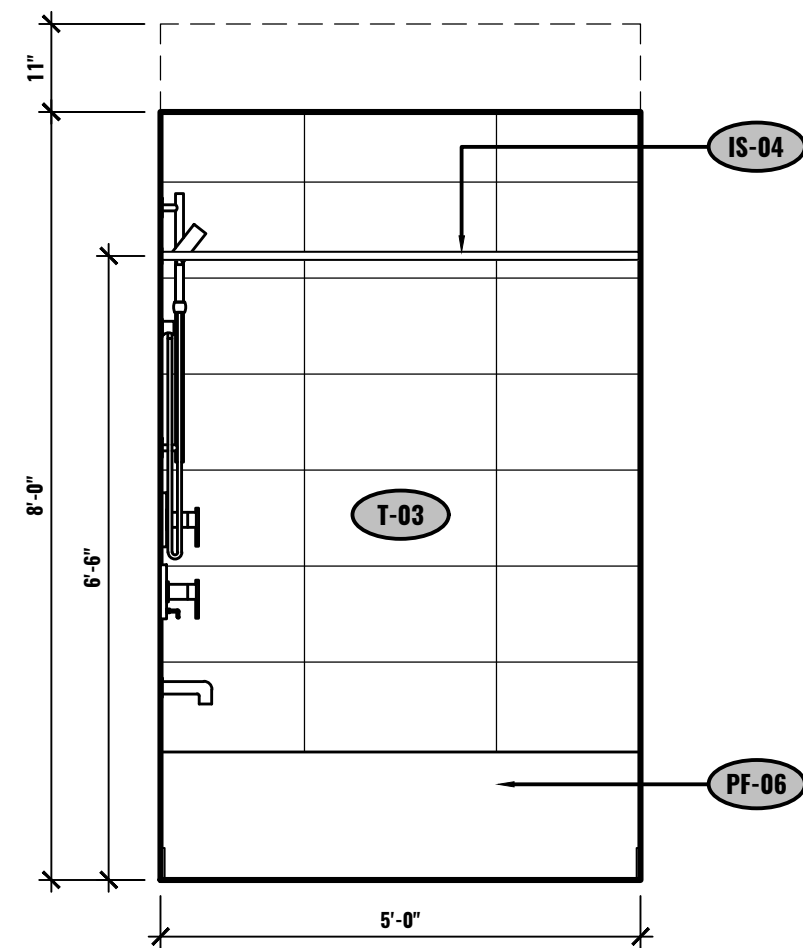


F ELEVATION - BATHROOM
UNIT #601
1/2"=1'-0"

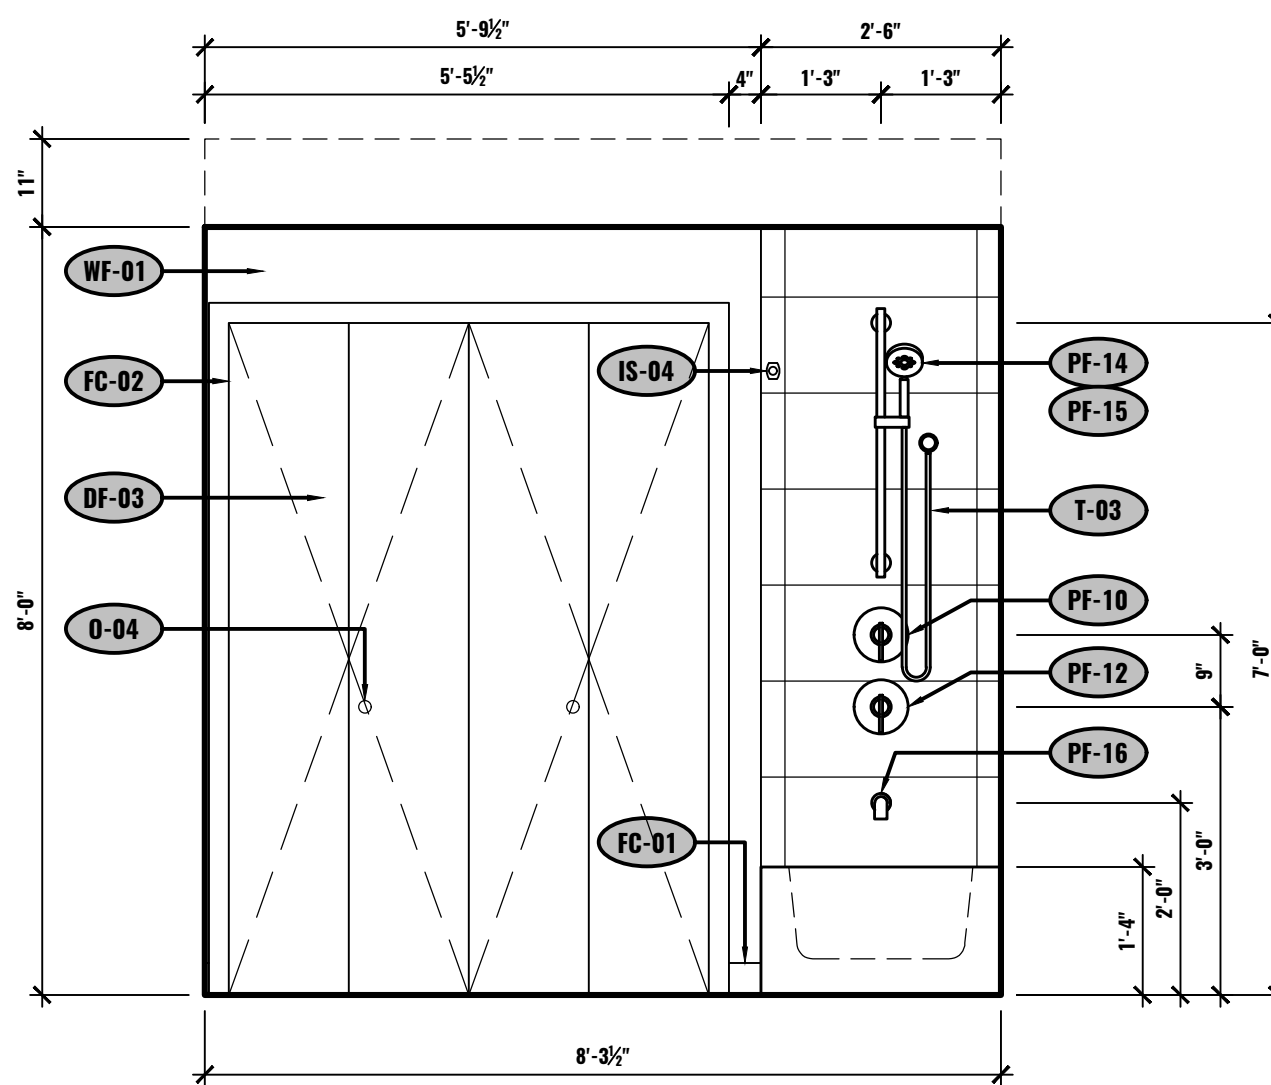


G ELEVATION - BATHROOM
UNIT #601
1/2"=1'-0"

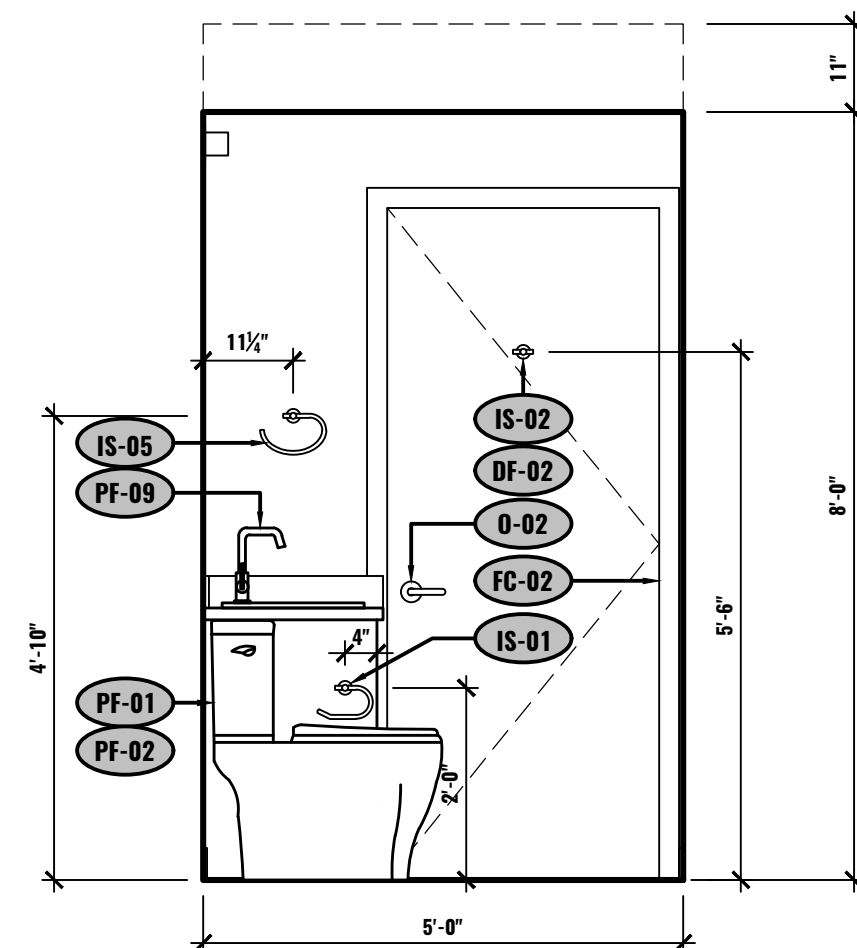


H ELEVATION - BATHROOM
UNIT #601
1/2"=1'-0"

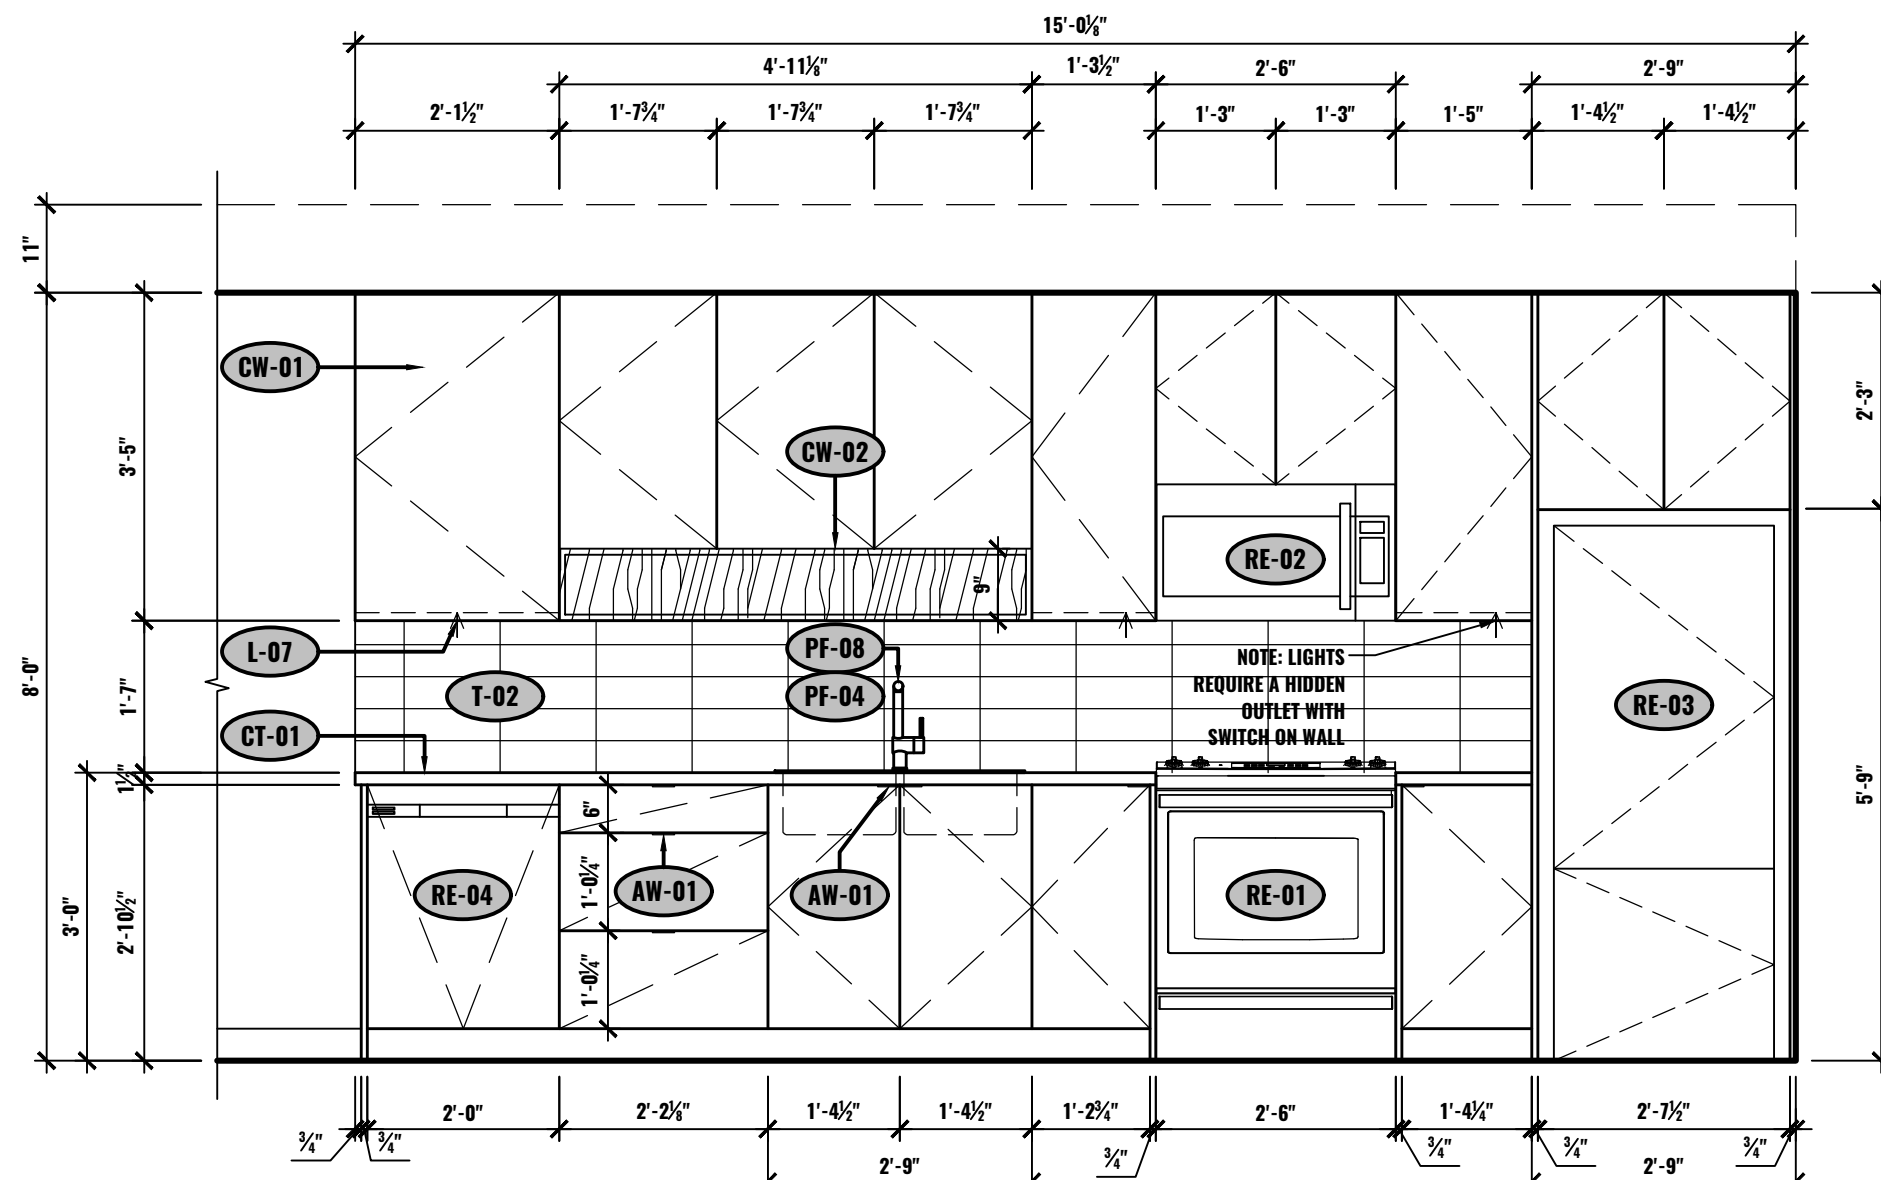


J ELEVATION - KITCHEN
UNIT #602
1/2"=1'-0"

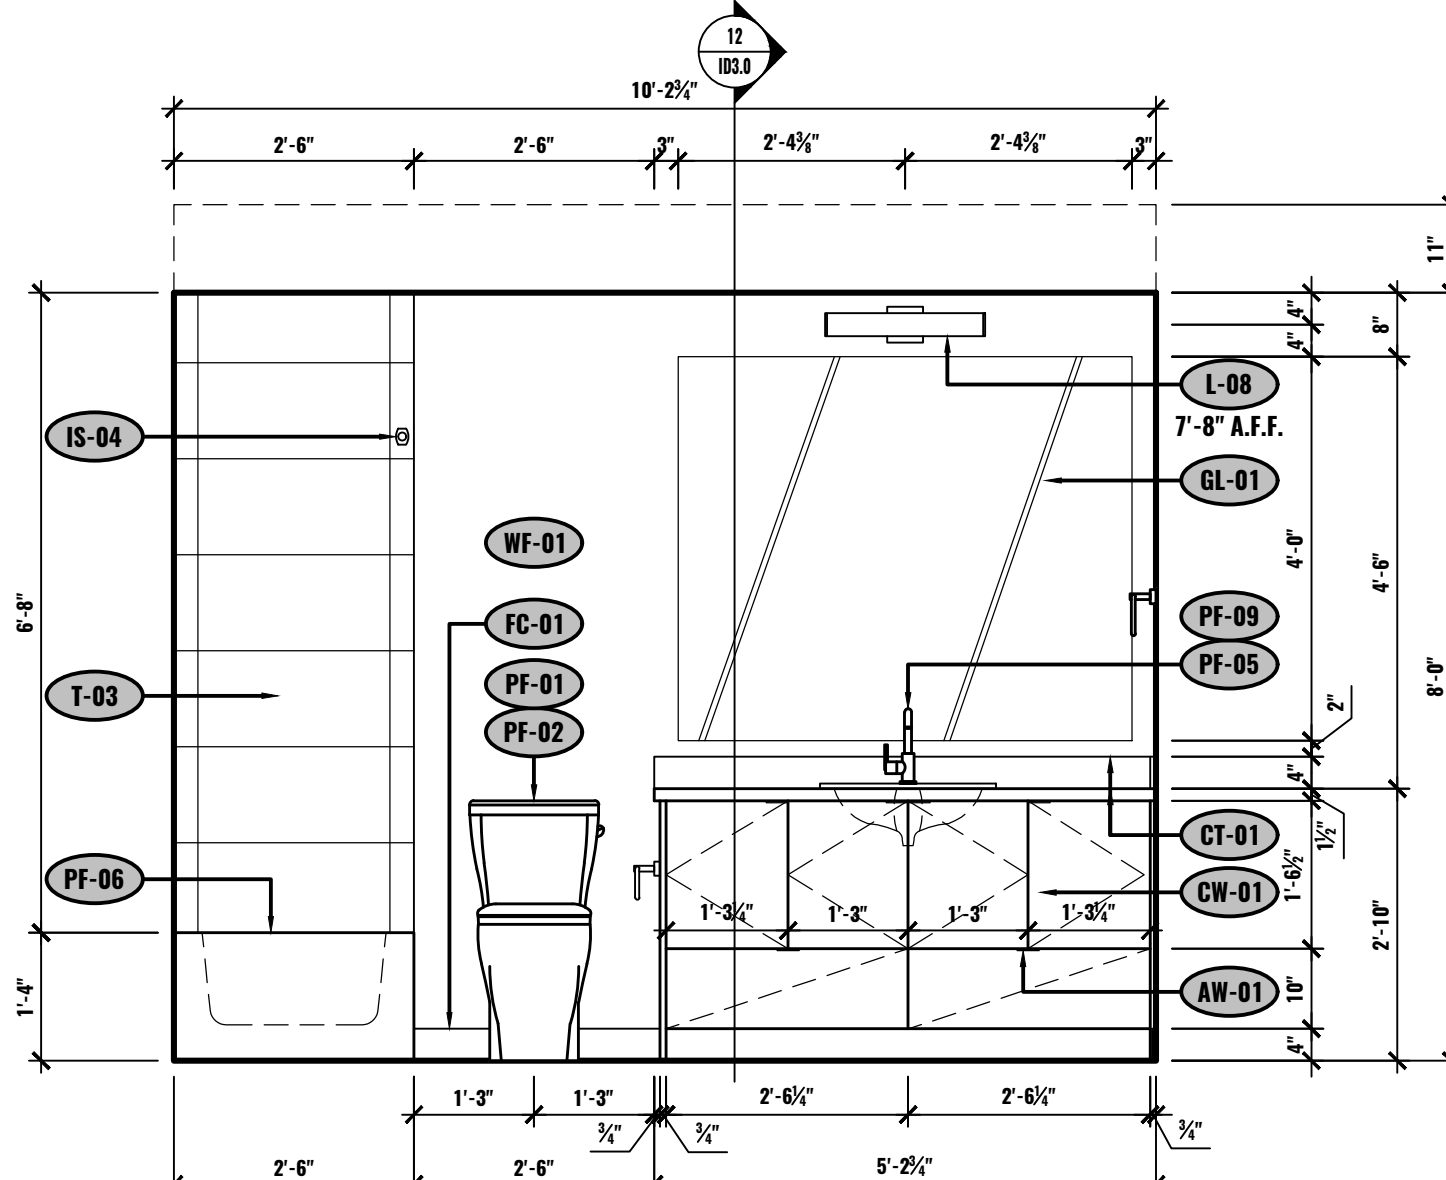


K ELEVATION - BATHROOM
UNIT #602
1/2"=1'-0"

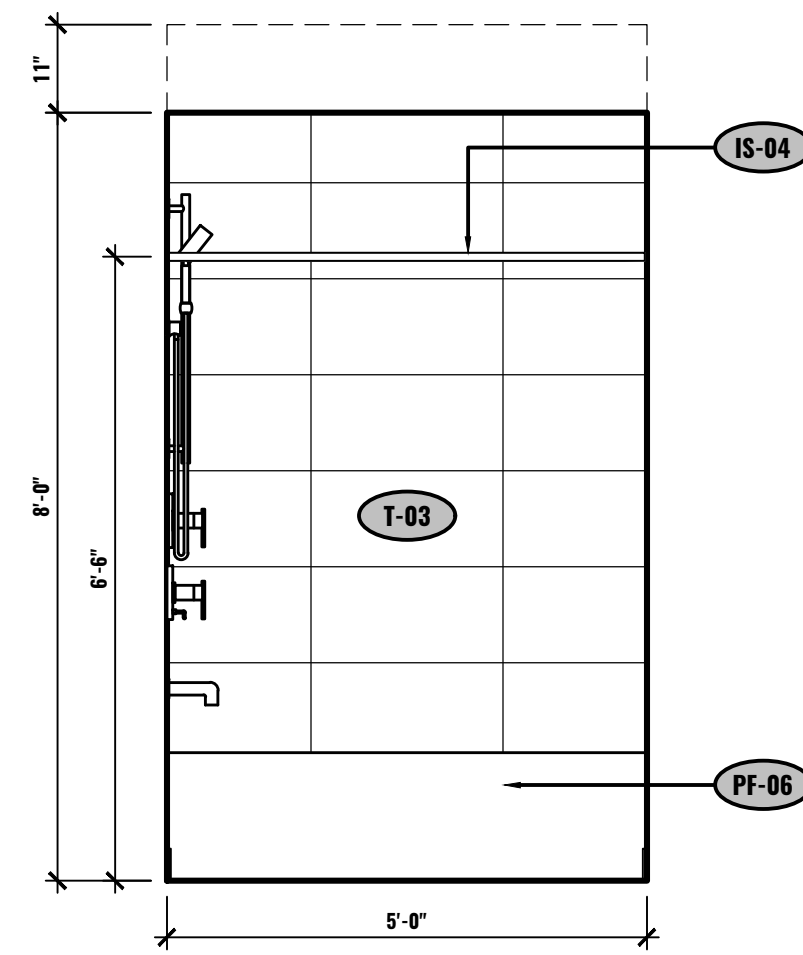


L ELEVATION - BATHROOM
UNIT #602
1/2"=1'-0"

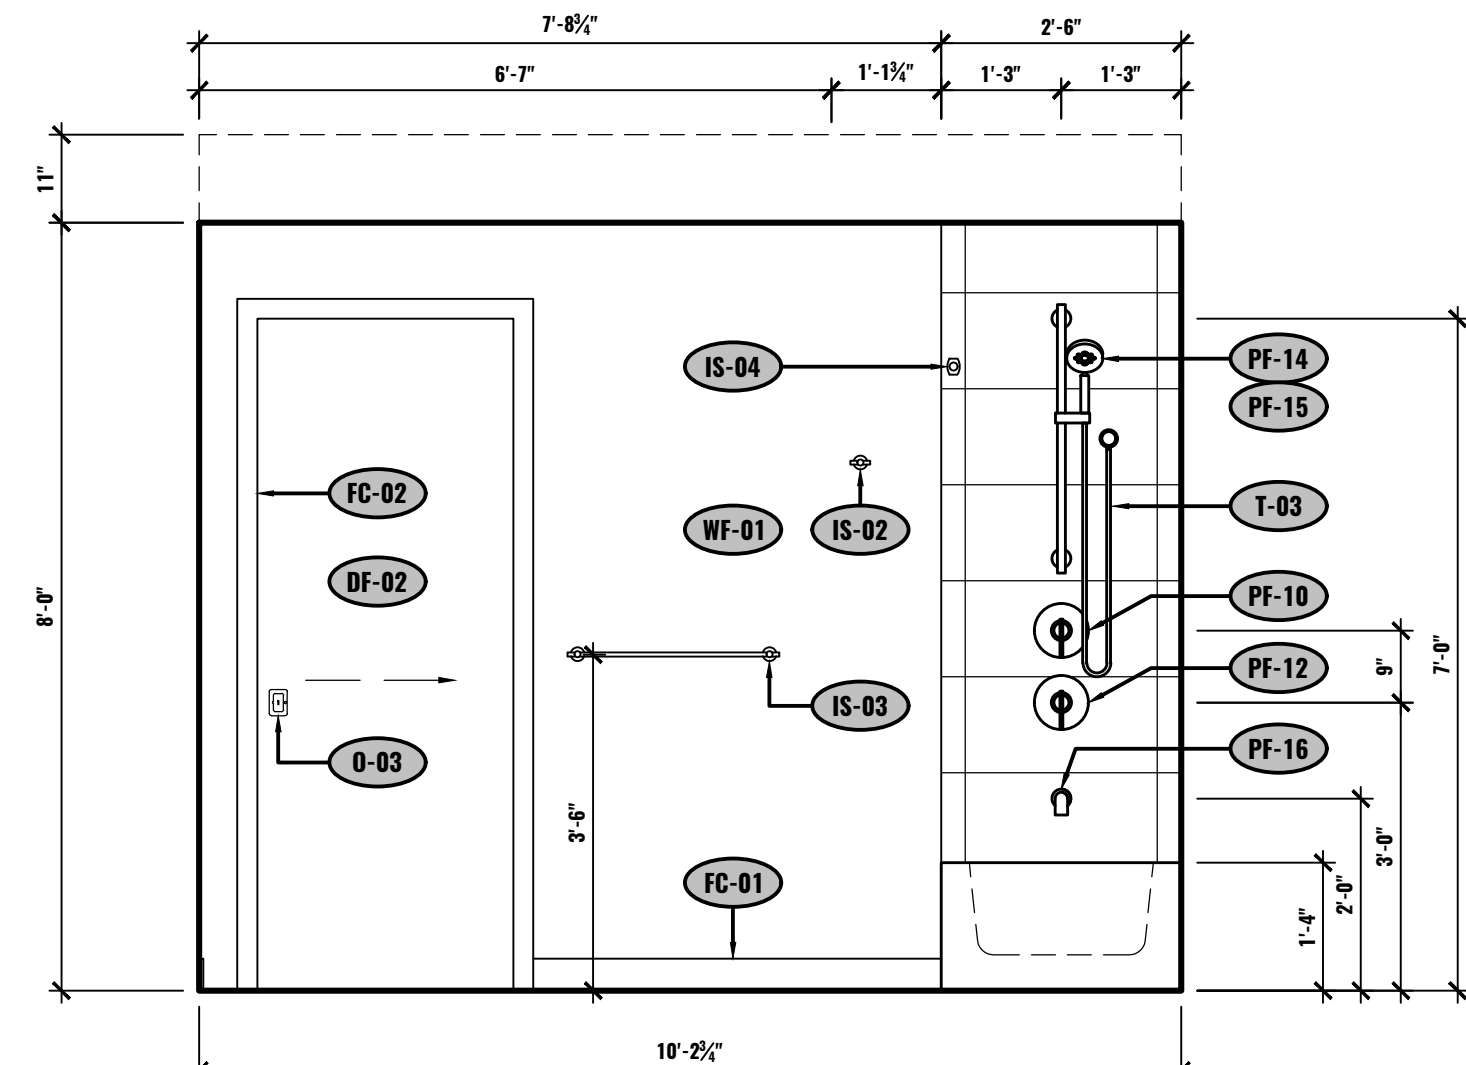


M ELEVATION - BATHROOM
UNIT #602
1/2"=1'-0"

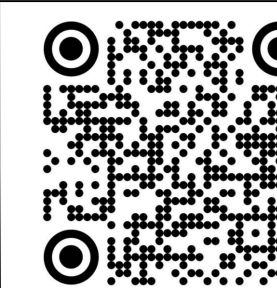


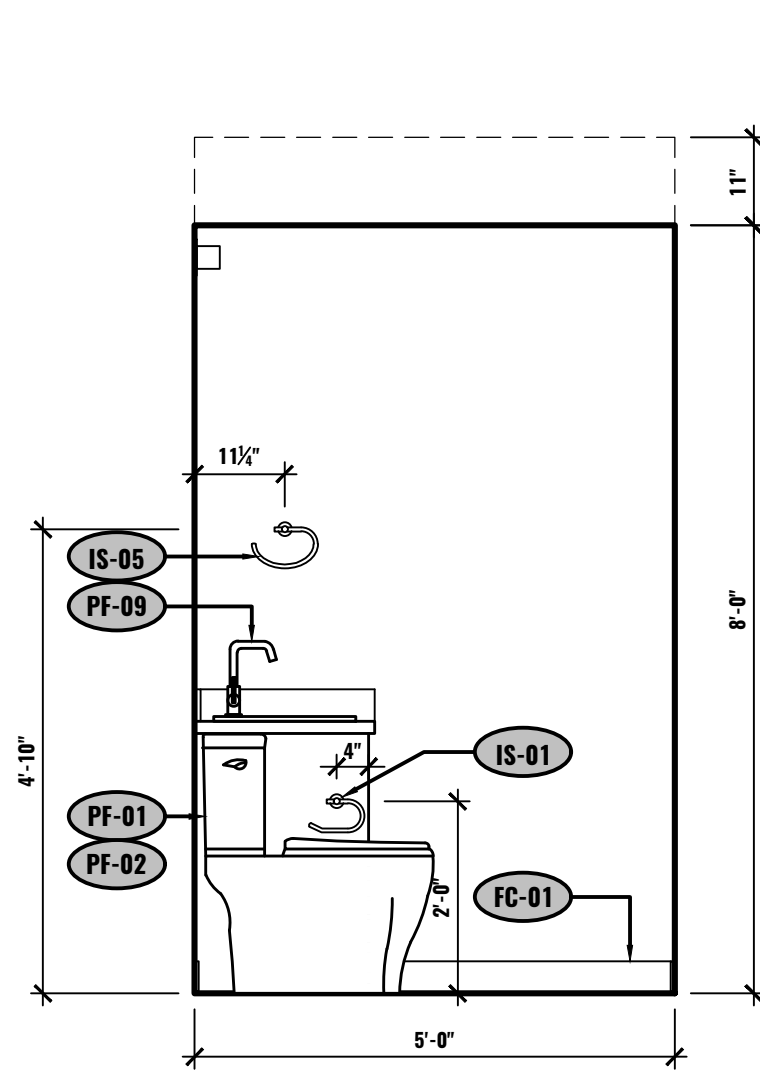


A ELEVATION - BATHROOM
UNIT #602
1/2"=1'-0"

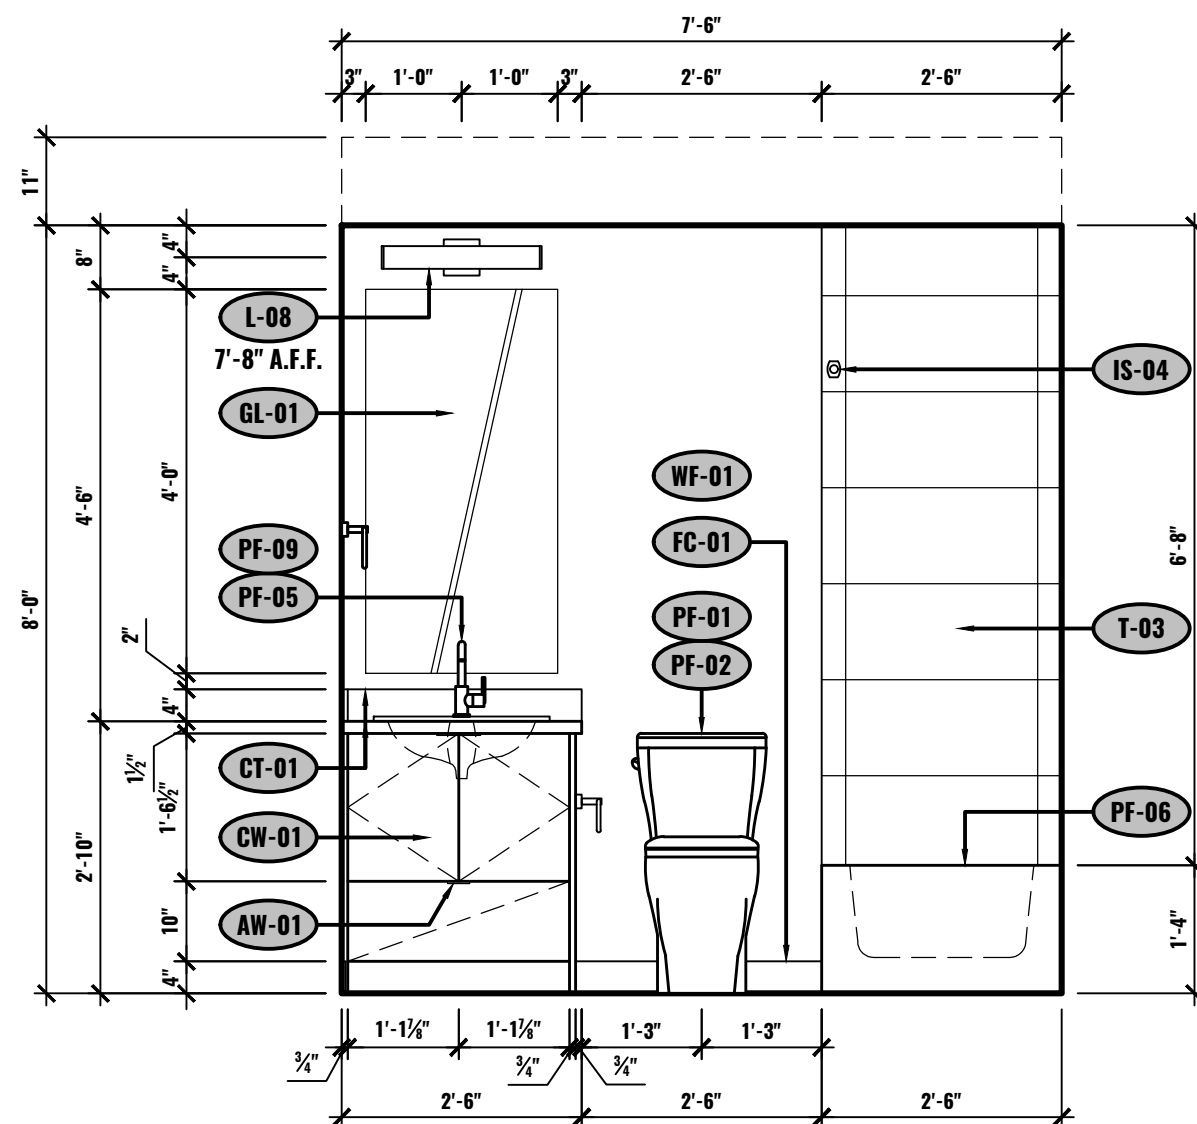


B ELEVATION - BATHROOM
UNIT #602
1/2"=1'-0"

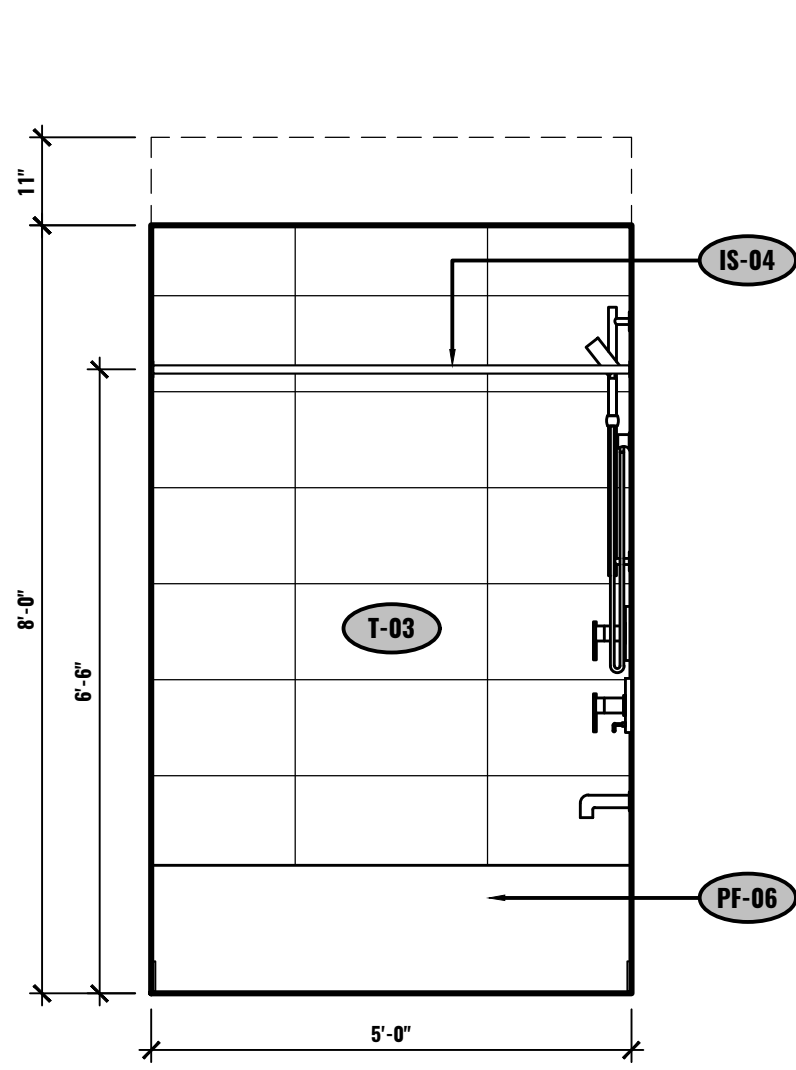


C ELEVATION - BATHROOM
UNIT #602
1/2"=1'-0"

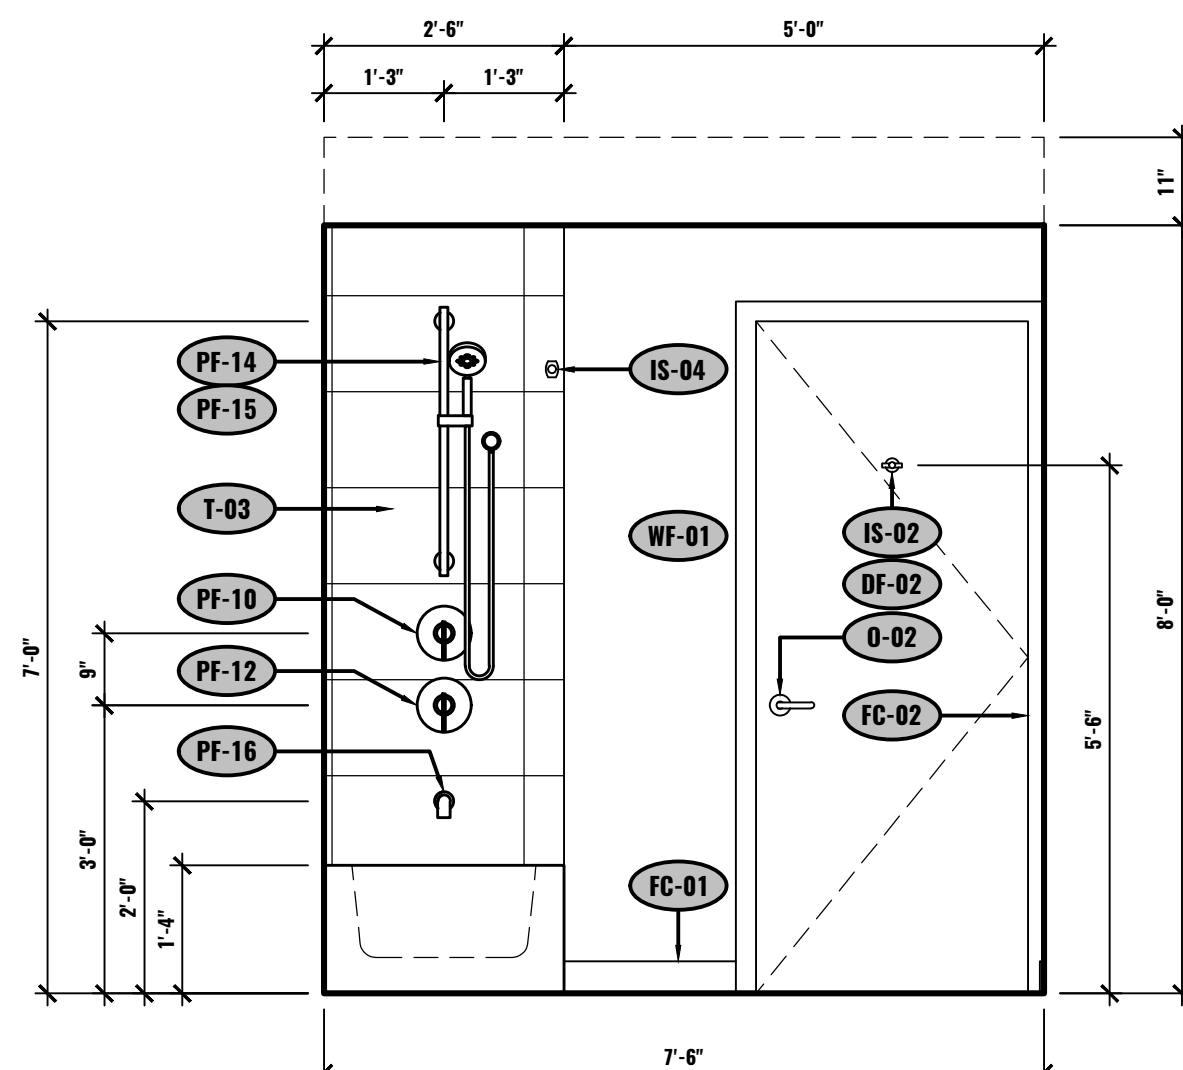


D ELEVATION - BATHROOM
UNIT #602
1/2"=1'-0"

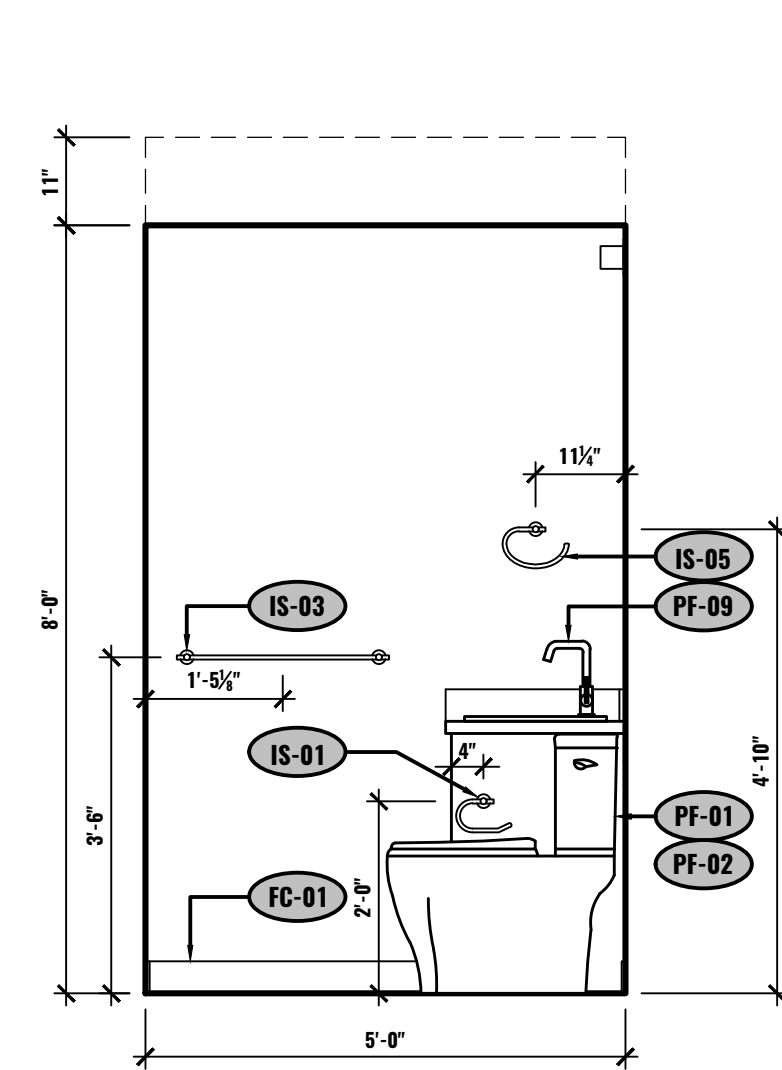


E ELEVATION - BATHROOM
UNIT #602
1/2"=1'-0"

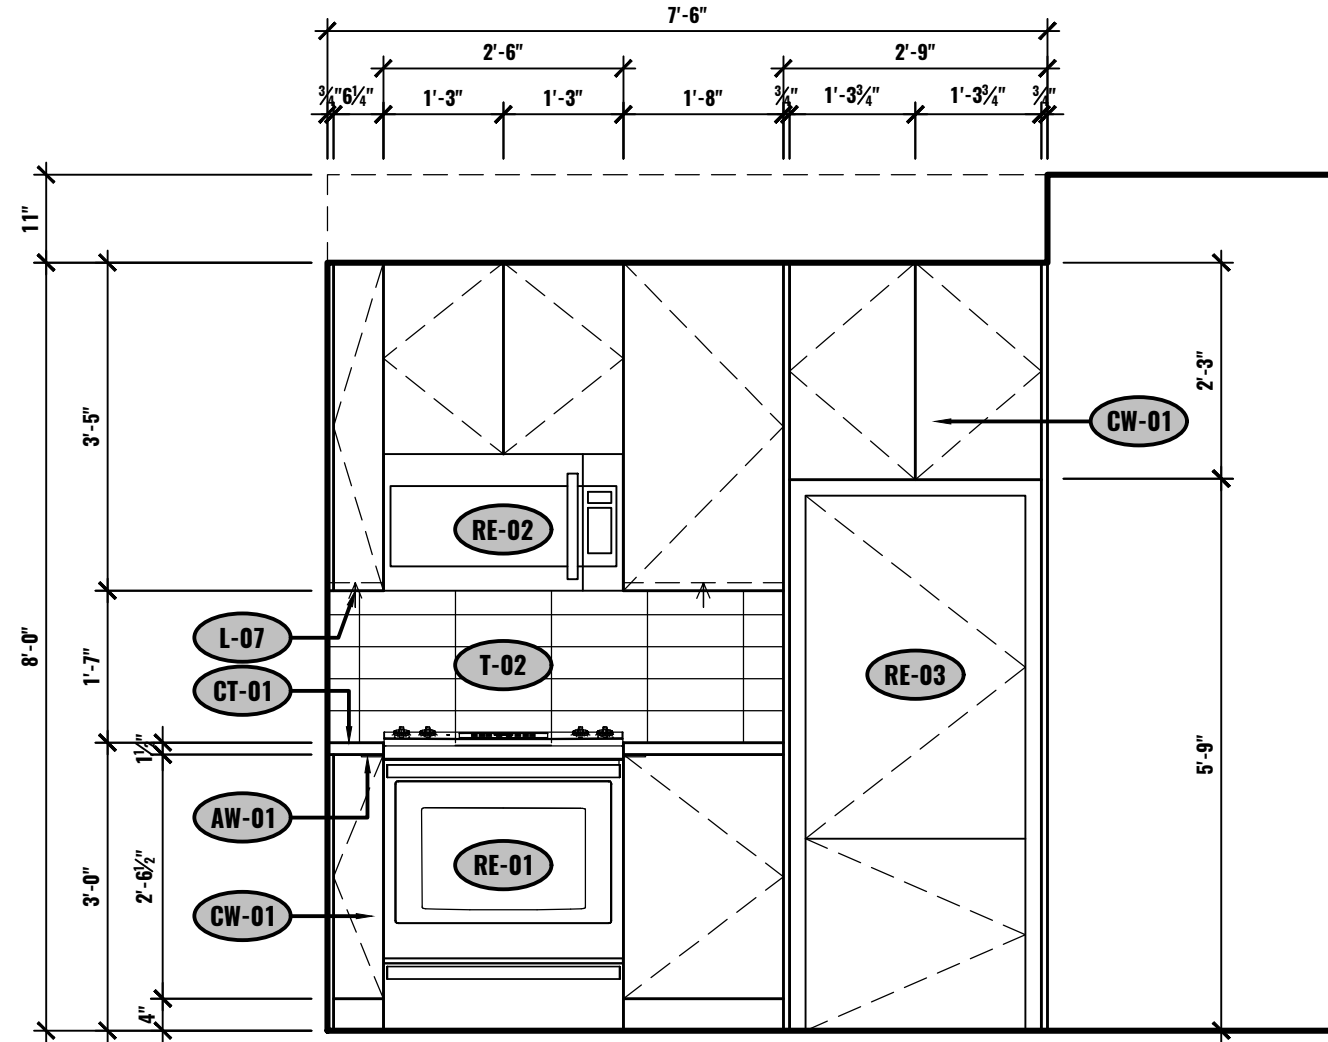


F ELEVATION - KITCHEN
UNIT #603
1/2"=1'-0"

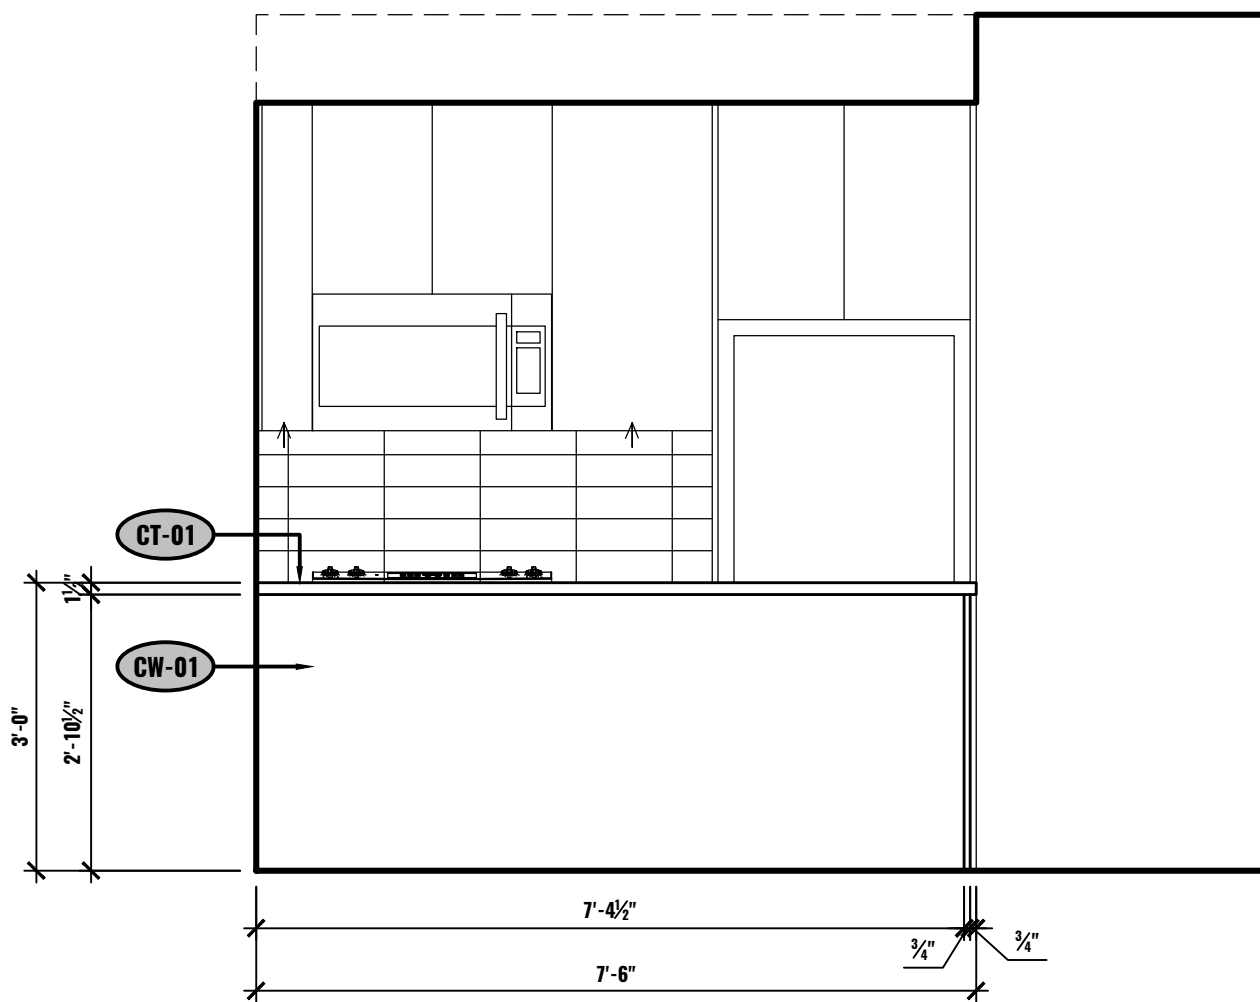


G ELEVATION - KITCHEN
UNIT #603
1/2"=1'-0"

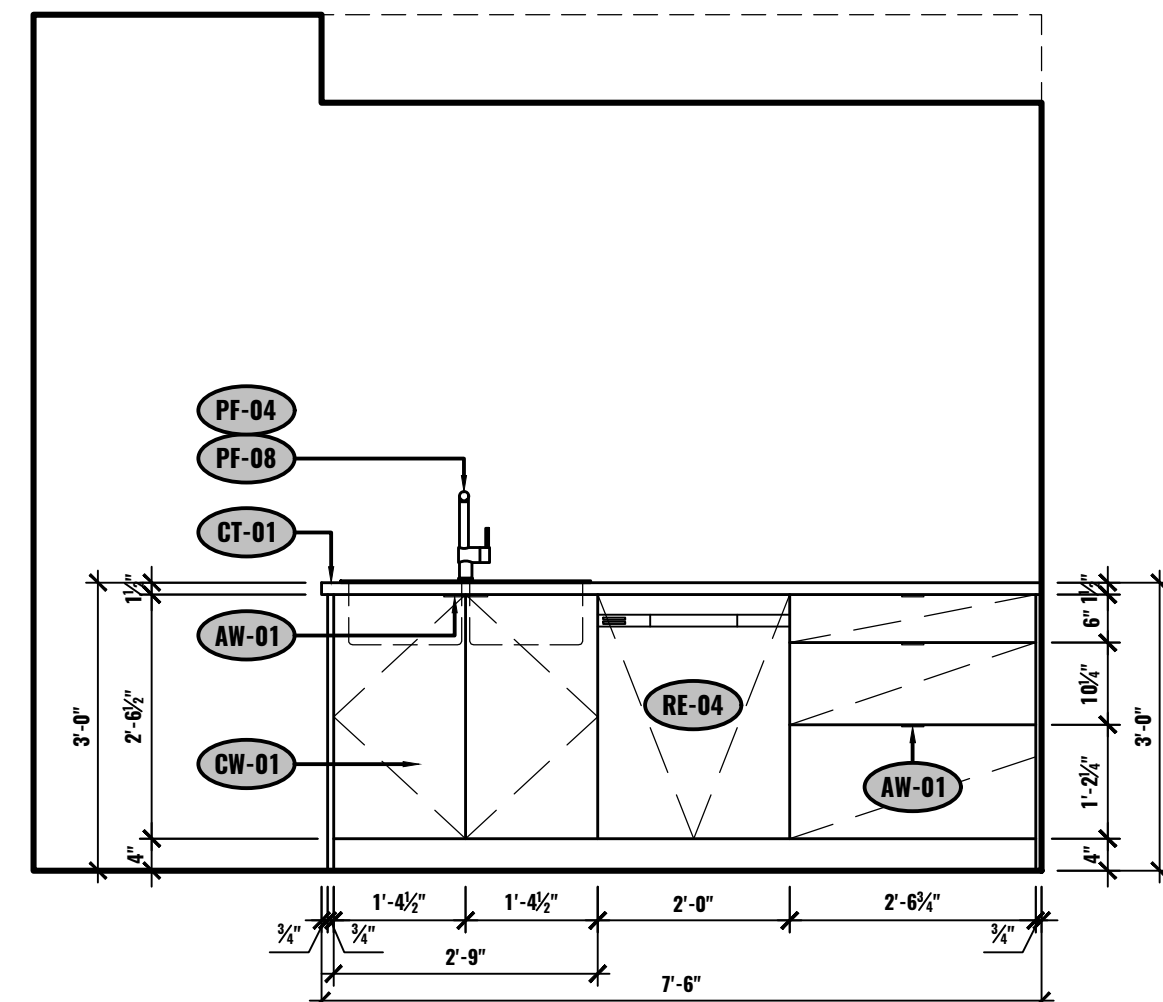


H ELEVATION - KITCHEN
UNIT #603
1/2"=1'-0"

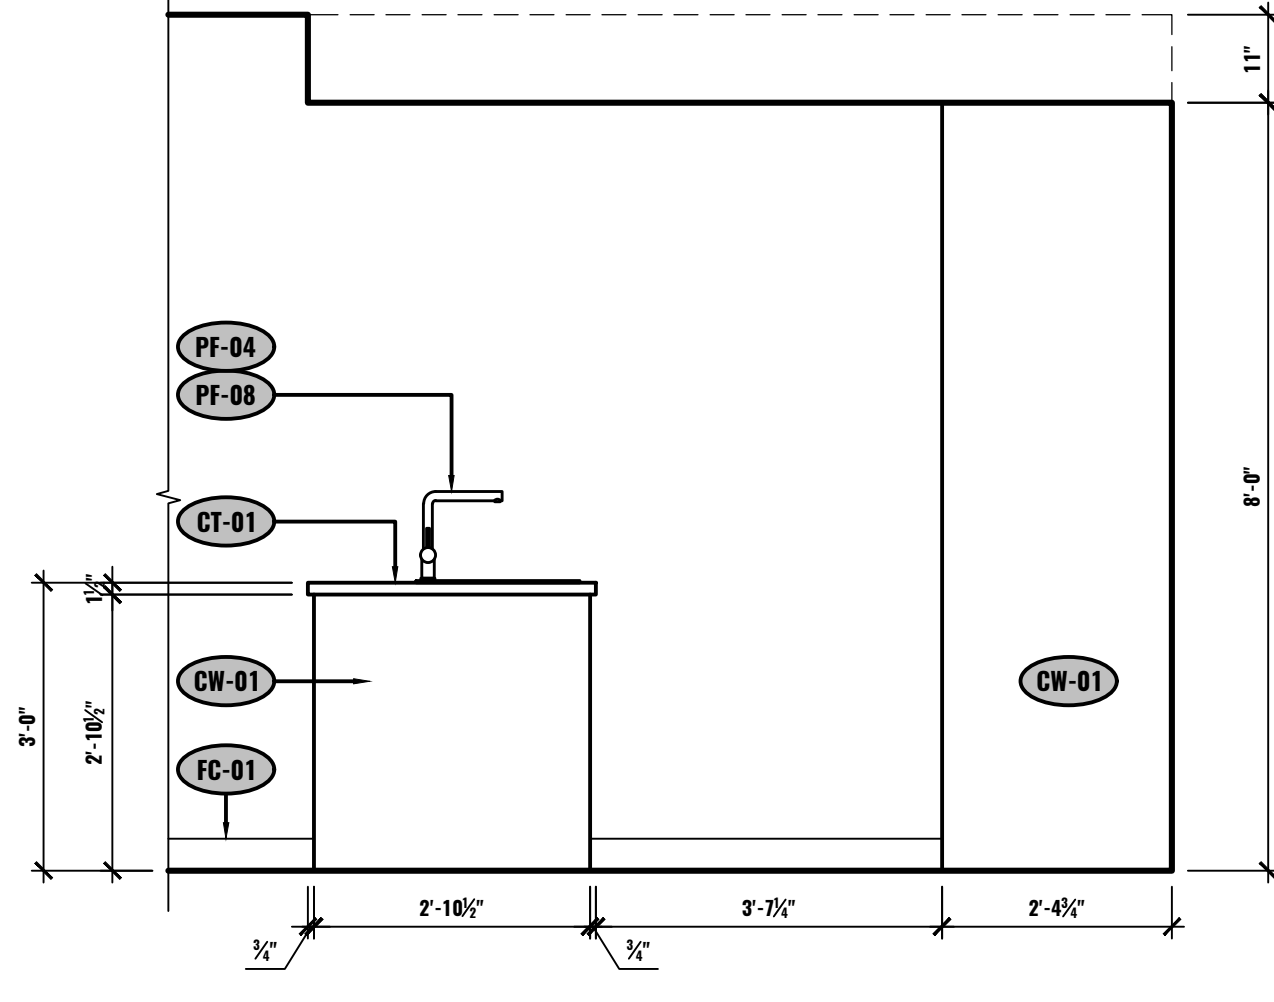


J ELEVATION - KITCHEN
UNIT #603
1/2"=1'-0"

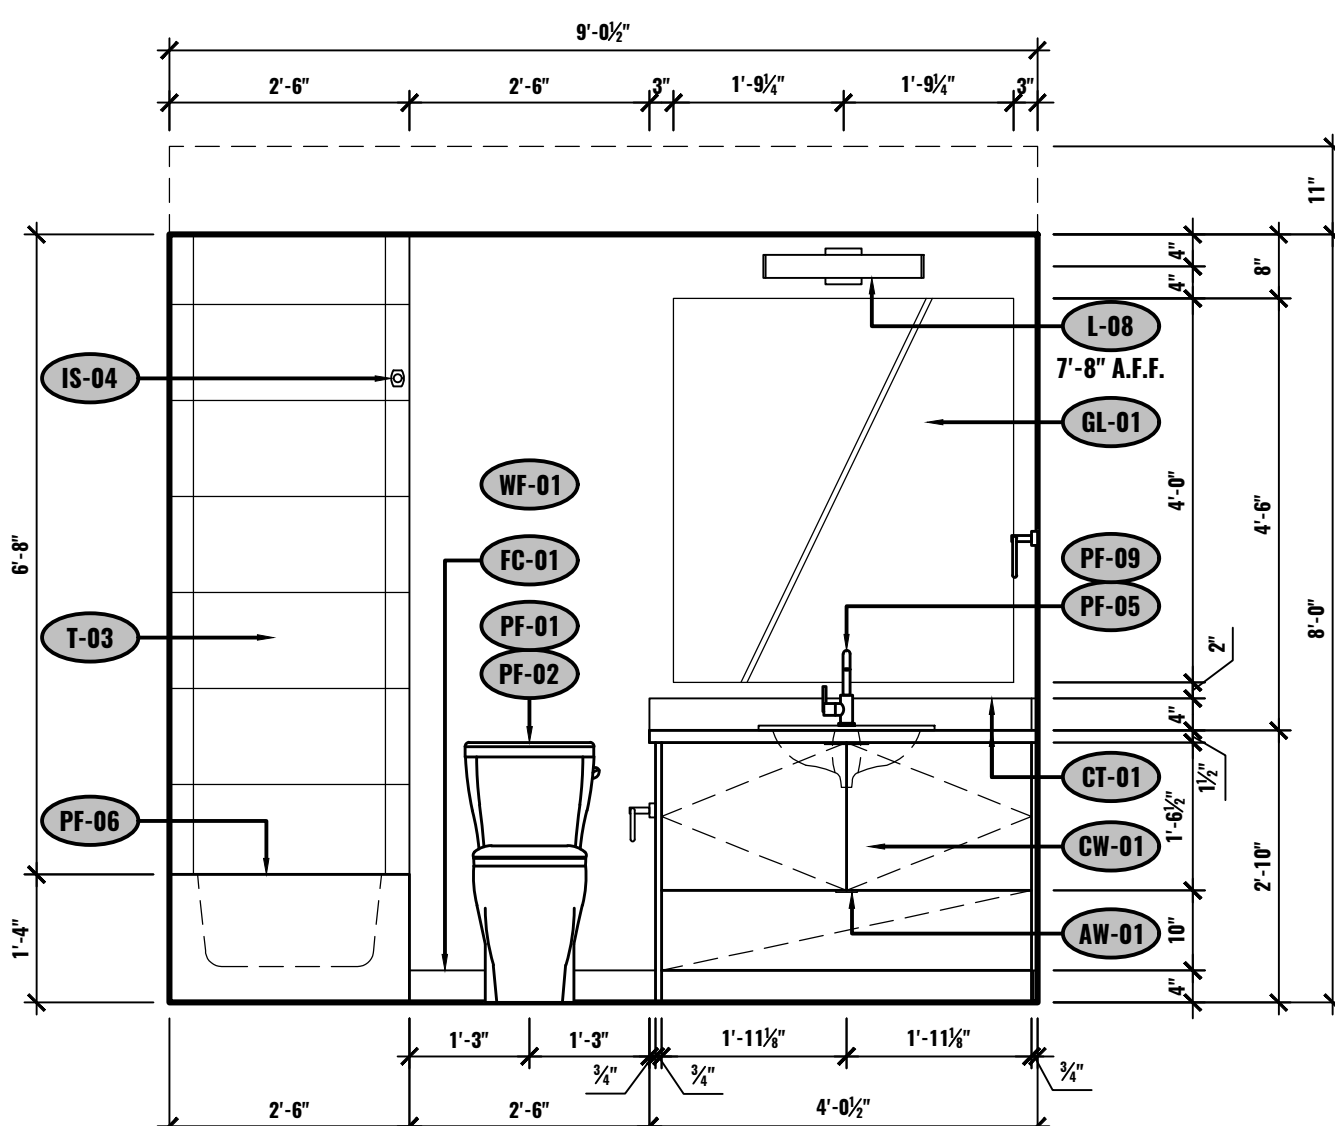


K ELEVATION - BATHROOM
UNIT #603
1/2"=1'-0"

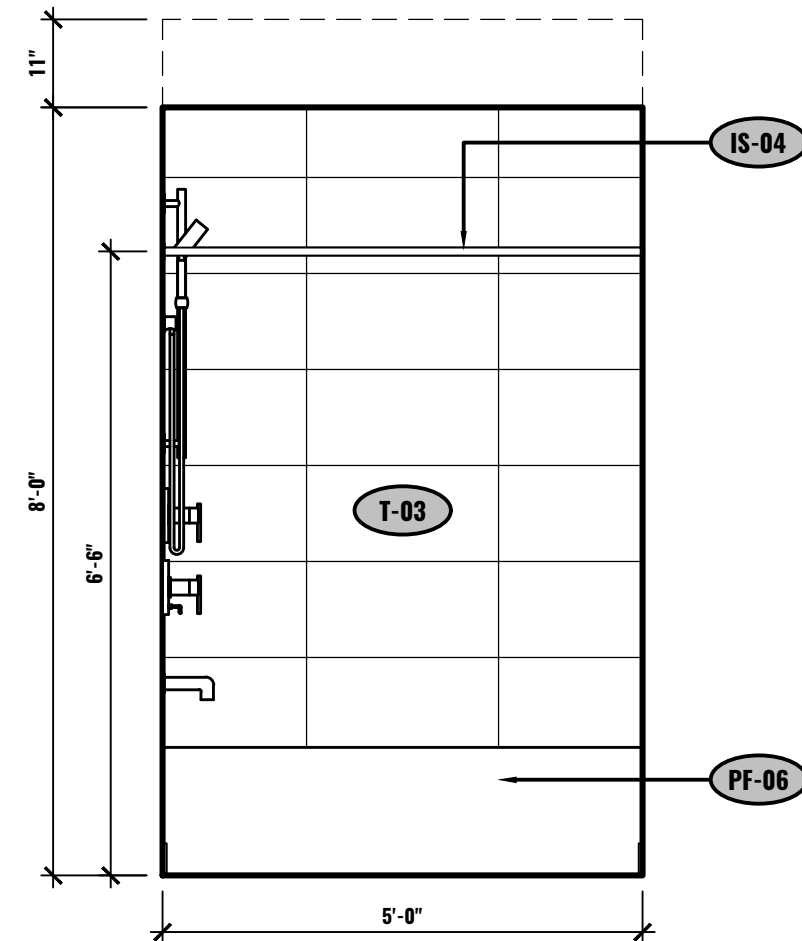


L ELEVATION - BATHROOM
UNIT #603
1/2"=1'-0"

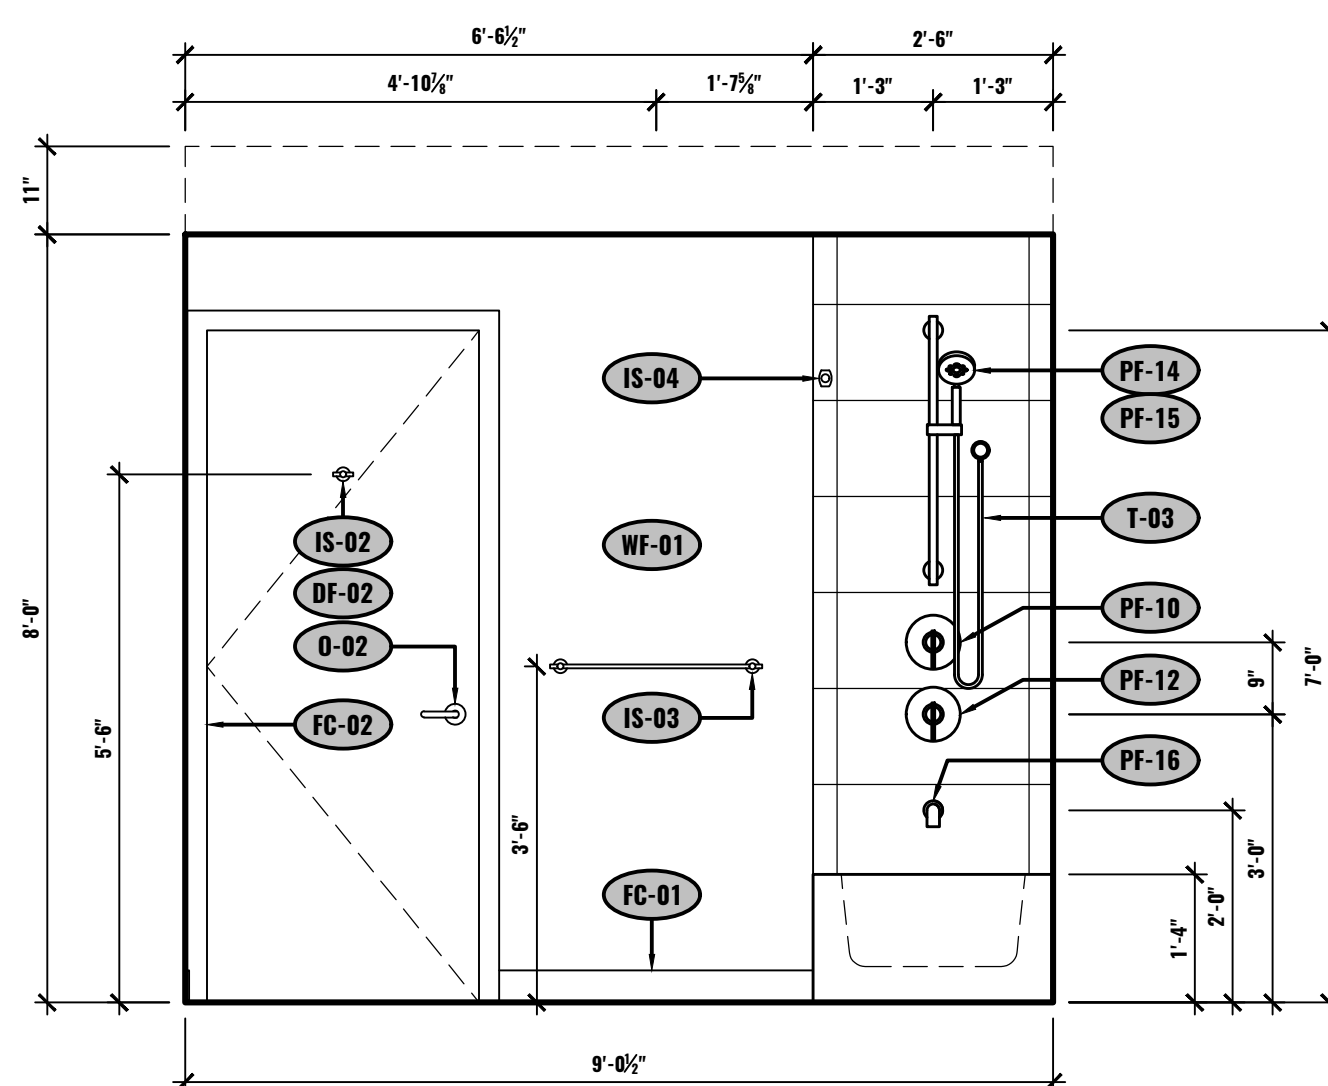


M ELEVATION - BATHROOM
UNIT #603
1/2"=1'-0"

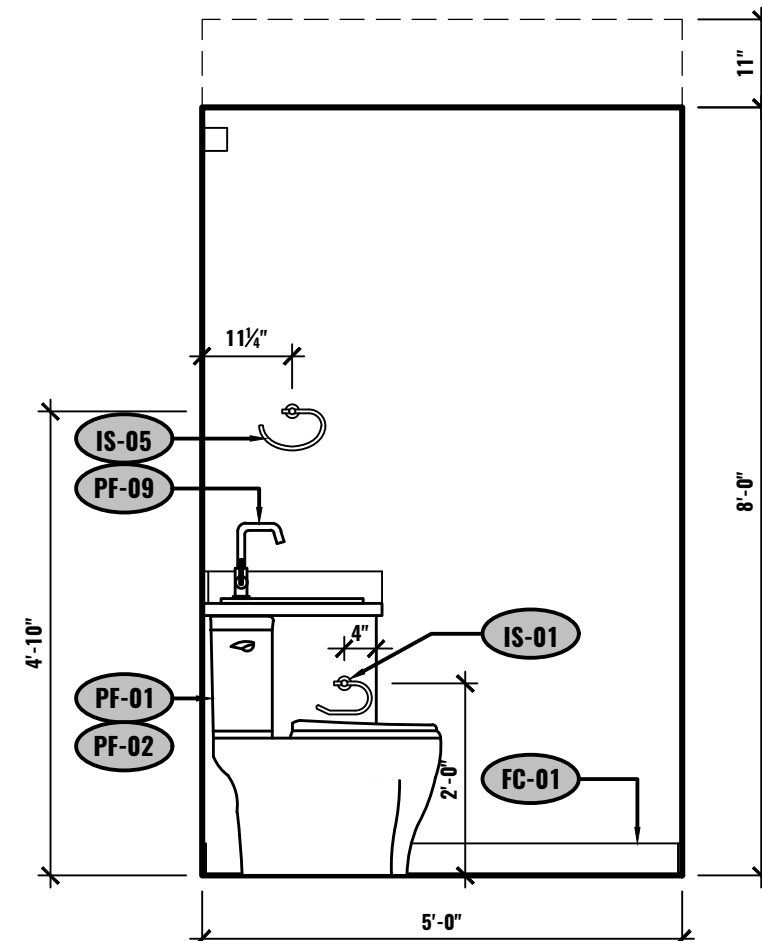


N ELEVATION - BATHROOM
UNIT #603
1/2"=1'-0"

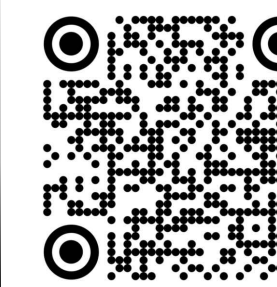


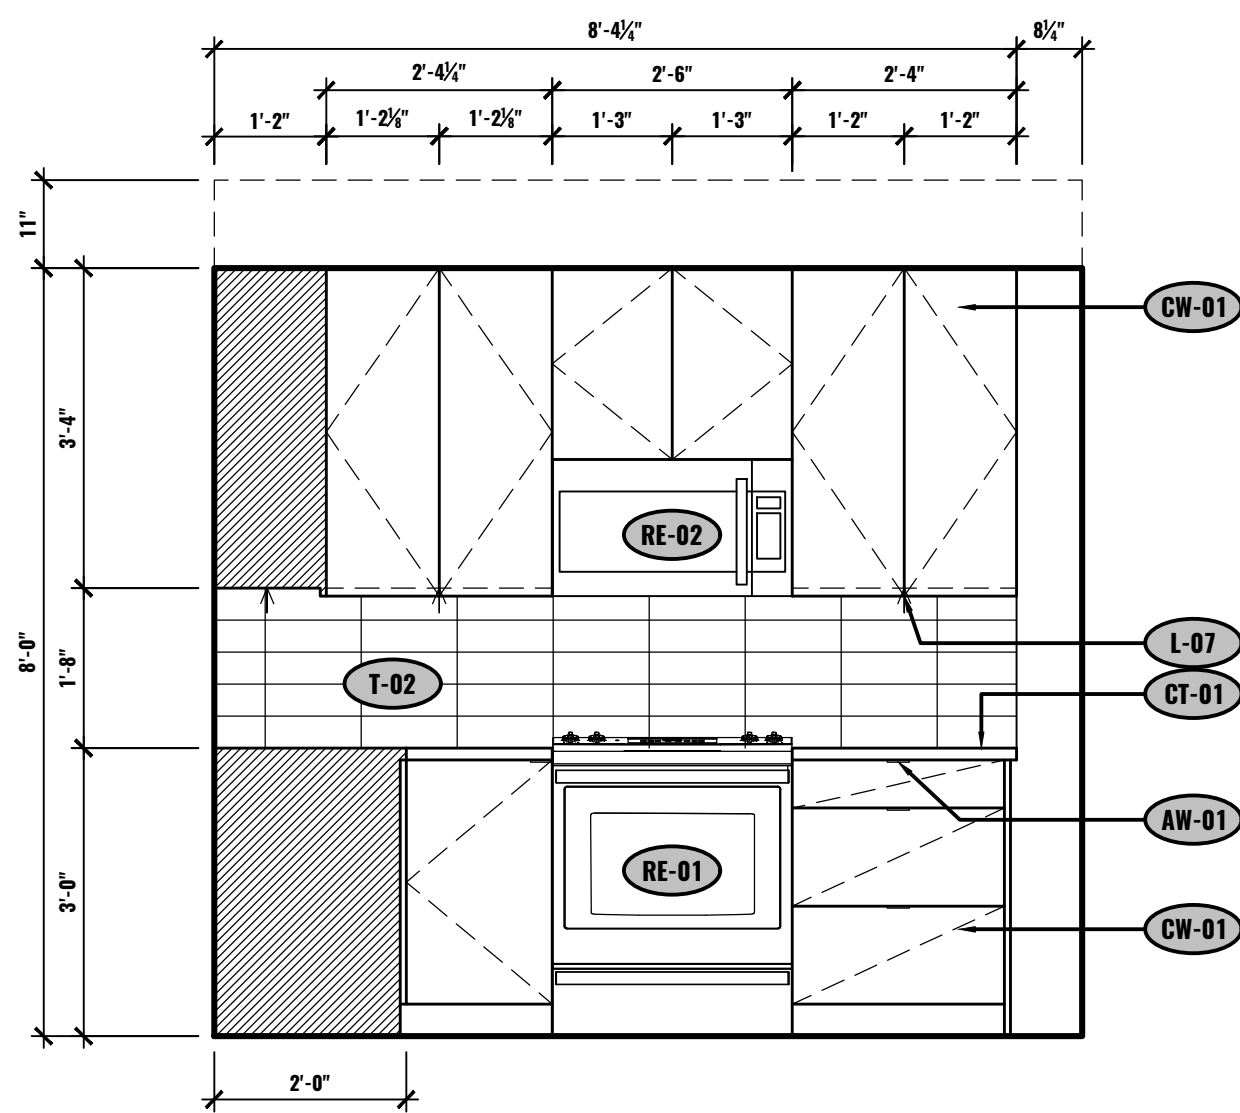


A ELEVATION - KITCHEN
UNIT #604
1/2"=1'-0"

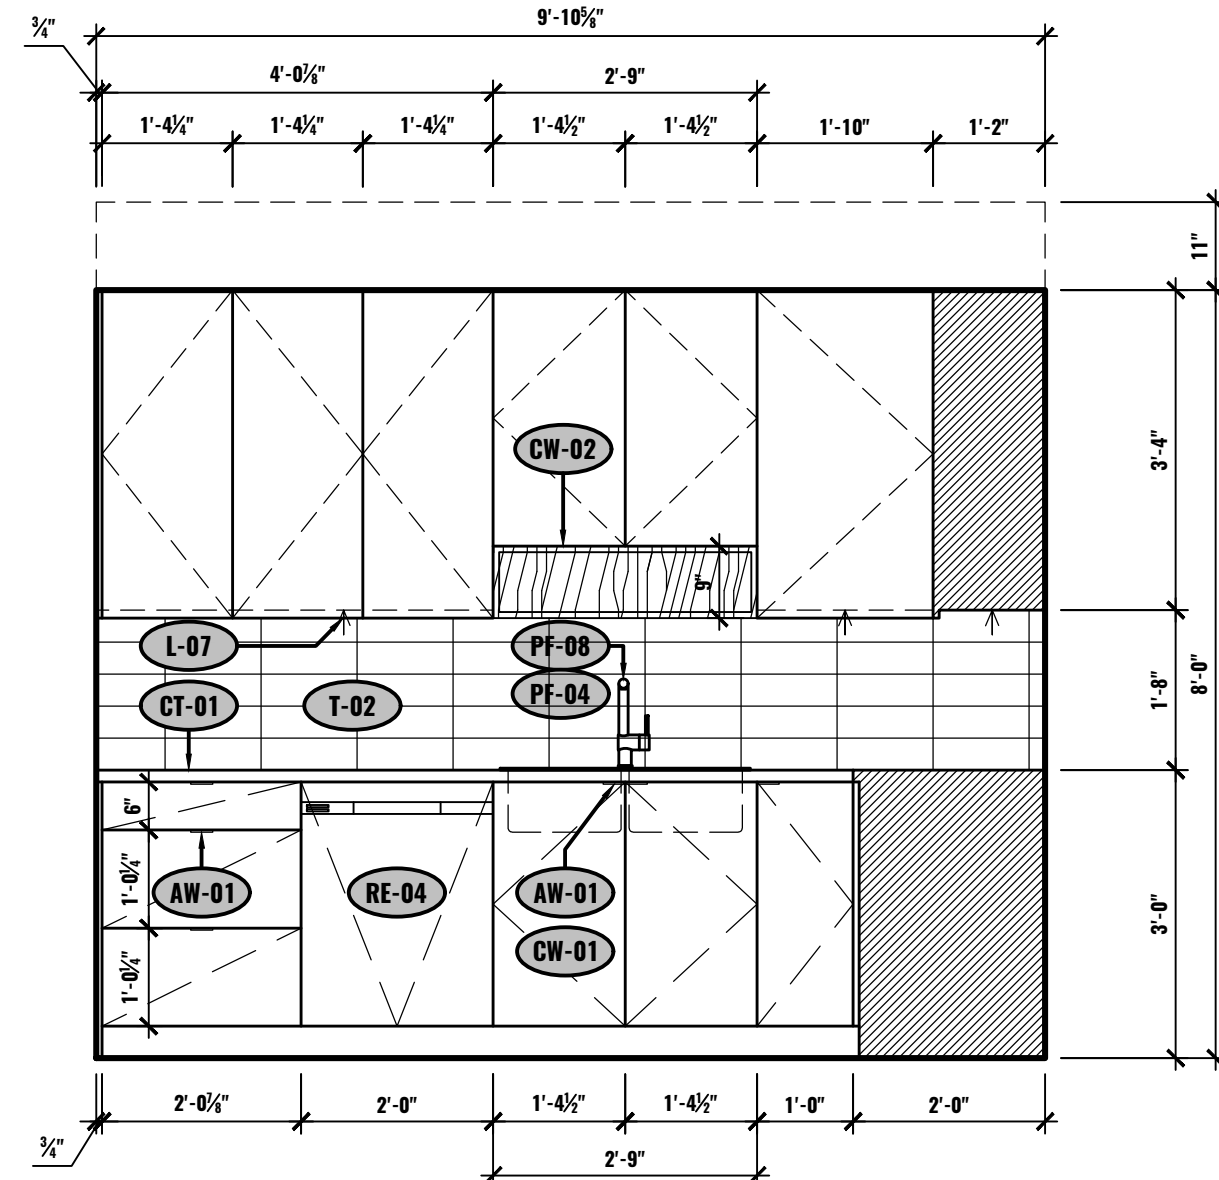


B ELEVATION - KITCHEN
UNIT #604
1/2"=1'-0"

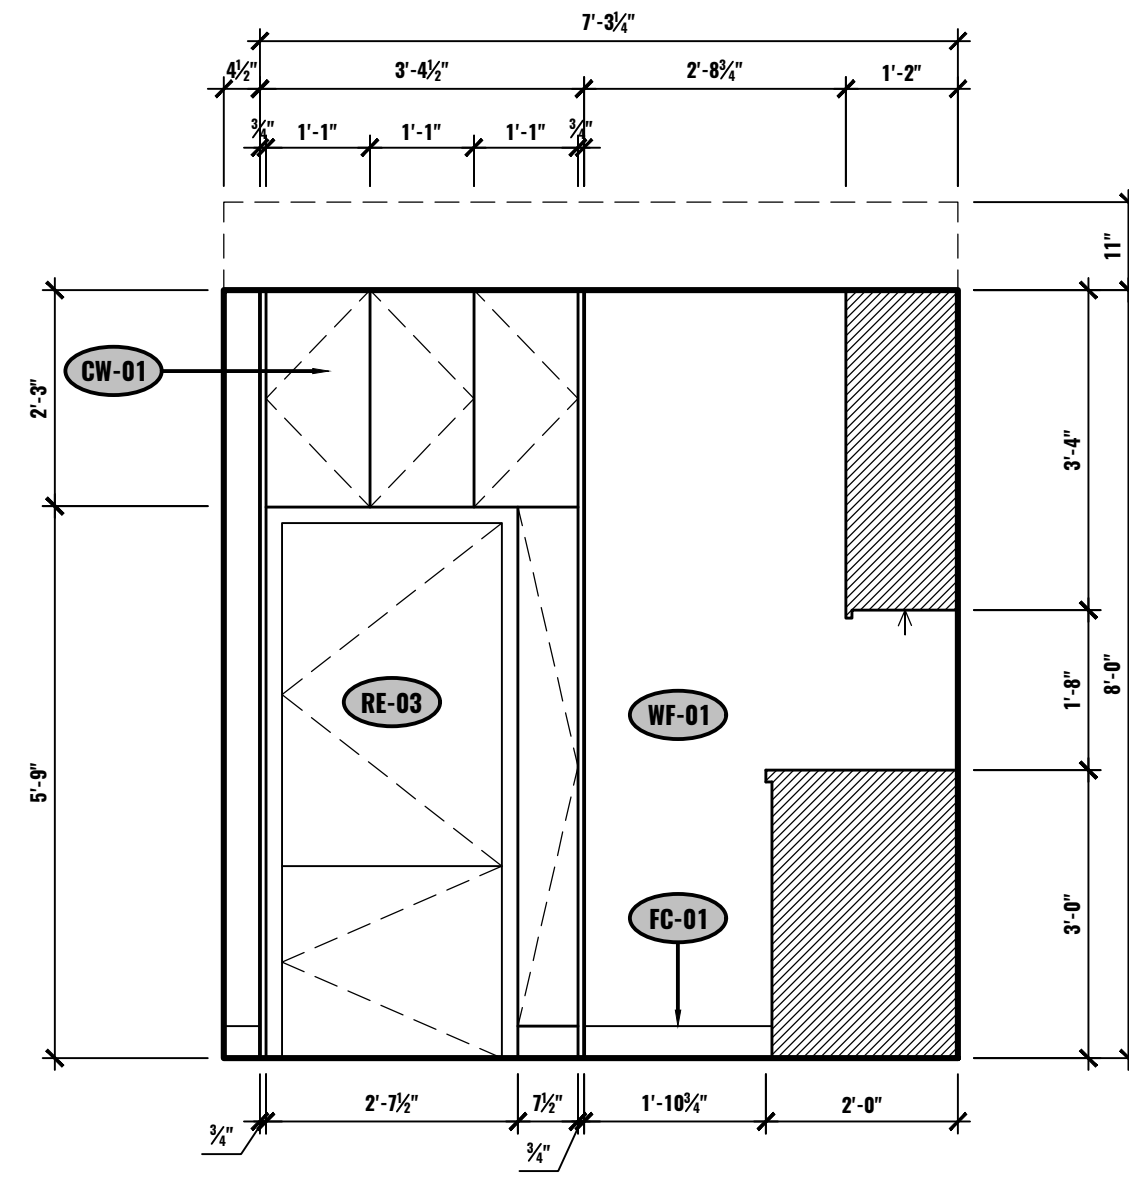


C ELEVATION - KITCHEN
UNIT #604
1/2"=1'-0"

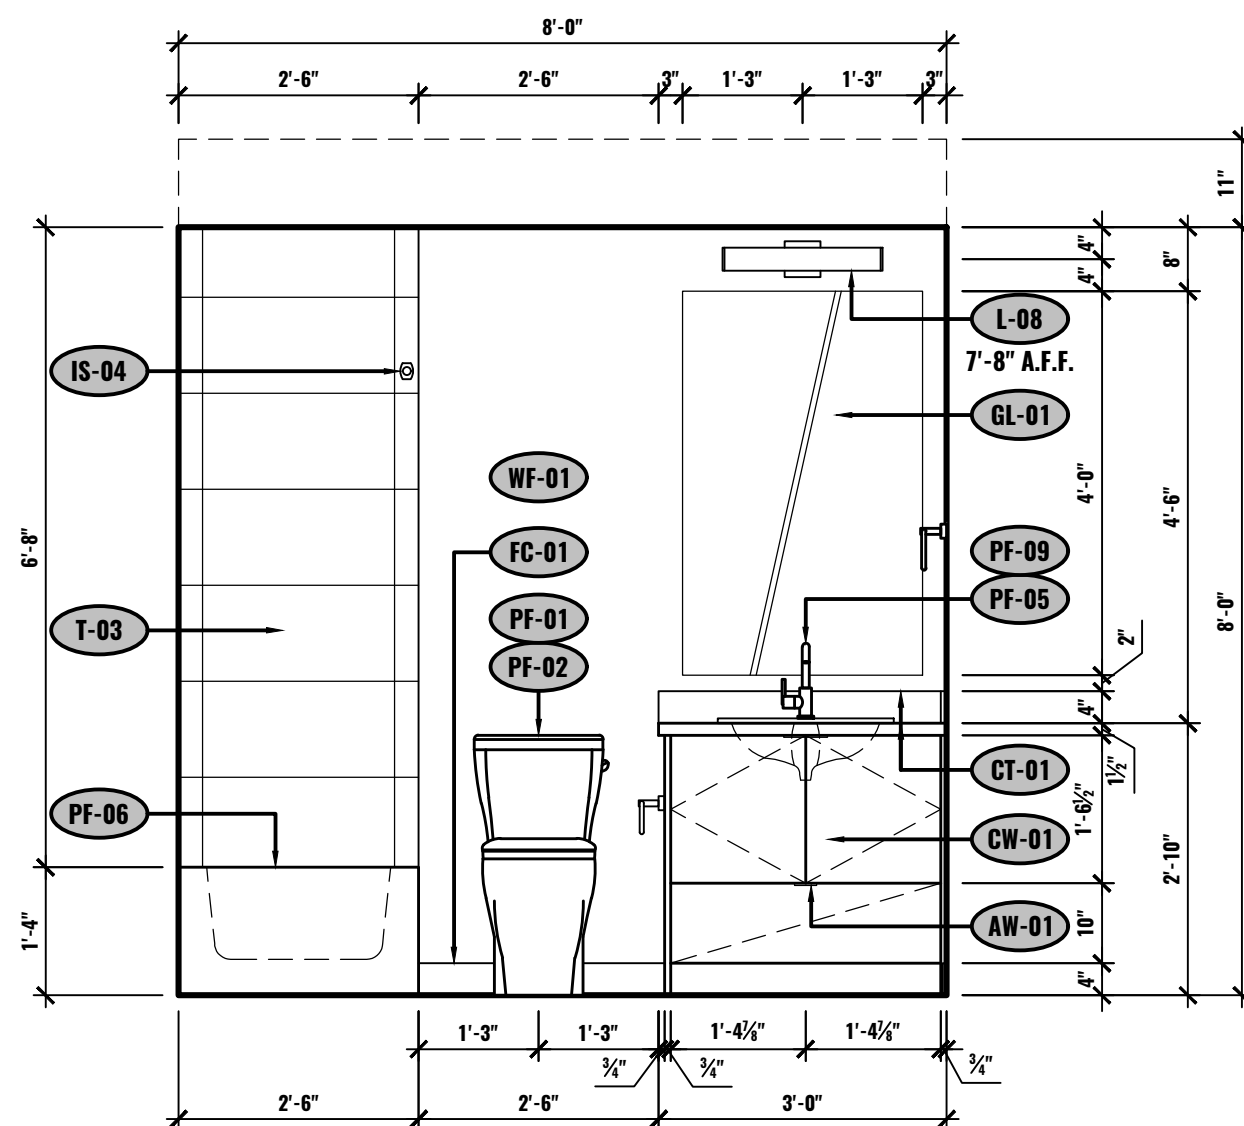


D ELEVATION - BATHROOM
UNIT #604
1/2"=1'-0"

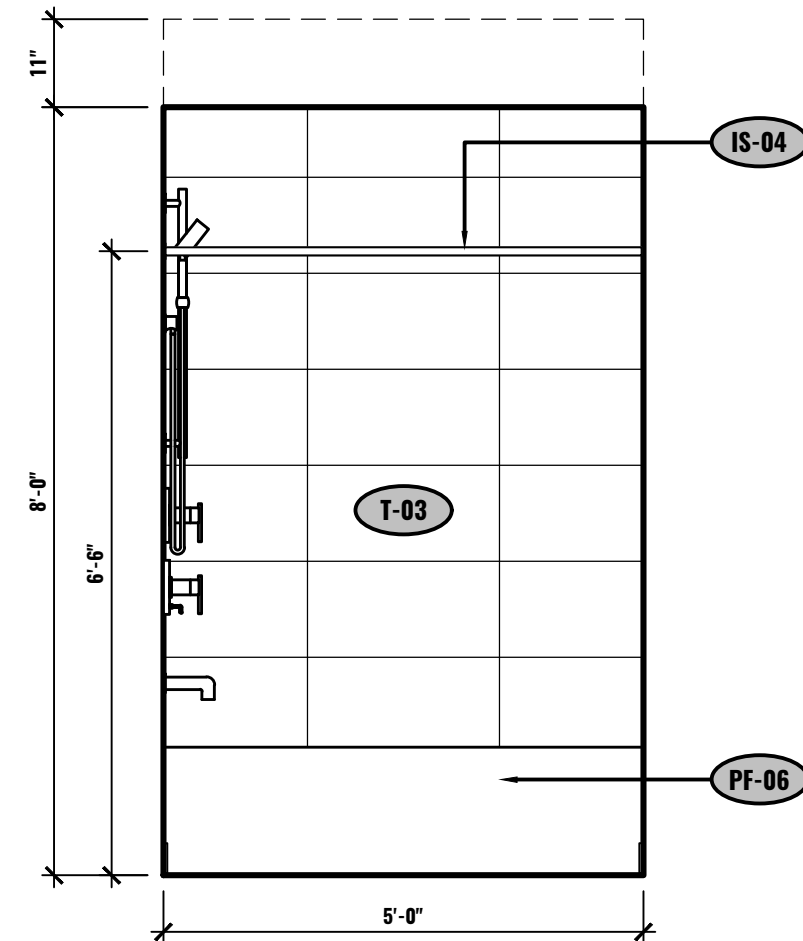

E ELEVATION - BATHROOM
UNIT #604
1/2"=1'-0"

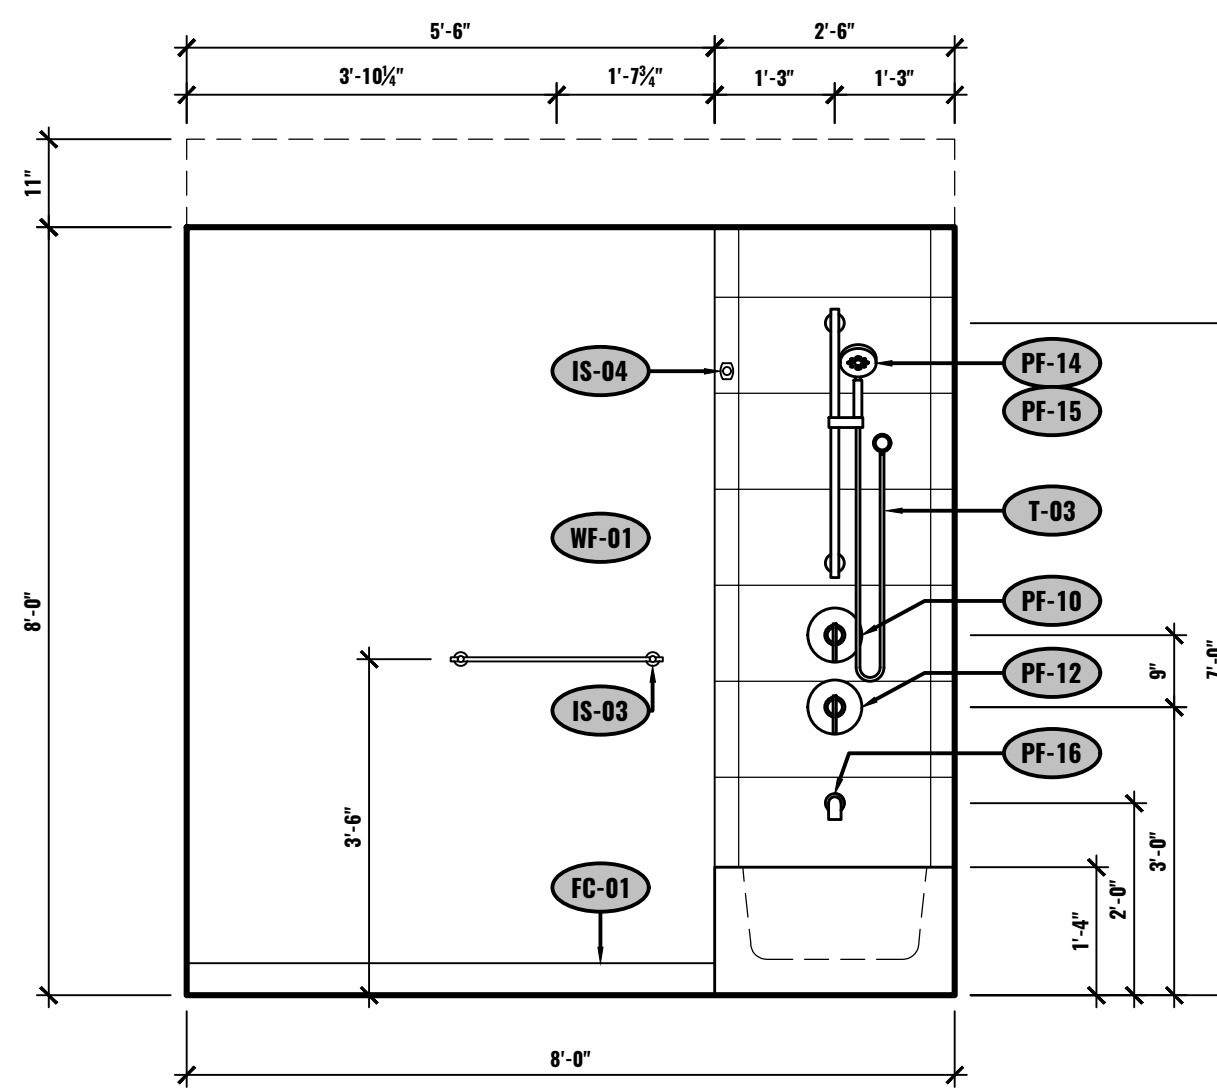

F ELEVATION - BATHROOM
UNIT #604
1/2"=1'-0"

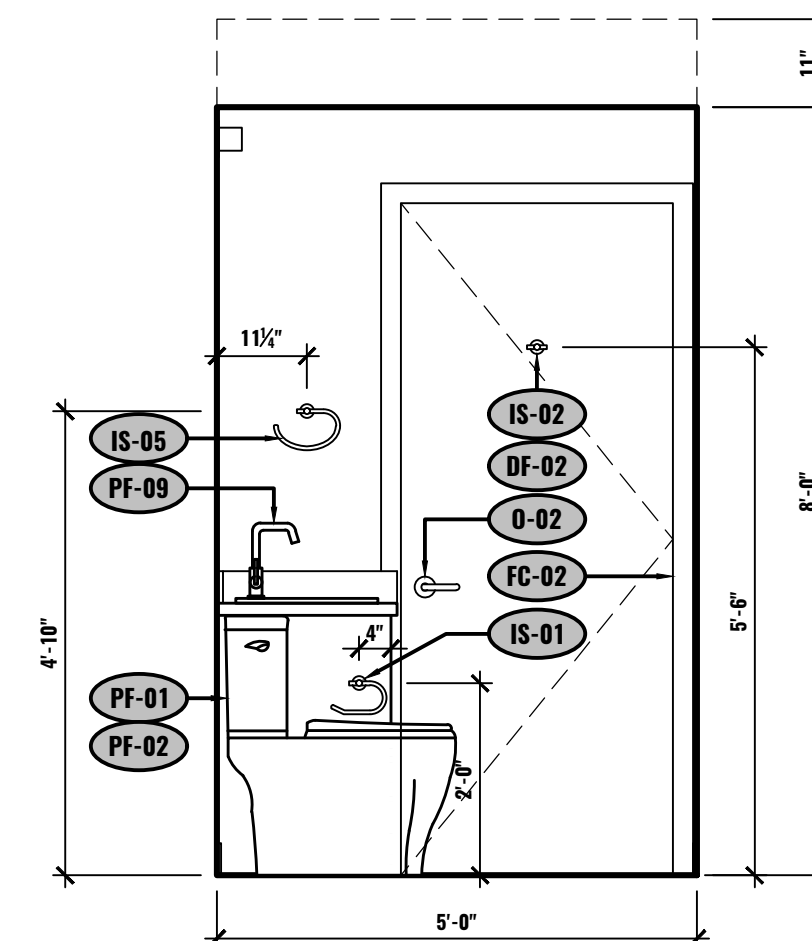

G ELEVATION - BATHROOM
UNIT #604
1/2"=1'-0"

